

 
IMPORTANT DISCLAIMER
 THE ENCLOSED INFORMATION IS INTENDED TO ASSIST AND INFORM YOU THROUGH THE CONSTRUCTION OF YOUR HOME. YOUR CONSTRUCTION PLANS HAVE BEEN DRAWN TO PRESCRIBE TO INDUSTRY STANDARDS. THESE PROFESSIONAL STANDARDS DETERMINE HOW CONSTRUCTION PLANS ARE DRAWN AND WHAT INFORMATION THEY INCLUDE. CONSTRUCTION PLANS ARE INTENDED AS A TECHNICAL GUIDE TO PROFESSIONAL CONTRACTORS AND ARE NOT INTENDED TO BE A SET OF STEP-BY-STEP INSTRUCTIONS. THEREFORE, IF YOU ARE PLANNING TO BUILD YOUR HOME WITHOUT THE SERVICE OF A PROFESSIONAL BUILDER, WE SUGGEST THAT YOU BECOME THOROUGHLY FAMILIAR WITH READING CONSTRUCTION PLANS OR CONSIDER CONSULTING A CONSTRUCTION SPECIALIST. GREAT CARE AND EFFORT GOES INTO THE DESIGN AND CREATION OF THE CONSTRUCTION PLANS; HOWEVER, BECAUSE OF THE IMPOSSIBILITY OF PROVIDING ANY PERSONAL AND/OR "ON-SITE" CONSULTATION, SUPERVISION AND CONTROL OVER THE ACTUAL CONSTRUCTION, AND BECAUSE OF THE GREAT VARIANCES IN LOCAL BUILDING CODE REQUIREMENTS AND OTHER GEOGRAPHIC LOCATION AND WEATHER CONDITIONS, [REDACTED] NOR THE AGENTS OR EMPLOYEES ASSUMES NO RESPONSIBILITY FOR ANY DAMAGES INCLUDING BUT NOT LIMITED TO, ANY DELAY, OMISSIONS, OR ERRORS IN THE DESIGN. IN ANY CASE, ANY DISCREPANCIES, ERRORS, AND/OR OMISSIONS IN THE DIMENSIONS, AND/OR DRAWINGS CONTAINED IN THE CONSTRUCTION PLANS SHALL BE BROUGHT TO THE ATTENTION OF [REDACTED] PRIOR TO COMMENCEMENT OF CONSTRUCTION. PROCEEDING WITH CONSTRUCTION CONSTITUTES THE ACCEPTANCE OF THE CONSTRUCTION DOCUMENTS 'AS IS' AND ANY DISCREPANCIES, ERRORS, AND/OR OMISSIONS BECOME THE SOLE RESPONSIBILITY OF THE PURCHASER. IF ANY ERRORS ARE DISCOVERED PRIOR TO CONSTRUCTION HOUSE PLAN ZONE, LLC, WILL BE GIVEN FULL OPPORTUNITY TO CORRECT ANY ERRORS AND/OR OMISSIONS TO THE CONSTRUCTION PLANS. IN ANY OR ALL CIRCUMSTANCES, THE MAXIMUM FINANCIAL LIABILITY TO HOUSE PLAN ZONE, LLC, CAN NOT EXCEED THE TOTAL PLAN PURCHASE.

PROFESSIONAL SEAL/ADDITIONAL DRAWINGS
 THOUGH EVERY EFFORT WAS MADE TO MAKE THE CONSTRUCTION DOCUMENTS FOLLOW THE I.R.C. NATIONAL CODE METHODOLOGIES, A FEW STATES AND CITIES HAVE PASSED B-LAWS REGARDING CONSTRUCTION PLANS THAT WOULD BE SUBMITTED TO YOUR LOCAL MUNICIPALITY AND USED FOR THE CONSTRUCTION OF YOUR HOME. THESE B-LAWS REQUIRE THE CONSTRUCTION PLANS TO BE REVIEWED AND/OR PREPARED, INSPECTED, AND SEALED (OR STAMPED) BY A LICENSED ARCHITECT/ENGINEER IN YOUR STATE. IT IS ADVISED THAT YOU CONTACT YOUR MUNICIPALITY'S BUILDING DEPARTMENT FOR INSTRUCTIONS TO COMPLY WITH THEIR CONSTRUCTION PLANS REVIEW PROCESS. FURTHERMORE, ADDITIONAL ITEMS SUCH AS STRUCTURAL, HVAC, PLUMBING, SITE, ENERGY EFFICIENCY DOCUMENTATION, ETC. MAY BE REQUIRED AND THESE SHALL BE PROVIDED BY A LOCAL PROFESSIONAL THAT IS FAMILIAR WITH THE REQUIREMENTS AND THESE SHALL BE PROVIDED AT THE OWNERS EXPENSE.

OTHER IMPORTANT INFORMATION
MATERIALS LIST DISCLAIMER - IF A MATERIALS LIST WAS ORDERED, IT WILL ONLY CONFORM TO THE PLAN IN ITS ORIGINAL FORMAT. ADDITIONAL OPTIONS SUCH AS 2X6 EXTERIOR WALLS, BASEMENT, OR WALKOUT BASEMENT FOUNDATIONS, THREE CAR GARAGE VERSIONS, ETC. WILL NOT BE REFLECTED IN THE LIST. WHILE IT WILL NOT MATCH THESE OPTIONS, THE LIST IS STILL A GREAT REFERENCE DOCUMENT FOR THE MATERIALS THAT WILL BE REQUIRED TO CONSTRUCT YOUR HOME.
FOUNDATIONS - MOST OF OUR FOUNDATIONS ARE DESIGNED WITH CONCRETE BLOCK STEM WALLS AND NOT POURED-IN-PLACE CONCRETE. ADDITIONALLY, THE MAJORITY OF OUR SLAB FOUNDATIONS ARE DESIGNED WITH A CHAIN WALL (RAISED) SLAB AND NOT MONOLITHIC (SLAB ON GRADE). CONTRACTOR/LOCAL ENGINEER SHALL ADJUST DESIGN AS NEEDED FOR YOUR SPECIFIC AREA NEED.
SQUARE FOOTAGES - BONUS ROOMS (WHERE APPLICABLE) ARE NOT INCLUDED IN THE HEATED AREA OF THE DESIGN UNLESS SPECIFICALLY NOTED. GARAGE PLANS ARE EXCLUDED. SQUARE FOOTAGES SHOWN ARE CALCULATED TO THE OUTSIDE OF THE STUD WALL AND DO NOT INCLUDE THE EXTERIOR MATERIALS SUCH AS BRICK, STONE, OR SIDING.
DIMENSIONS - OUR PLANS ARE DIMENSIONED TO THE OUTSIDE OF THE STUD WALL ONLY AND NOT TO THE OUTSIDE OF THE BRICK LEDGE (WHERE APPLICABLE).

COPYRIGHTS
 REPRODUCTION OF THESE CONSTRUCTION PLANS, EITHER IN WHOLE OR IN PART, INCLUDING ANY FORM COPYING AND/OR PREPARATION OF A DERIVATIVE WORKS THEREOF, FOR ANY REASON IS STRICTLY PROHIBITED. THE PURCHASE OF A SET OF CONSTRUCTION PLANS IN NO WAY TRANSFERS ANY COPYRIGHT OR OTHER OWNERSHIP INTEREST IN IT TO THE PURCHASER EXCEPT FOR A LIMITED LICENSING RELEASE TO USE THE SAID PLAN SET FOR CONSTRUCTING ONE AND ONLY ONE DWELLING UNIT. THE PURCHASE OF ADDITIONAL SETS OF THE SAID PLANS AT A REDUCED PRICE FROM THE ORIGINAL SET OR AS PART OF A MULTIPLE SET PACKAGE DOES NOT CONVEY TO THE PURCHASER A LICENSE TO CONSTRUCT MORE THAN ONE DWELLING. SIMILARLY, THE PURCHASE OF REPRODUCIBLE CONSTRUCTION PLANS (A.K.A. CEPAS, MYLARS, OR YELLUMS) CARRIES THE SAME COPYRIGHT PROTECTION AS MENTIONED ABOVE. IT IS GENERALLY ALLOWED TO MAKE A MAXIMUM OF 10 COPIES FOR THE CONSTRUCTION OF A SINGLE DWELLING ONLY. TO USE ANY PLAN MORE THAN ONCE, AND TO AVOID ANY COPYRIGHT/LICENSING INFRINGEMENT, IT IS NECESSARY TO CONTACT THE ORIGINAL DESIGNER TO RECEIVE A LICENSE FOR ANY EXTENDED USAGE. WHEREAS A PURCHASER OF REPRODUCIBLES IS GRANTED A LICENSE TO MAKE COPIES, IT SHOULD BE NOTED THAT AS COPYRIGHTED MATERIALS, MAKING PHOTOCOPIES FROM CONSTRUCTION PLANS IS ILLEGAL. COPYRIGHT AND LICENSEE OF CONSTRUCTION PLANS EXIST TO PROTECT ALL PARTIES. IT RESPECTS AND SUPPORTS THE INTELLECTUAL PROPERTY OF THE ORIGINAL ARCHITECT AND/OR DESIGNER, THEREBY KEEPING IT POSSIBLE TO OFFER PRE-DRAWN PLANS AT AFFORDABLE PRICES. COPYRIGHT LAW FOR PRE-DRAWN CONSTRUCTION PLANS IS NOW BEING VIGOROUSLY ENFORCED. COPYRIGHT INFRINGEMENT COULD LEAD TO FINES OF UP TO \$100,000 PER VIOLATION.

GENERAL SITE NOTES
 1. CONTRACTOR TO VERIFY LOCATIONS OF SITE UTILITIES, REQUIREMENTS, AND CONNECTIONS FEES. OWNER, CONTRACTOR AND SUB-CONTRACTORS TO PAY ALL OF THEIR RELATED CONSTRUCTION PERMIT FEES AS AGREED UPON BETWEEN THE OWNER AND CONTRACTOR.
 2. BEFORE EXCAVATION, THE CONTRACTOR SHALL EXAMINE ALL DRAWINGS, MAPS, AND BUILDING SITE TO DETERMINE THE ROUTES OF ALL UNDERGROUND UTILITIES.
 BEFORE DIGGING COMMENCES IT IS ADVISED THAT THE OWNER AND OR CONTRACTOR CALL THEIR STATES UTILITY LOCATOR FACILITATOR.
 3. IT IS RECOMMENDED THAT THE SITE'S SOIL BE TESTED FOR COMPRESSION RATINGS TO DETERMINE FOUNDATION AND FOOTING DESIGN. CONCRETE FOUNDATIONS AND FOOTING DESIGN SHALL BE IN ACCORDANCE TO CHAPTER 4 OF THE I.R.C. CODE. FOUNDATION DESIGN TO BE VERIFIED BY A LOCAL PROFESSIONAL OR ENGINEER. CONSULT A LOCAL CIVIL ENGINEER FOR SITE PLANS AND SURVEYS OF EXISTING PROPERTY. A LANDSCAPE ARCHITECT SHOULD BE CONSULTED FOR MORE EXTENSIVE LANDSCAPE DESIGNS.



FOUNDATION TYPE: SLAB
 EXTERIOR WALL SIZE: 2x4 EXT. WALLS

STANDARD ABBREVIATIONS

@	AT	LT.	LIGHT
#	FOUND(S)	LIN.	LINEN
APPROX.	APPROXIMATELY	MANUF.	MANUFACTURER
BASE.	BASEMENT	MAS.	MASONRY
BT	BETWEEN	MAX.	MAXIMUM
BLK	BLOCK	MTL.	METAL
BLDG	BLOCKING	MIN.	MINIMUM
BD.	BOARD	N.I.C.	NOT IN CONTRACT
BRD.	BOARD	O.C.	ON CENTER
BOT.	BOTTOM	O/C	ON CENTER
BLDG.	BUILDING	OPT.	OPTIONAL
CAB.	CABINET	O.S.B.	ORIENTED STRAND BOARD
CLG.	CELLING	OTS	OWNER TO SELECT
CLF.	CLEAR	O.T.S	OWNER TO SELECT
CLSB.	CLSBET		
COL.	COLUMN	PG.	PAGE
COLS.	COLUMNS	PAN.	PANTRY
CONG.	CONCRETE	PL.	PLATE
CMU	CONCRETE MASONRY UNIT	P	PLATE
C.U.	CONDENSOR UNIT	PLYWD	PLYWOOD
CONN.	CONNECTION	PLYND	PLYWOOD
CONT.	CONTINUOUS	POLY.	POLYETHYLENE
COVERG.	COVERING	PBI	POUNDS PER SQUARE INCH
CS	GRAPE SPACE	PRE-FAB	PREFABRICATED
DECO.	DECORATIVE	REF.	REFERENCE
DET.	DETAIL	REF.	REFRIGERATOR
DIA.	DIAMETER	REINF.	REINFORCED
DW	DISHWASHER	R	RESISTANCE
DBL.	DOUBLE	R.A.	RETURN AIR
DF	DOUGLAS FIR	R.A.S.	RETURN AIR GRILLE
D	DRYER	REQD.	REQUIRED
EA.	EACH	SCR.	SCREEN
ELEV.	ELEVATION	SHLV.	SHELVES
ENG.	ENGINEER	SHR.	SHOWER
		SHWR.	SHOWER
FT.	FEET	SST.	SIMPSON STRONG TIE
F.F.L.	FINISHED FLOOR LINE	SP	SOUTHERN PINE
FIN.	FINISH	SPECS.	SPECIFICATIONS
F.G.	FIRE CODE	SQ.	SQUARE
F.L.	FLOOR	S.F.	SQUARE FOOTAGE
FTG.	FOOTING	STL.	STEEL
FOUND.	FOUNDATION	THK.	THICK
FND.	FOUNDATION	THK.	THICKNESS
FR.	FREEZER	TBD.	TO BE DETERMINED
GA.	GAUZE	TR.	TRANSOM
GALV.	GALVANIZED	TYP.	TYPICAL
STP.	GYPSUM	U.T.C.	UNDER THE COUNTER
HDR.	HEADER	UTIL.	UTILITY
HVAC	HEATING, VENTILATION & AIR CONDITIONING	VAN.	VANITY
HT.	HEIGHT	VERT.	VERTICAL
HTS.	HEIGHTS		
HORIZ.	HORIZONTAL	WH.	WATER HEATER
IN.	INCHES	W.	WASHER
INCL.	INCLUDE	WT.	WEIGHT
INSUL.	INSULATION	WIN.	WINDOW
		WM.	WIRE MESH
		WV.	WATH
JT.	JOINT	WD.	WOOD
JST.	JOIST	WFGM.	WOOD FRAME
JSTS.	JOISTS		CONSTRUCTION MANUAL

SHEET INDEX:

- | | |
|---------------------|------------------------|
| 1. COVER SHEET | 8. ROOF PLAN |
| 2. FOUNDATION PLAN | 9. SECTION AND CABS |
| 3. FLOOR PLAN | 10. ELECTRICAL PLANS |
| 4. BONUS FLOOR PLAN | N1 I.R.C. CODE SHEET |
| 5. EXTERIOR VIEWS | N2 I.R.C. CODE SHEET |
| 6. EXTERIOR VIEWS | N3 I.R.C. CODE SHEET |
| 7. MISC. DETAILING | N4 I.R.C. ENERGY SHEET |

DESIGN DATA


MINIMUM SOIL BEARING CAPACITY = 2000 P.S.F. FOR GROUP II
 CONCRETE MINIMUM (28 DAYS) P.C:
 FOOTERS = 3000 P.S.I.
 SLABS & WALLS = 3000 P.S.I.
 REINFORCING STEEL: A.S.T.M. A615-60
 ROOF LIVE LOAD (GROUND SNOW LOAD) = 30 P.S.F.
 ROOF DEAD LOAD = 10 P.S.F.
 FLOOR LIVE LOAD = 40 P.S.F.
 30 P.S.F. SLEEPING AREAS
 FLOOR DEAD LOAD = 10 P.S.F.
 DECK LIVE LOAD = 40 P.S.F.
 DECK DEAD LOAD = 10 P.S.F.
 NOTE: ALL REQUIRED BRACE WALL PANELS LOCATED BY CONTRACTOR PER LOCAL CODE REQUIREMENTS.

N.C.B.D.C.
 NATIONAL COUNCIL OF
 BUILDING DESIGN PROFESSIONALS


Date: 04.22.20
 Drawn By: [REDACTED]

© COPYRIGHT
 ALL RIGHTS RESERVED


SHEET NUMBER
1

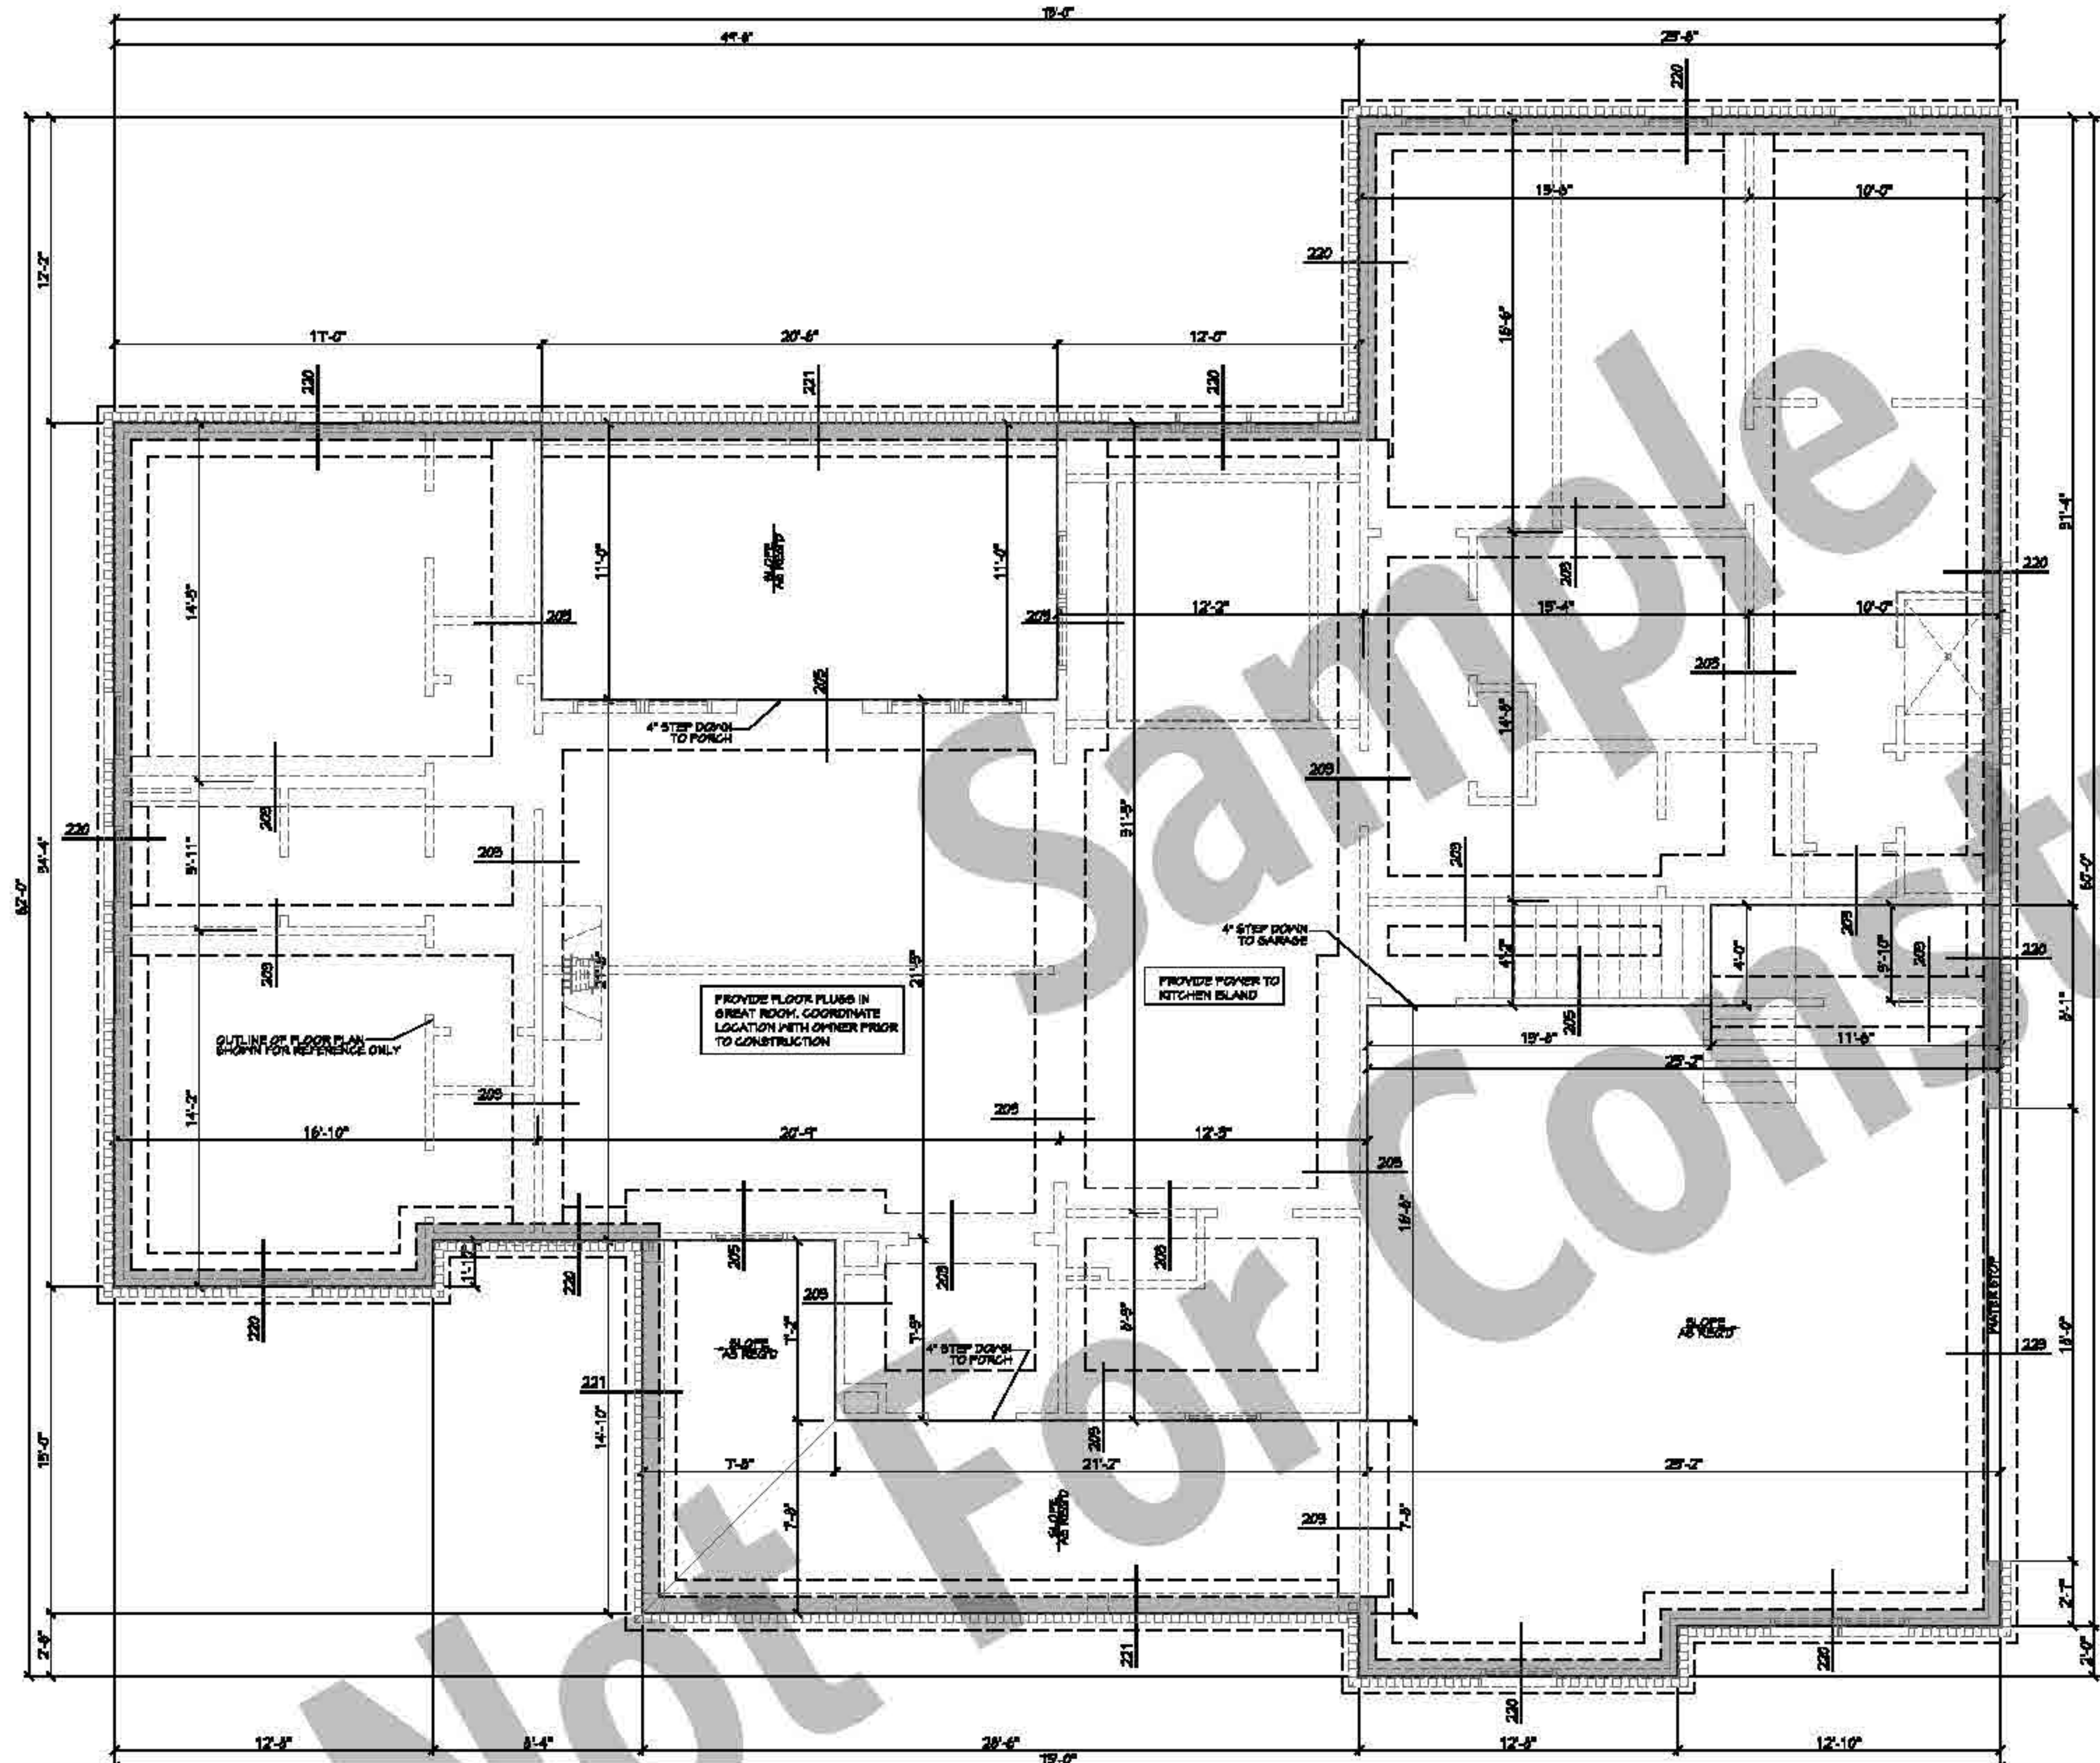


201 FOUNDATION PLAN
SCALE: 1/4" = 1'-0"

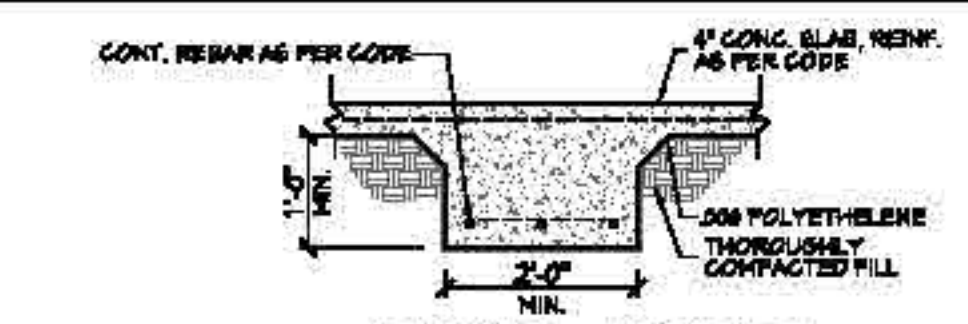


203 FTG. DET.

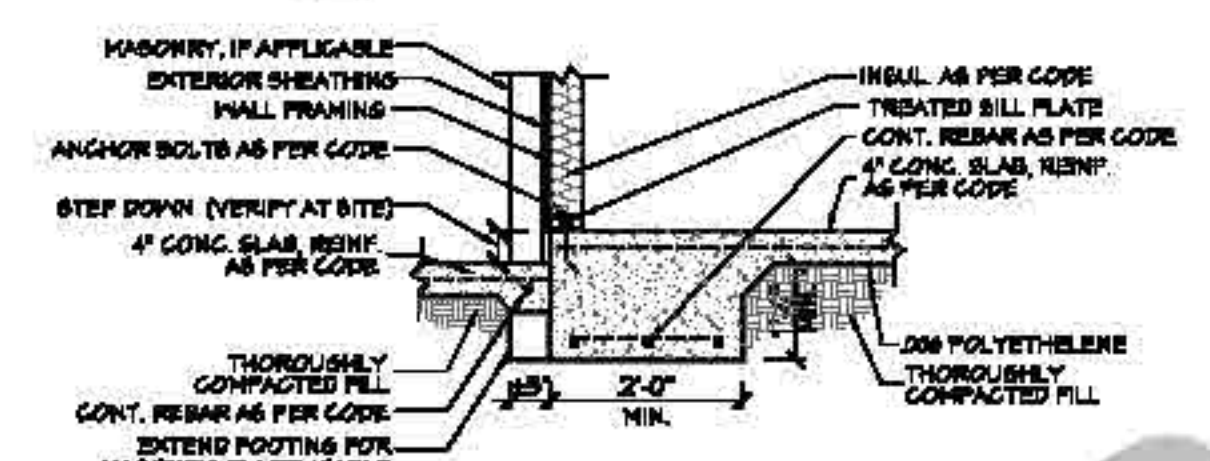


205 FTG. DET.

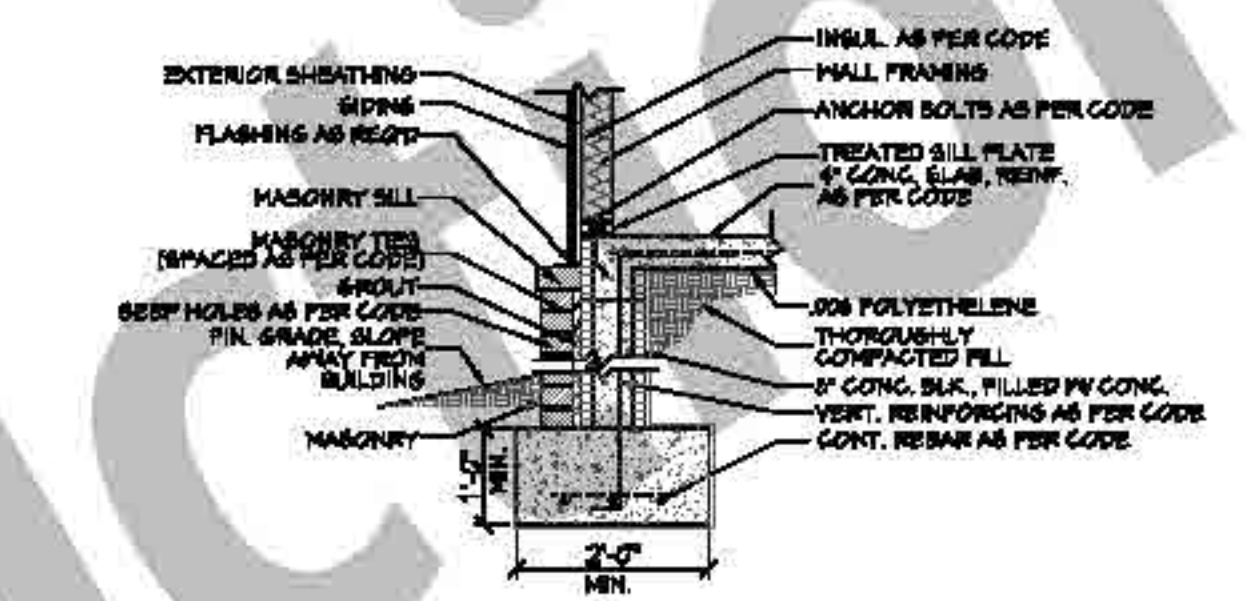

220 FTG. DET.

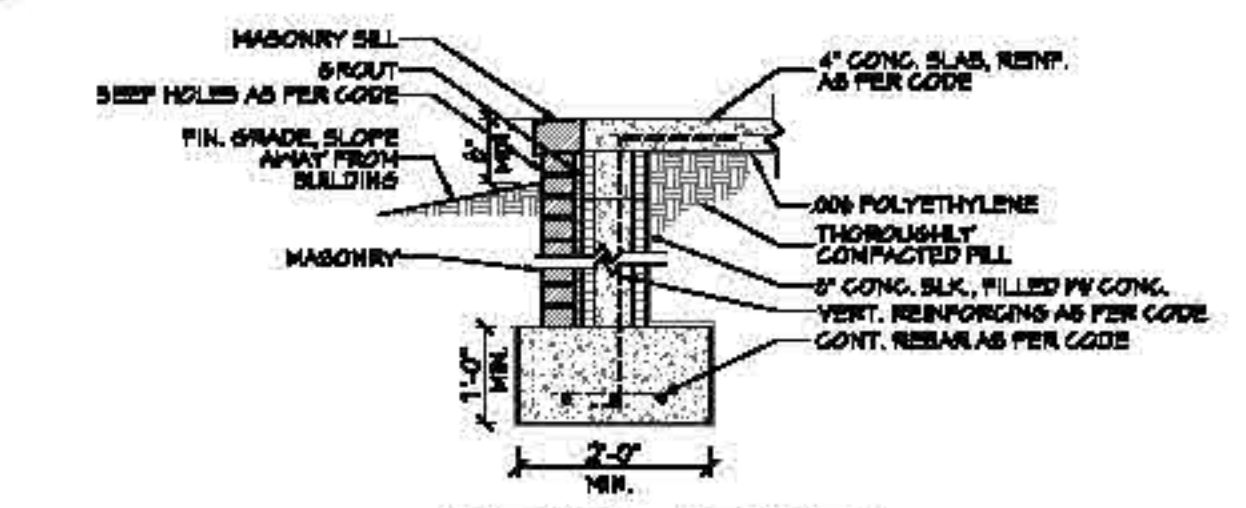

221 FTG. DET.

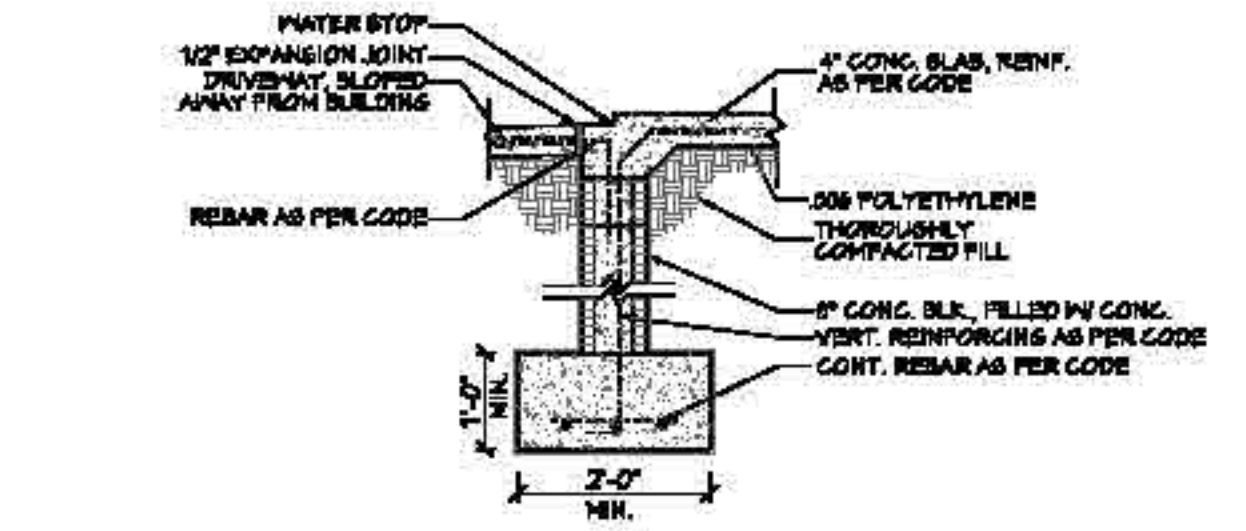

223 FTG. DET.

- SLAB FOUNDATION NOTES:**
1. ALL FOOTING SIZES AND LOCATIONS TO BE VERIFIED BY A LICENSED STRUCTURAL ENGINEER.
 2. CONTRACTOR TO ADAPT PLANS AS REQUIRED TO MEET ALL APPLICABLE CODES AT SITE.
 3. CONTRACTOR SHALL VERIFY ALL DIMENSIONS WITH FLOOR PLAN PRIOR TO CONSTRUCTION AND MAKE ANY NECESSARY ADJUSTMENTS.
 4. CONTRACTOR TO PROVIDE WATERPROOFING AS REQ'D TO MEET ALL APPLICABLE CODES AND TYPICAL BUILDING PRACTICES.
 5. CONCRETE SLABS TO BE 4" (3000 psi MIN.), REINFORCED AS PER CODE OR AS DETERMINED BY LICENSED ENGINEER.
 6. ALL EXTERIOR DIMENSIONS ARE TO THE OUTSIDE OF THE STUDWALL AND DO NOT INCLUDE THE BRICK LEDGE (IF APPLICABLE)

Date: 04.22.20


Drawn By: _____

© COPYRIGHT
ALL RIGHTS RESERVED

SHEET NUMBER

2



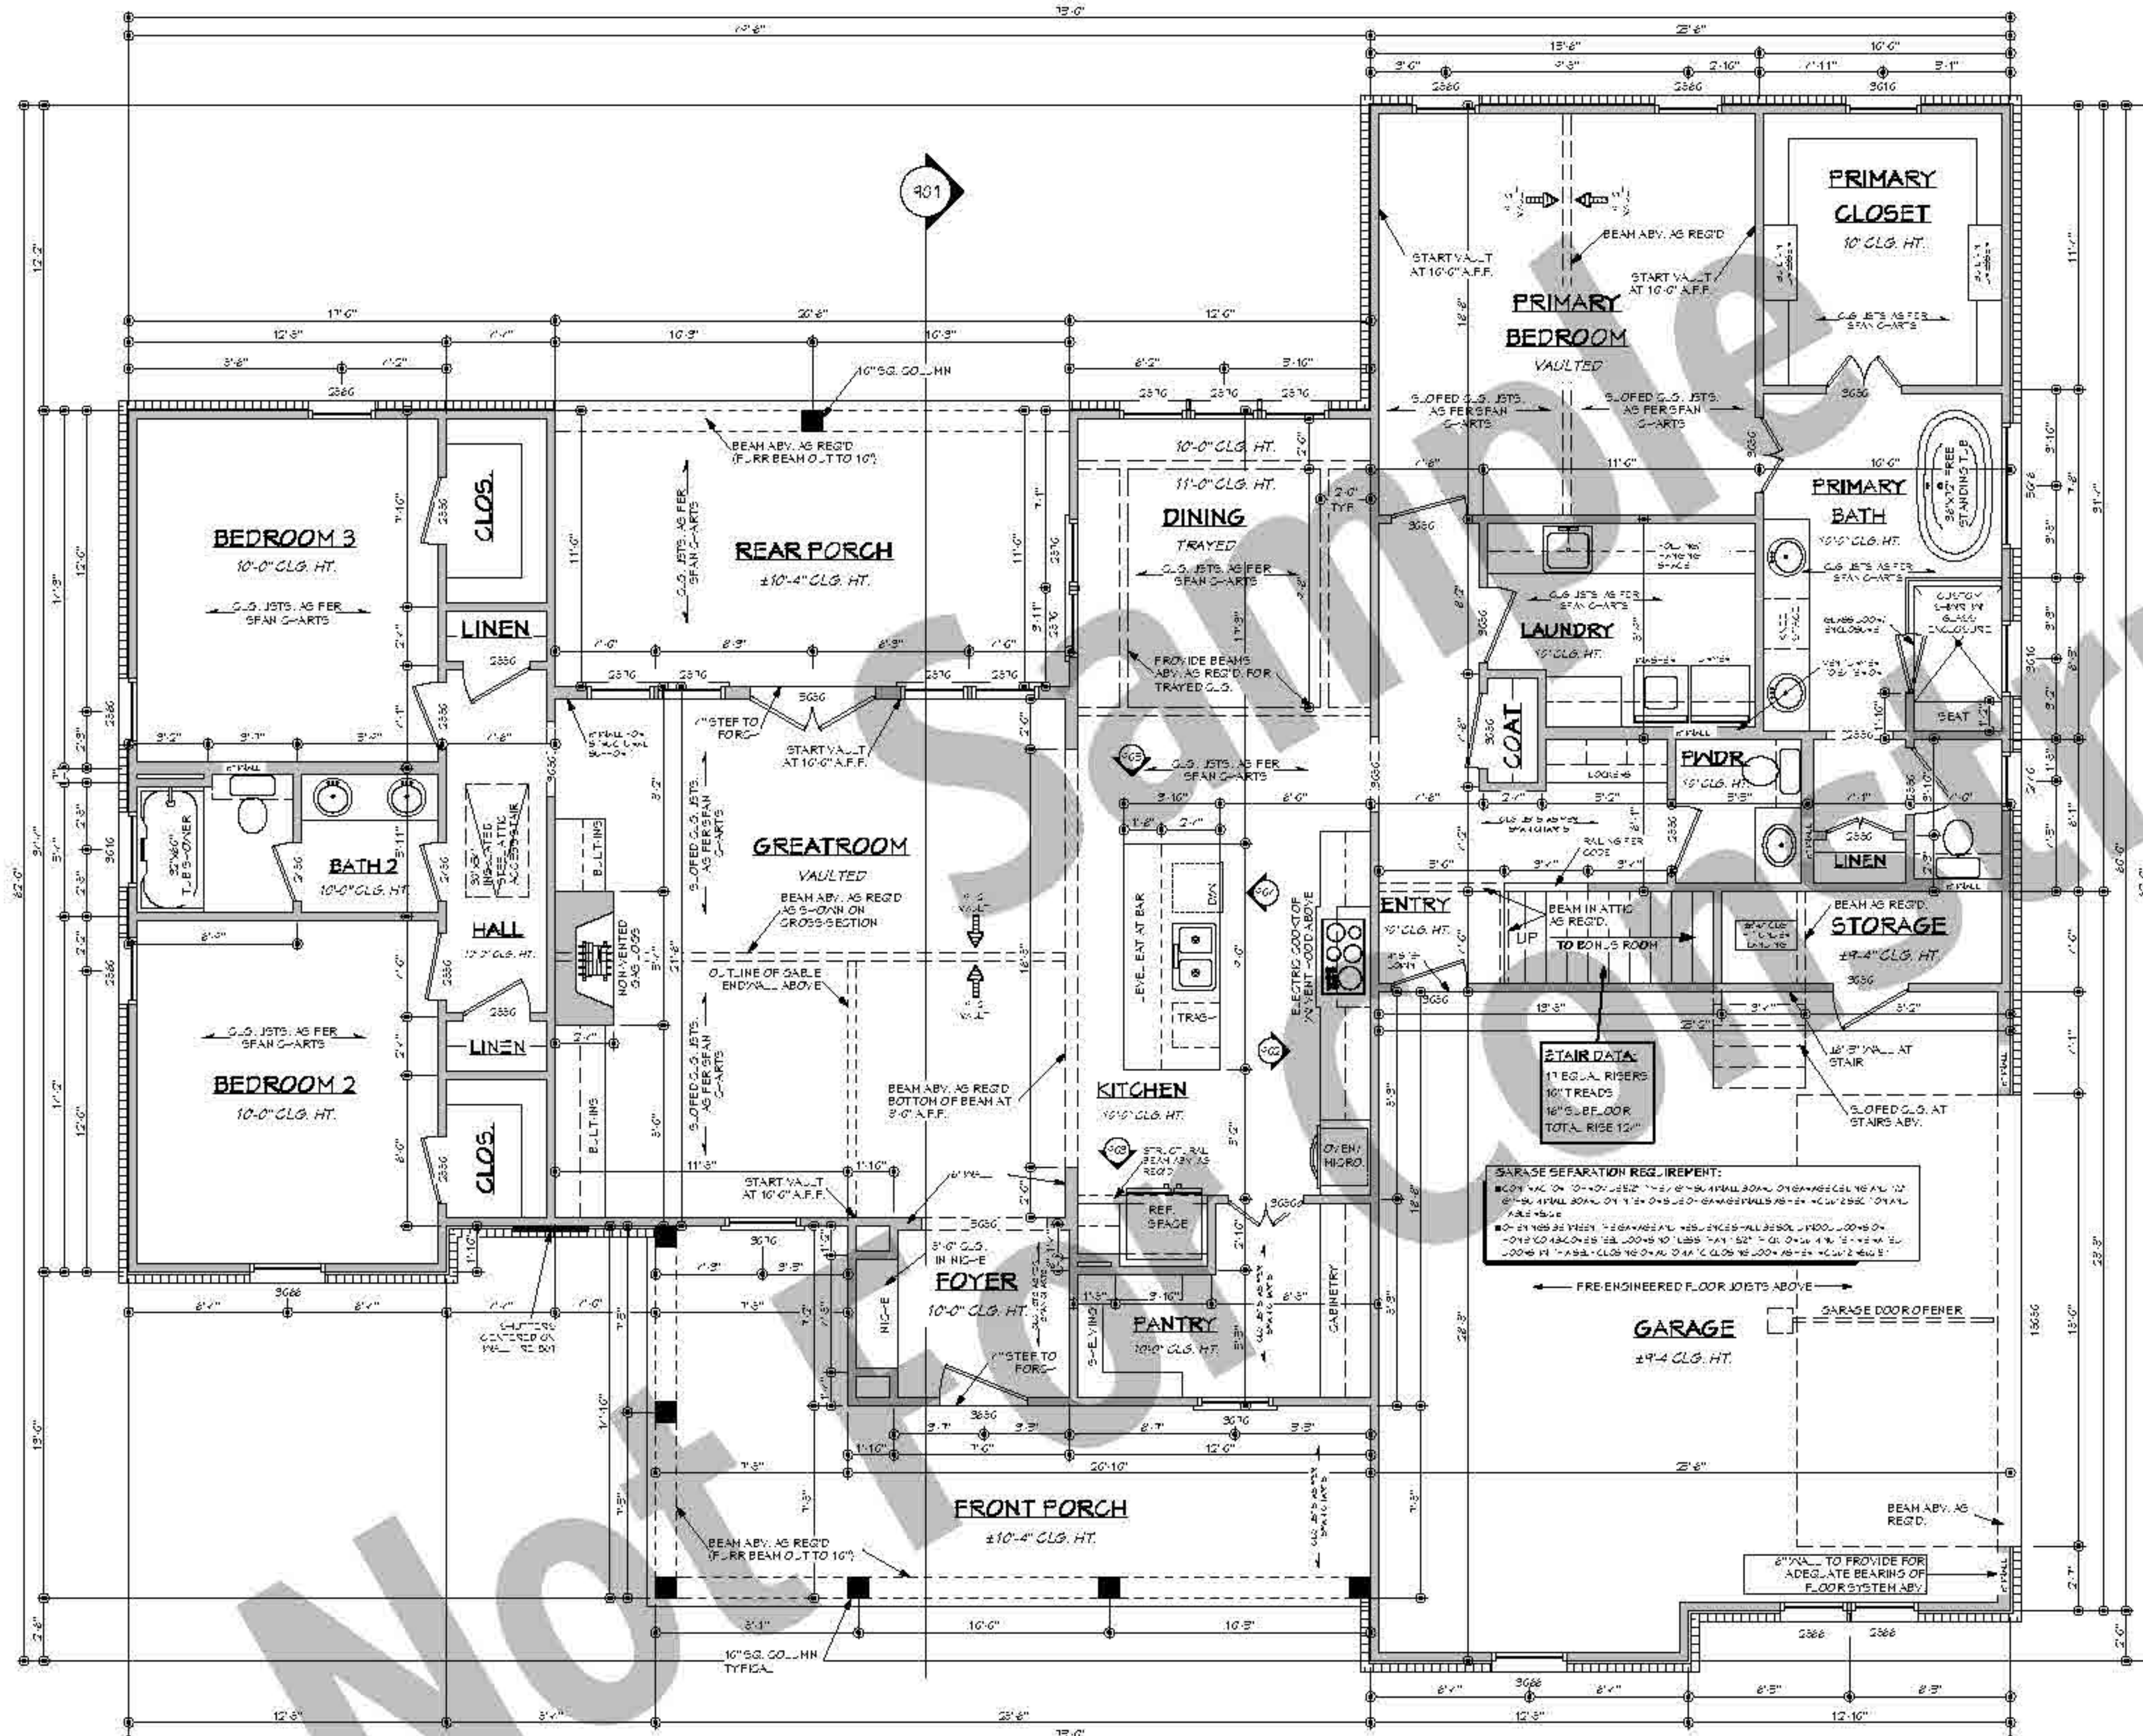

FLOOR PLAN NOTES: (2018 IRC)

1. ALL DIMENSIONS & SITE CONDITIONS TO BE VERIFIED BY CONTRACTOR PRIOR TO CONSTRUCTION.
2. ALL EXTERIOR DIMENSIONS ARE TO THE OUTSIDE FACE OF THE STUD AND DO NOT INCLUDE EXTERIOR FINISHES SUCH AS SIDING, BRICK, STUCCO, ETC.
3. ALL FINISHES (INTERIOR & EXTERIOR) TO BE VERIFIED WITH OWNER PRIOR TO CONSTRUCTION.
4. VERIFY ALL DOOR AND WINDOW STYLES AND SIZES WITH OWNER PRIOR TO CONSTRUCTION. MANUFACTURER TO SUPPLY ALL ROUGH OPENING SIZES.
5. CONTRACTOR TO VERIFY ALL CLEARANCES OF ALL DOORS, WINDOWS AND OTHER ITEMS THAT ARE CRITICAL, PRIOR TO CONSTRUCTION.
6. CONTRACTOR TO ADAPT PLANS AS REQUIRED TO MEET ALL APPLICABLE CODES AT SITE.
7. ALL BEAMS TO BE SIZED BY A LICENSED STRUCTURAL ENGINEER.
8. PORCHES, BALCONIES OR RAISED FLOOR SURFACES LOCATED MORE THAN 30 INCHES ABOVE THE FLOOR OR GRADE BELOW AT ANY POINT WITHIN 36 INCHES HORIZONTALLY SHALL HAVE GUARDS NOT LESS THAN 36 INCHES IN HEIGHT. OPEN SIDES OF STAIRS WITH A TOTAL RISE OF MORE THAN 30 INCHES ABOVE THE FLOOR OR GRADE BELOW SHALL HAVE GUARDS NOT LESS THAN 34 INCHES IN HEIGHT MEASURED VERTICALLY FROM THE NOES OF THE TREADS. INSECT SCREENINGS SHALL NOT BE CONSIDERED AS A GUARD. IRC 2018, R312.1.1 & R312.1.2
9. M1305.1.2 AFFLIANCES IN ATTICS. ATTICS CONTAINING AFFLIANCES SHALL BE PROVIDED WITH AN OPENING AND A CLEAR UNOBSTRUCTED PASSAGEWAY LARGE ENOUGH TO ALLOW REMOVAL OF THE LARGEST AFFLIANCE, BUT NOT LESS THAN 30 INCHES HIGH AND 22 INCHES WIDE AND NOT MORE THAN 30 FEET LONG MEASURED ALONG THE CENTERLINE OF THE PASSAGEWAY FROM THE OPENING TO THE AFFLIANCE. THE PASSAGEWAY SHALL HAVE CONTINUOUS SOLID FLOORING IN ACCORDANCE WITH CHAPTER 5 NOT LESS THAN 24 INCHES WIDE. A LEVEL SERVICE SPACE AT LEAST 30 INCHES DEEP AND 30 INCHES WIDE SHALL BE PRESENT ALONG ALL SIDES OF THE AFFLIANCE WHERE ACCESS IS REQUIRED. THE CLEAR ACCESS OPENING DIMENSIONS SHALL BE A MINIMUM OF 30 INCHES BY 30 INCHES, AND LARGE ENOUGH TO ALLOW REMOVAL OF THE LARGEST AFFLIANCE. EXCEPTIONS: (A) THE PASSAGEWAY AND LEVEL SERVICE SPACE ARE NOT REQUIRED WHERE THE AFFLIANCE CAN BE SERVICED AND REMOVED THROUGH THE REQUIRED OPENING. (B) WHERE THE PASSAGEWAY IS UNOBSTRUCTED AND NOT LESS THAN 6 FEET HIGH AND 22 INCHES WIDE FOR ITS ENTIRE LENGTH, THE PASSAGEWAY SHALL BE NOT MORE THAN 50 FEET LONG.
10. AFFLIANCE ACCESS FOR INSPECTION, SERVICE, REPAIR AND REPLACEMENT. AFFLIANCES SHALL BE ACCESSIBLE FOR INSPECTION, SERVICE, REPAIR AND REPLACEMENT WITHOUT REMOVING PERMANENT CONSTRUCTION, OTHER AFFLIANCES, OR ANY OTHER FINISHES OR DUCTS NOT CONNECTED TO THE AFFLIANCE BEING INSPECTED, SERVICED, REPAIRED OR REPLACED. A LEVEL WORKING SPACE AT LEAST 30 INCHES DEEP AND 30 INCHES WIDE SHALL BE PROVIDED IN FRONT OF THE CONTROL SIDE TO SERVICE AN AFFLIANCE. M1305.1.1
11. EMERGENCY ESCAPE AND RESCUE OPENINGS SHALL BE OPERATIONAL FROM THE INSIDE OF THE ROOM WITHOUT THE USE OF KEYS, TOOLS OR SPECIAL KNOWLEDGE. WINDOW OPENING CONTROL DEVICES COMPLYING WITH ASTM F 2090 SHALL BE PERMITTED FOR USE ON WINDOWS SERVING AS A REQUIRED EMERGENCY ESCAPE AND RESCUE OPENING. ALL SLEEPING ROOMS TO HAVE AN EXTERIOR ACCESS THROUGH A DOOR OR WINDOW WITH A MINIMUM OF 5.7 SQUARE FEET NET CLEAR OPENING AS PER IRC 2018 R310.2.1. EXCEPTION: GRADE FLOOR OR BELOW. GRADE OPENINGS SHALL HAVE A MINIMUM NET CLEAR OPENING OF 5 SQUARE FEET. MAXIMUM BELL HEIGHT TO BE 44 INCHES. MINIMUM NET CLEAR OPENING HEIGHT TO BE 24 INCHES. MINIMUM NET CLEAR OPENING WIDTH TO BE 30 INCHES.
12. ALL RETURN AIR GRILLS ARE TO BE LOCATED TO COMPLY WITH SECTION M1602 OF THE IRC 2018.
13. ALL SQUARE FOOTAGE MEASUREMENTS ARE APPROXIMATE AND MAY DIFFER FROM ACTUAL CONSTRUCTED RESIDENCE OR BUILDING. FOOTAGES SHOWN ARE TO THE OUTSIDE OF THE STUDY WALL AND DO NOT INCLUDE THE EXTERIOR FINISH MATERIAL SUCH AS SIDING, BRICK, STONE ETC.
14. FIRE SINKRINKER SYSTEM TO BE DESIGNED AND INSTALLED (IF REQUIRED BY LOCAL CODES) AS PER THE IRC 2018 AND BY A LICENSED PROFESSIONAL IN THE AREA OF CONSTRUCTION.
15. ALL BATHROOM EXHAUST VENTS SHALL BE VENTED DIRECTLY TO THE EXTERIOR OF THE HOME AND NOT INTO THE ATTIC. IRC 2018, M1505.2



AREAS:	S.F. HEATED
	2431
	344 S.F. UNHEATED - BONUS ROOM
	273 S.F. UNHEATED - FRONT PORCH
	225 S.F. UNHEATED - REAR PORCH
	649 S.F. UNHEATED - GARAGE
	46 S.F. UNHEATED - STORAGE
	1537 S.F. UNHEATED - TOTAL
	3968 S.F. TOTAL UNDER ROOF
	MASONRY NOT INCLUDED

FRAMING SQUARE FOOTAGE CALCULATION NOTES:
 1. SQUARE FOOTAGE OF HEATED AREA IS FIGURED TO THE OUTSIDE OF THE STUDY WALL OF THE EXTERIOR WALLS (DOES NOT INCLUDE MASONRY OR OTHER EXTERIOR MATERIALS).
 2. FIREPLACES THAT PROTRUDE FROM THE EXTERIOR FOOTPRINT ARE NOT INCLUDED IN THE HEATED AREA.
 3. STAIRWELLS ARE ONLY INCLUDED IN THE FIRST FLOOR CALCULATIONS AND NOT THE SECOND FLOOR CALCULATIONS (IF APPLICABLE).

DOOR LABEL SIZE: 3065 IS A DOOR-AT IS 3 FT 6 INCHES WIDE BY 6 FEET 6 INCHES TALL. TO CLARIFY, THE 3065 LABEL IS TO BE READ AS FEET AND INCHES (NOT-) AND FEET AND INCHES (-IS-). THE DOOR LABEL IS THE ACTUAL SIZE OF THE DOOR ITSELF, NOT THE ROUGH OPENING SIZE. VERIFY THE ROUGH OPENING SIZE WITH THE DOOR MANUFACTURER'S OPENING SIZE AT SITE.
WINDOW LABEL SIZE: 3026 IS A WINDOW-AT IS 3 FT 6 INCHES WIDE BY 3 FEET 6 INCHES TALL. TO CLARIFY, THE 3026 LABEL IS TO BE READ AS FEET AND INCHES (NOT-) AND FEET AND INCHES (-IS-). THE WINDOW LABEL IS THE ACTUAL SIZE OF THE WINDOW ITSELF, NOT THE ROUGH OPENING SIZE. VERIFY THE ROUGH OPENING SIZE WITH THE WINDOW MANUFACTURER'S OPENING SIZE AT SITE.

FLOOR PLAN
 SCALE: 1/4" = 1'-0"

MECHANICAL NOTE:
 WATER HEATER & HVAC UNIT TO BE LOCATED IN ATTIC SPACE BY CONTRACTOR.

WALL FRAMING NOTE:
 ALL WALLS TO BE 2X4 @ 16" O.C. UNLESS OTHERWISE NOTED.


Date: 04.22.20

Drawn By: [Signature]

© COPYRIGHT ALL RIGHTS RESERVED

SHEET NUMBER

3

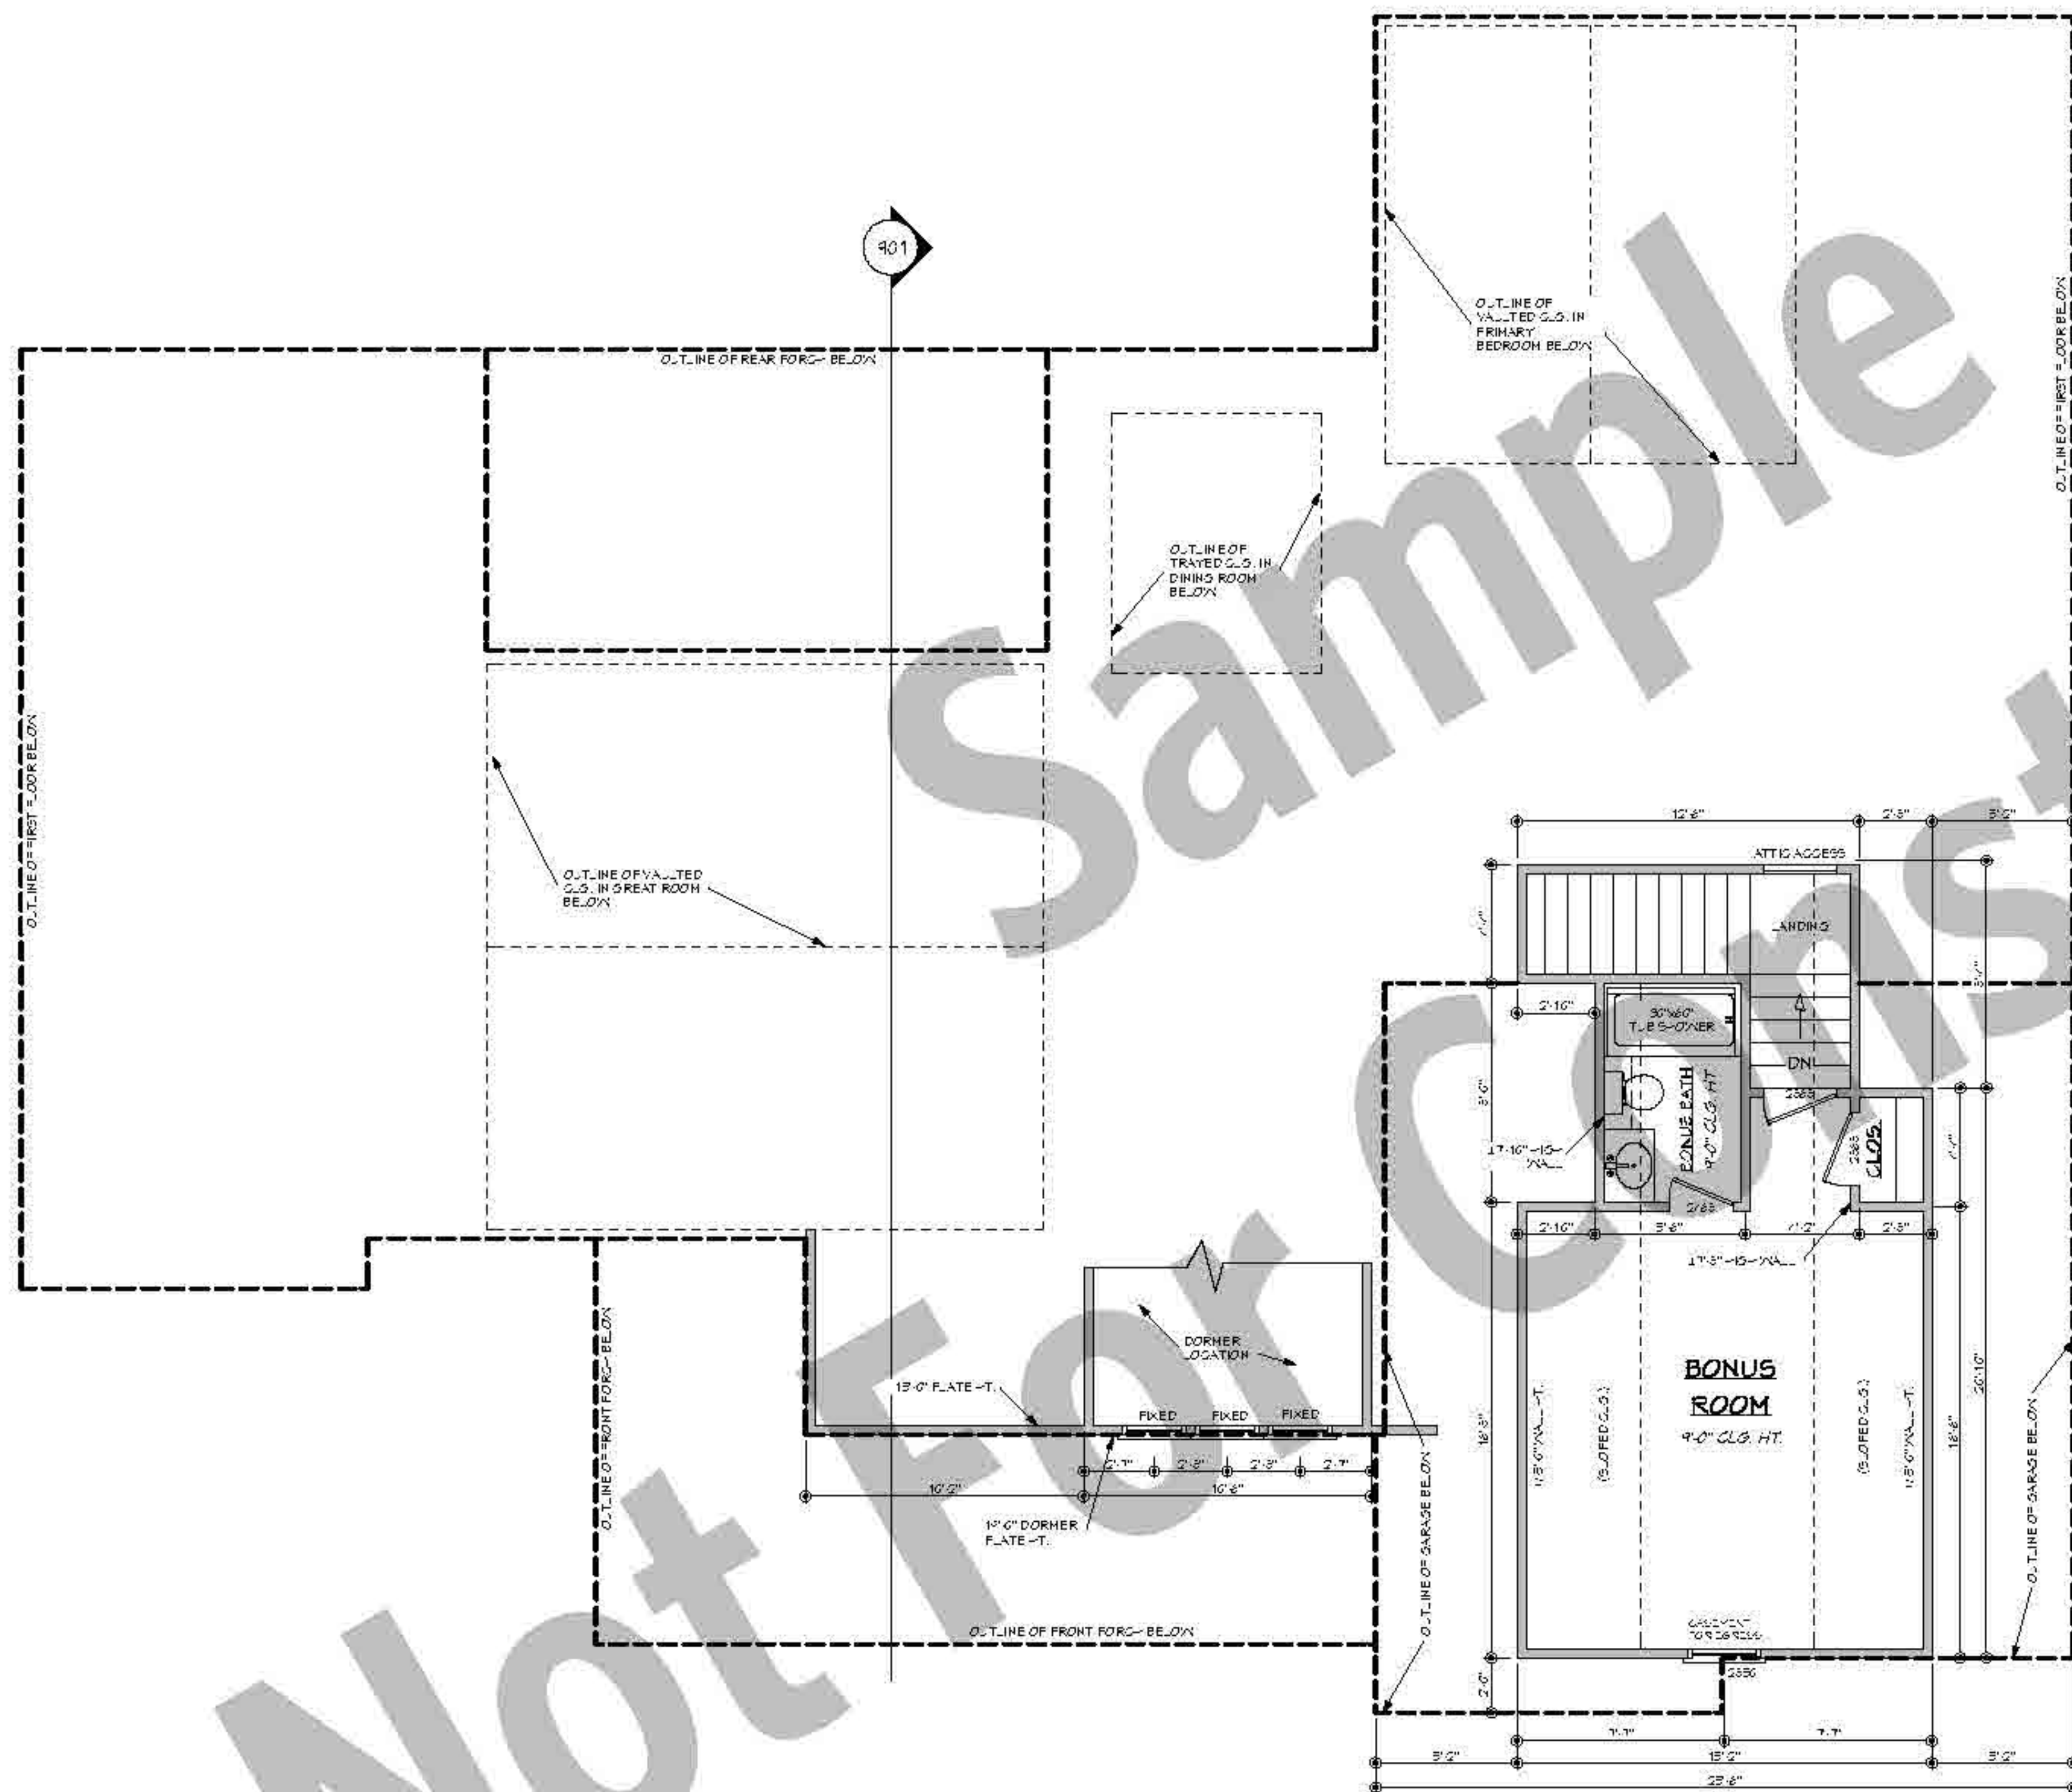

BONUS FLOOR PLAN

SCALE: 1/4" = 1'-0"

FLOOR PLAN NOTES: (2018 IRC)

1. ALL DIMENSIONS & SITE CONDITIONS TO BE VERIFIED BY CONTRACTOR PRIOR TO CONSTRUCTION.
2. ALL EXTERIOR DIMENSIONS ARE TO THE OUTSIDE FACE OF THE STUD AND DO NOT INCLUDE EXTERIOR FINISHES SUCH AS SIDING, BRICK, STUCCO, ETC.
3. ALL FINISHES (INTERIOR & EXTERIOR) TO BE VERIFIED WITH OWNER PRIOR TO CONSTRUCTION.
4. VERIFY ALL DOOR AND WINDOW STYLES AND SIZES WITH OWNER PRIOR TO CONSTRUCTION. MANUFACTURER TO SUPPLY ALL ROUGH OPENING SIZES.
5. CONTRACTOR TO VERIFY ALL CLEARANCES OF ALL DOORS, WINDOWS AND OTHER ITEMS THAT ARE CRITICAL PRIOR TO CONSTRUCTION.
6. CONTRACTOR TO ADAPT PLANS AS REQUIRED TO MEET ALL APPLICABLE CODES AT SITE.
7. ALL BEAMS TO BE SIZED BY A LICENSED STRUCTURAL ENGINEER.
8. PORCHES, BALCONIES OR RAISED FLOOR SURFACES LOCATED MORE THAN 30 INCHES ABOVE THE FLOOR OR GRADE BELOW AT ANY POINT WITHIN 36 INCHES HORIZONTALLY SHALL HAVE GUARDS NOT LESS THAN 36 INCHES IN HEIGHT. OPEN SIDES OF STAIRS WITH A TOTAL RISE OF MORE THAN 30 INCHES ABOVE THE FLOOR OR GRADE BELOW SHALL HAVE GUARDS NOT LESS THAN 34 INCHES IN HEIGHT MEASURED VERTICALLY FROM THE NOSING OF THE TREADS. INSECT SCREENING SHALL NOT BE CONSIDERED AS A GUARD. IRC 2018, R312.1.1 & R312.1.2
9. M1303.1.2 AFFLIANCES IN ATTIC. ATTIC CONTAINING AFFLIANCES SHALL BE PROVIDED WITH AN OPENING AND A CLEAR AND UNOBSTRUCTED PASSAGEWAY LARGE ENOUGH TO ALLOW REMOVAL OF THE LARGEST AFFLIANCE, BUT NOT LESS THAN 30 INCHES HIGH AND 22 INCHES WIDE AND NOT MORE THAN 20 FEET LONG MEASURED ALONG THE CENTERLINE OF THE PASSAGEWAY FROM THE OPENING TO THE AFFLIANCE. THE PASSAGEWAY SHALL HAVE CONTINUOUS SOLID FLOORING IN ACCORDANCE WITH CHAPTER 5 NOT LESS THAN 24 INCHES WIDE. A LEVEL SERVICE SPACE AT LEAST 30 INCHES DEEP AND 30 INCHES WIDE SHALL BE PRESENT ALONG ALL SIDES OF THE AFFLIANCE WHERE ACCESS IS REQUIRED. THE CLEAR ACCESS OPENING DIMENSIONS SHALL BE A MINIMUM OF 20 INCHES BY 30 INCHES, AND LARGE ENOUGH TO ALLOW REMOVAL OF THE LARGEST AFFLIANCE. EXCEPTIONS: (A) THE PASSAGEWAY AND LEVEL SERVICE SPACE ARE NOT REQUIRED WHERE THE AFFLIANCE CAN BE SERVICED AND REMOVED THROUGH THE REQUIRED OPENING. (B) WHERE THE PASSAGEWAY IS UNOBSTRUCTED AND NOT LESS THAN 6 FEET HIGH AND 22 INCHES WIDE FOR ITS ENTIRE LENGTH, THE PASSAGEWAY SHALL BE NOT MORE THAN 30 FEET LONG.
10. AFFLIANCE ACCESS FOR INSPECTION, SERVICE, REPAIR AND REPLACEMENT. AFFLIANCES SHALL BE ACCESSIBLE FOR INSPECTION, SERVICE, REPAIR AND REPLACEMENT WITHOUT REMOVING PERMANENT CONSTRUCTION, OTHER AFFLIANCES, OR ANY OTHER FINISH OR DUCTS NOT CONNECTED TO THE AFFLIANCE BEING INSPECTED, SERVICED, REPAIRED OR REPLACED. A LEVEL WORKING SPACE AT LEAST 30 INCHES DEEP AND 30 INCHES WIDE SHALL BE PROVIDED IN FRONT OF THE CONTROL SIDE TO SERVICE AN AFFLIANCE. M1303.1.1
11. EMERGENCY ESCAPE AND RESCUE OPENINGS SHALL BE OPERATIONAL FROM THE INSIDE OF THE ROOM WITHOUT THE USE OF KEYS, TOOLS OR SPECIAL KNOWLEDGE. WINDOW OPENING CONTROL DEVICES COMPLYING WITH ASTM F 2090 SHALL BE PERMITTED FOR USE ON WINDOWS SERVING AS A REQUIRED EMERGENCY ESCAPE AND RESCUE OPENING. ALL SLEEPING ROOMS TO HAVE AN EXTERIOR ACCESS THROUGH A DOOR OR WINDOW WITH A MINIMUM OF 5.7 SQUARE FEET NET CLEAR OPENING AS PER IRC 2018 R3102.1. EXCEPTION: GRADE FLOOR OR BELOW GRADE OPENINGS SHALL HAVE A MINIMUM NET CLEAR OPENING OF 5 SQUARE FEET. MAXIMUM SILL HEIGHT TO BE 44 INCHES. MINIMUM NET CLEAR OPENING HEIGHT TO BE 24 INCHES. MINIMUM NET CLEAR OPENING WIDTH TO BE 20 INCHES.
12. ALL RETURN AIR GRILLS ARE TO BE LOCATED TO COMPLY WITH SECTION M1602 OF THE IRC 2018.
13. ALL SQUARE FOOTAGE MEASUREMENTS ARE APPROXIMATE AND MAY DIFFER FROM ACTUAL CONSTRUCTED RESIDENCE OR BUILDING. FOOTAGES SHOWN ARE TO THE OUTSIDE OF THE STUD WALL AND DO NOT INCLUDE THE EXTERIOR FINISH MATERIAL SUCH AS SIDING, BRICK, STONE ETC.
14. FIRE SFRINKLER SYSTEM TO BE DESIGNED AND INSTALLED (IF REQUIRED BY LOCAL CODES) AS PER THE IRC 2018 AND BY A LICENSED PROFESSIONAL IN THE AREA OF CONSTRUCTION.
15. ALL BATHROOM EXHAUST VENTS SHALL BE VENTED DIRECTLY TO THE EXTERIOR OF THE HOME AND NOT INTO THE ATTIC. IRC 2018, M1503.2




Date: 04.22.20

Drawn By: [Signature]



© COPYRIGHT ALL RIGHTS RESERVED

SHEET NUMBER


4

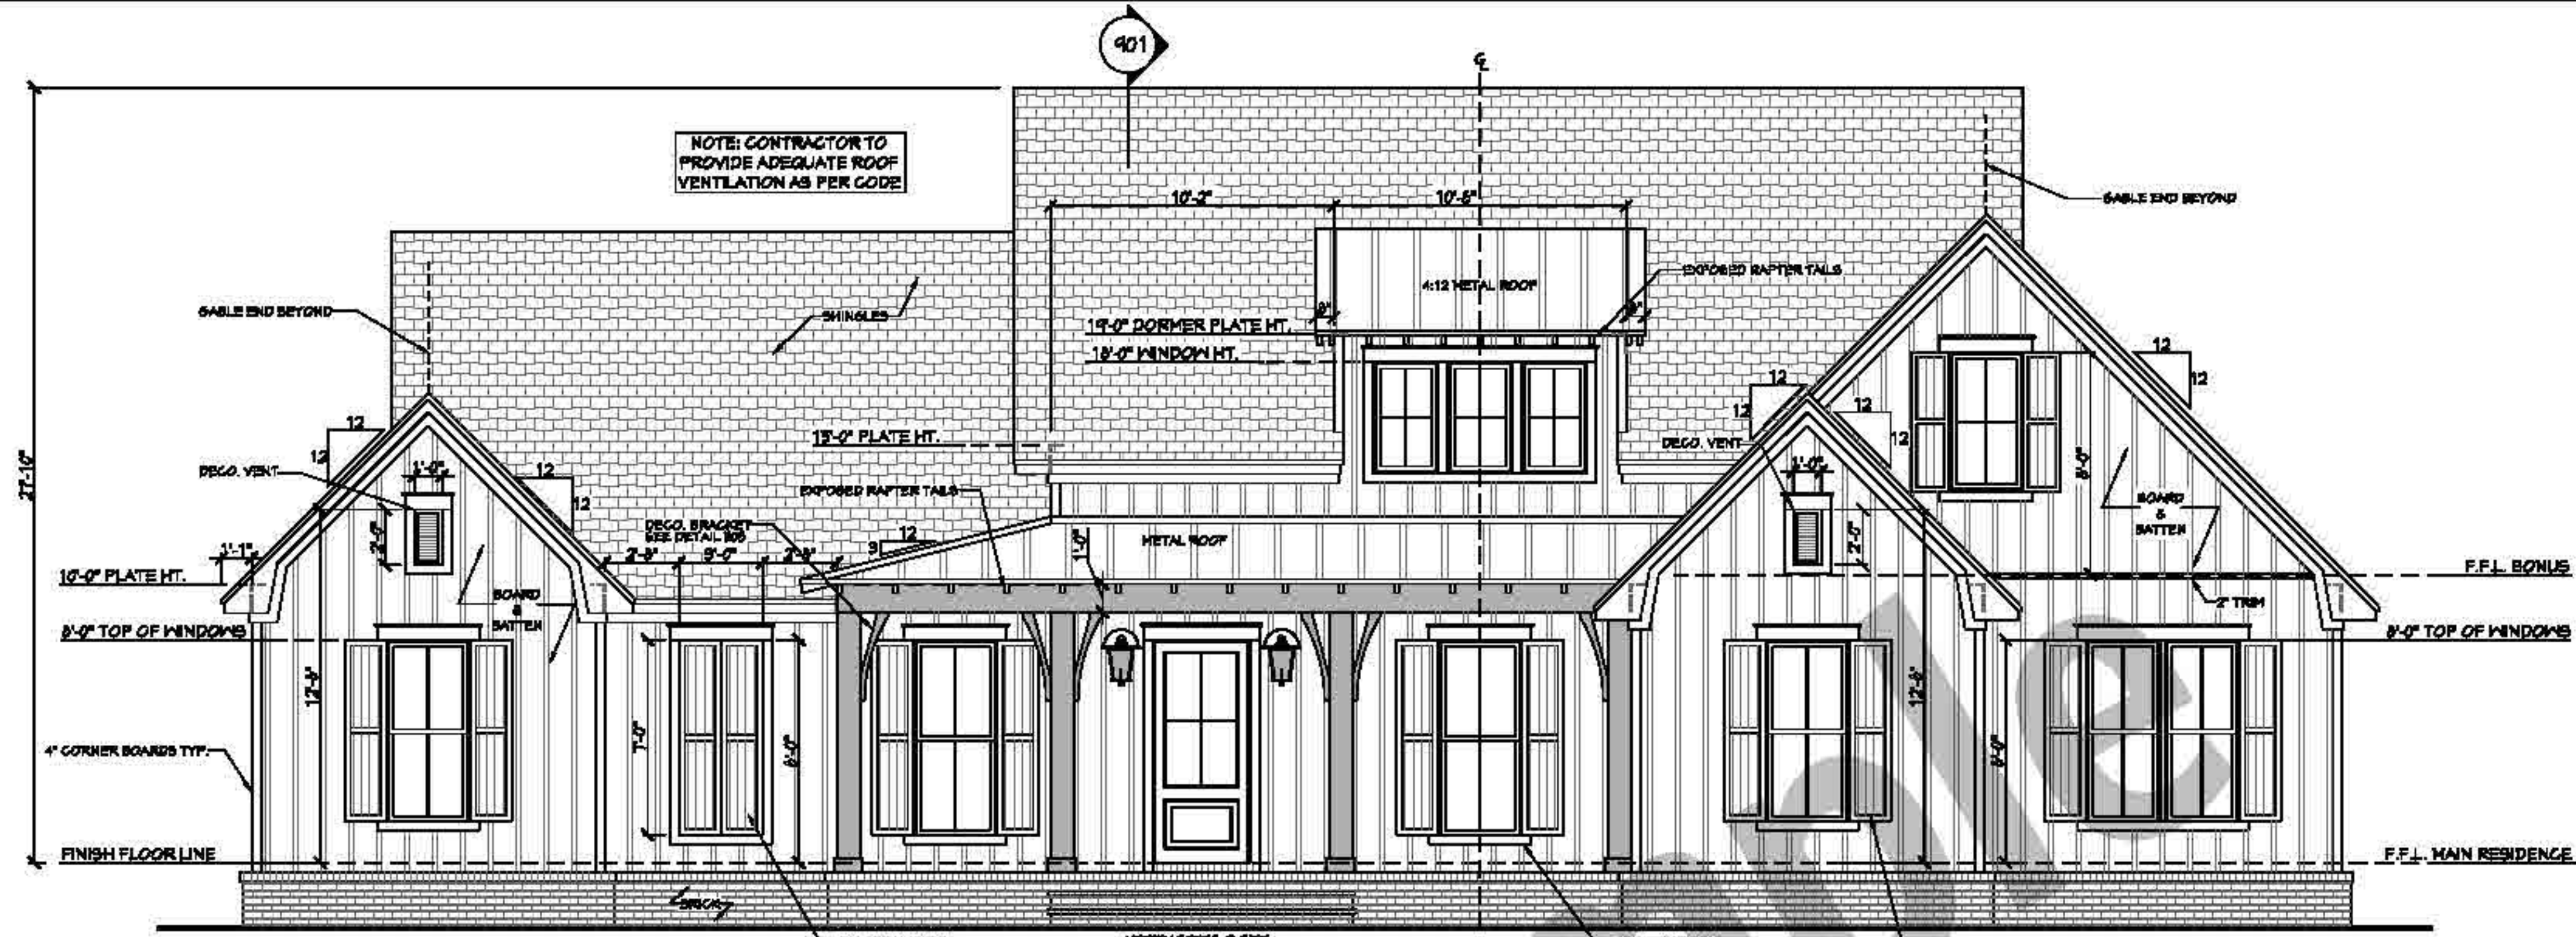


501 FRONT VIEW
SCALE 1/4" = 1'-0"

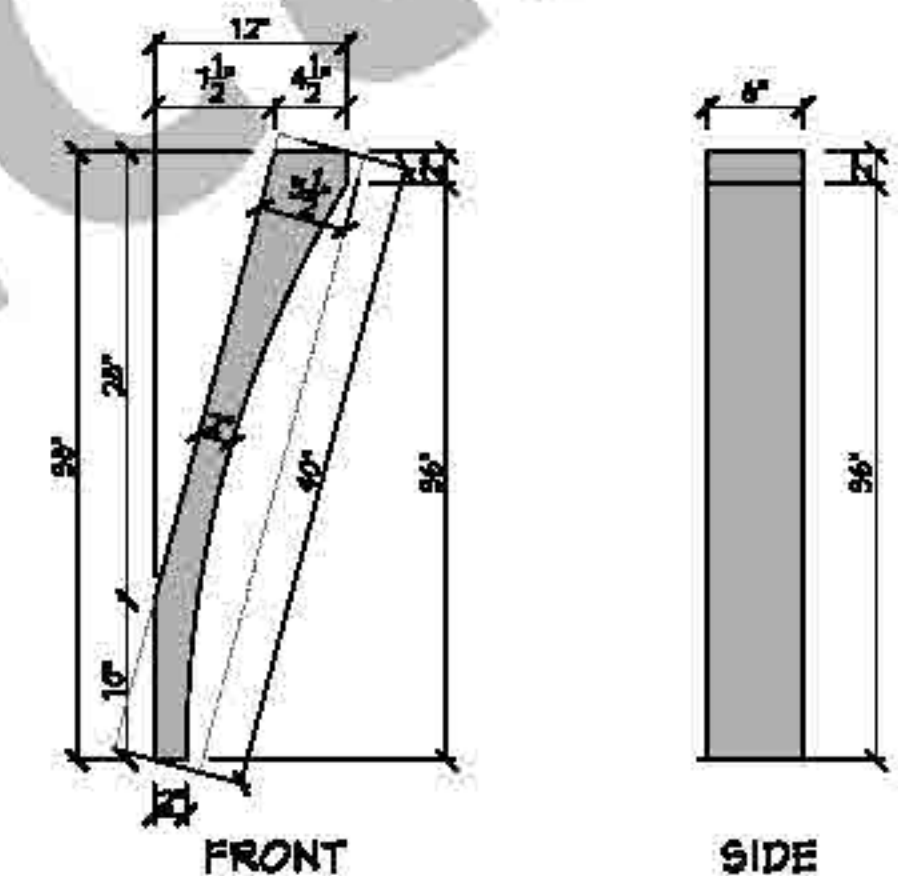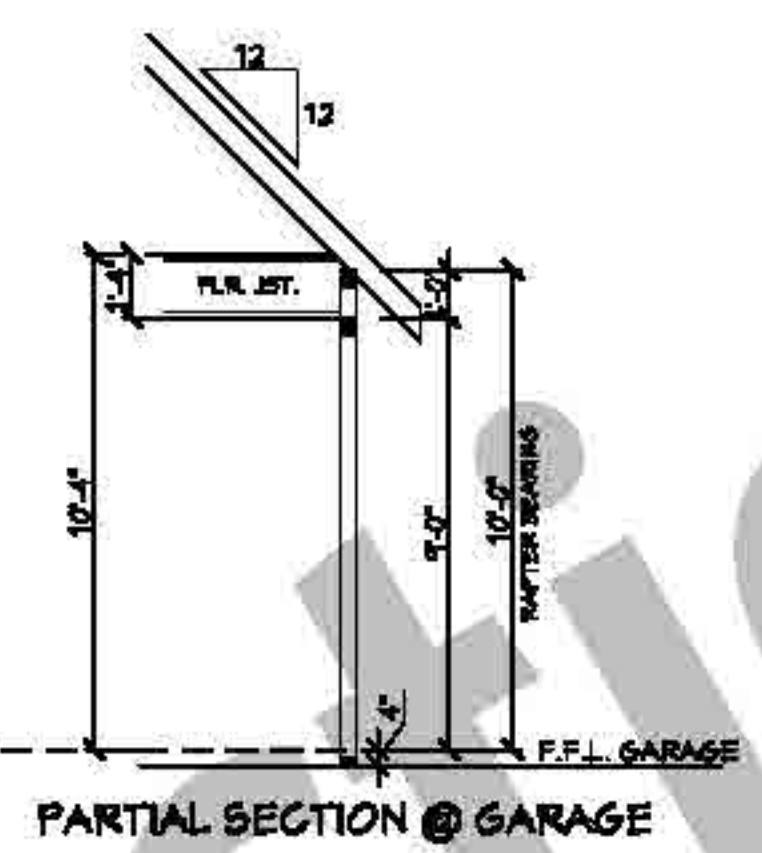

503 WD. BRACKET DTL.
SCALE N.T.S.

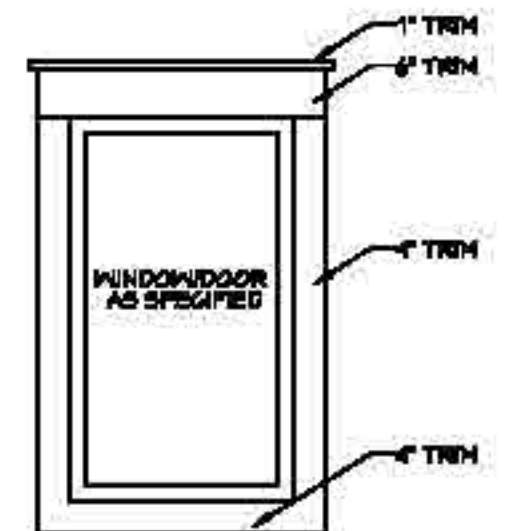

504 TYPICAL TRIM DETAIL
SCALE 1/2" = 1'-0"

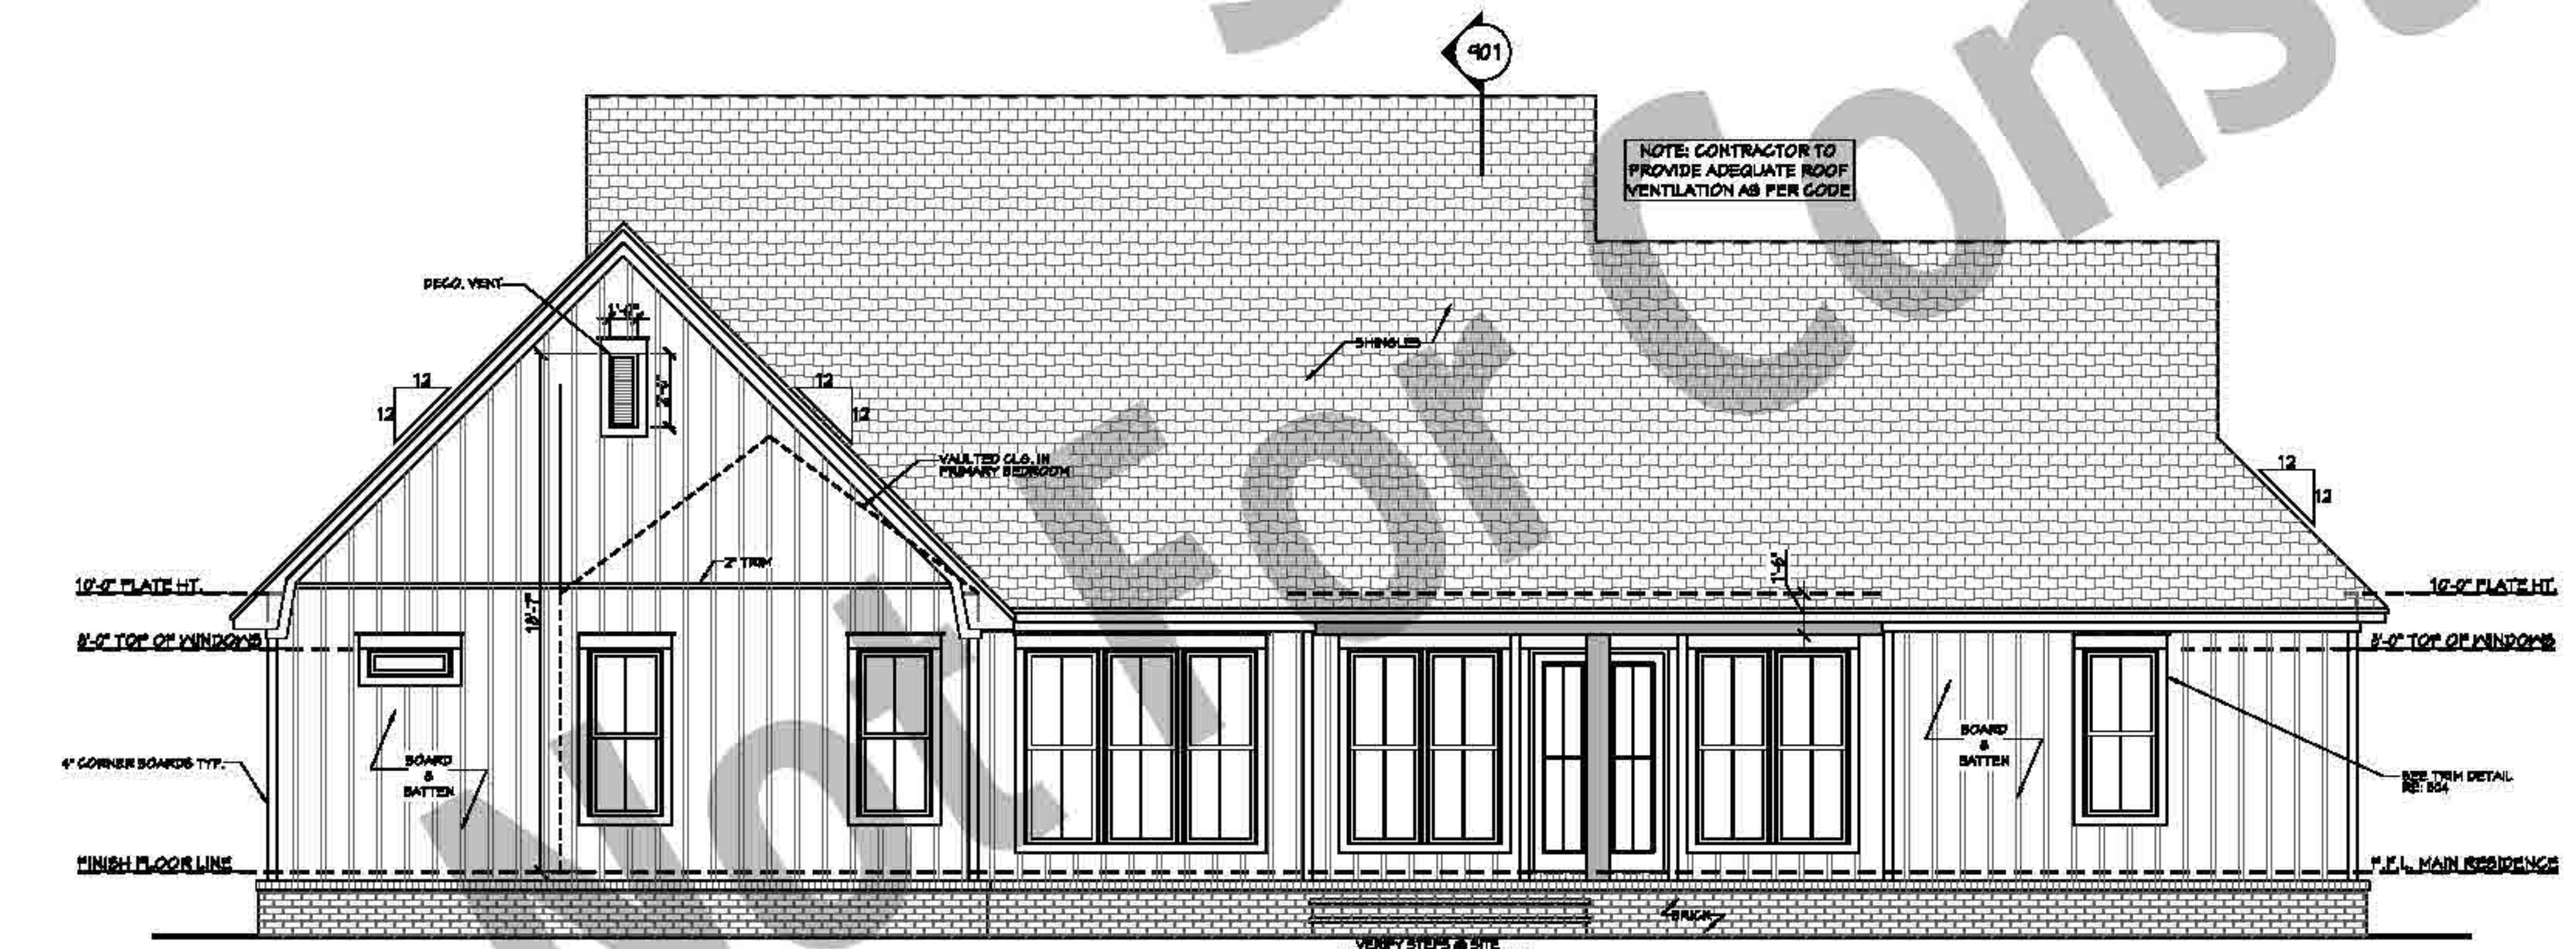

502 REAR VIEW
SCALE 1/4" = 1'-0"

- EXTERIOR ELEVATION NOTES:**
1. CONTRACTOR TO VERIFY ALL WINDOW AND DOOR STYLES AND SIZES WITH OWNER PRIOR TO CONSTRUCTION.
 2. PROVIDE STEPS AND GUARD RAILS AS PER CODE BASED ON SITE CONDITIONS.
 3. GROUND LINES SHOWN FOR REFERENCE ONLY AND VARY DEPENDING ON SITE CONDITIONS.
 4. ALL FINISH MATERIALS TO BE VERIFIED WITH OWNER PRIOR TO CONSTRUCTION.
 5. REFER TO TYPICAL WALL DETAIL FOR FRAMING METHODS AND OTHER MISC. INFORMATION.
 6. CONTRACTOR TO PROVIDE ADEQUATE ROOF VENTILATION AS REQ'D BY CURRENT CODES.




Date: 04.22.20

Drawn By: [Redacted]


© COPYRIGHT ALL RIGHTS RESERVED

SHEET NUMBER


5

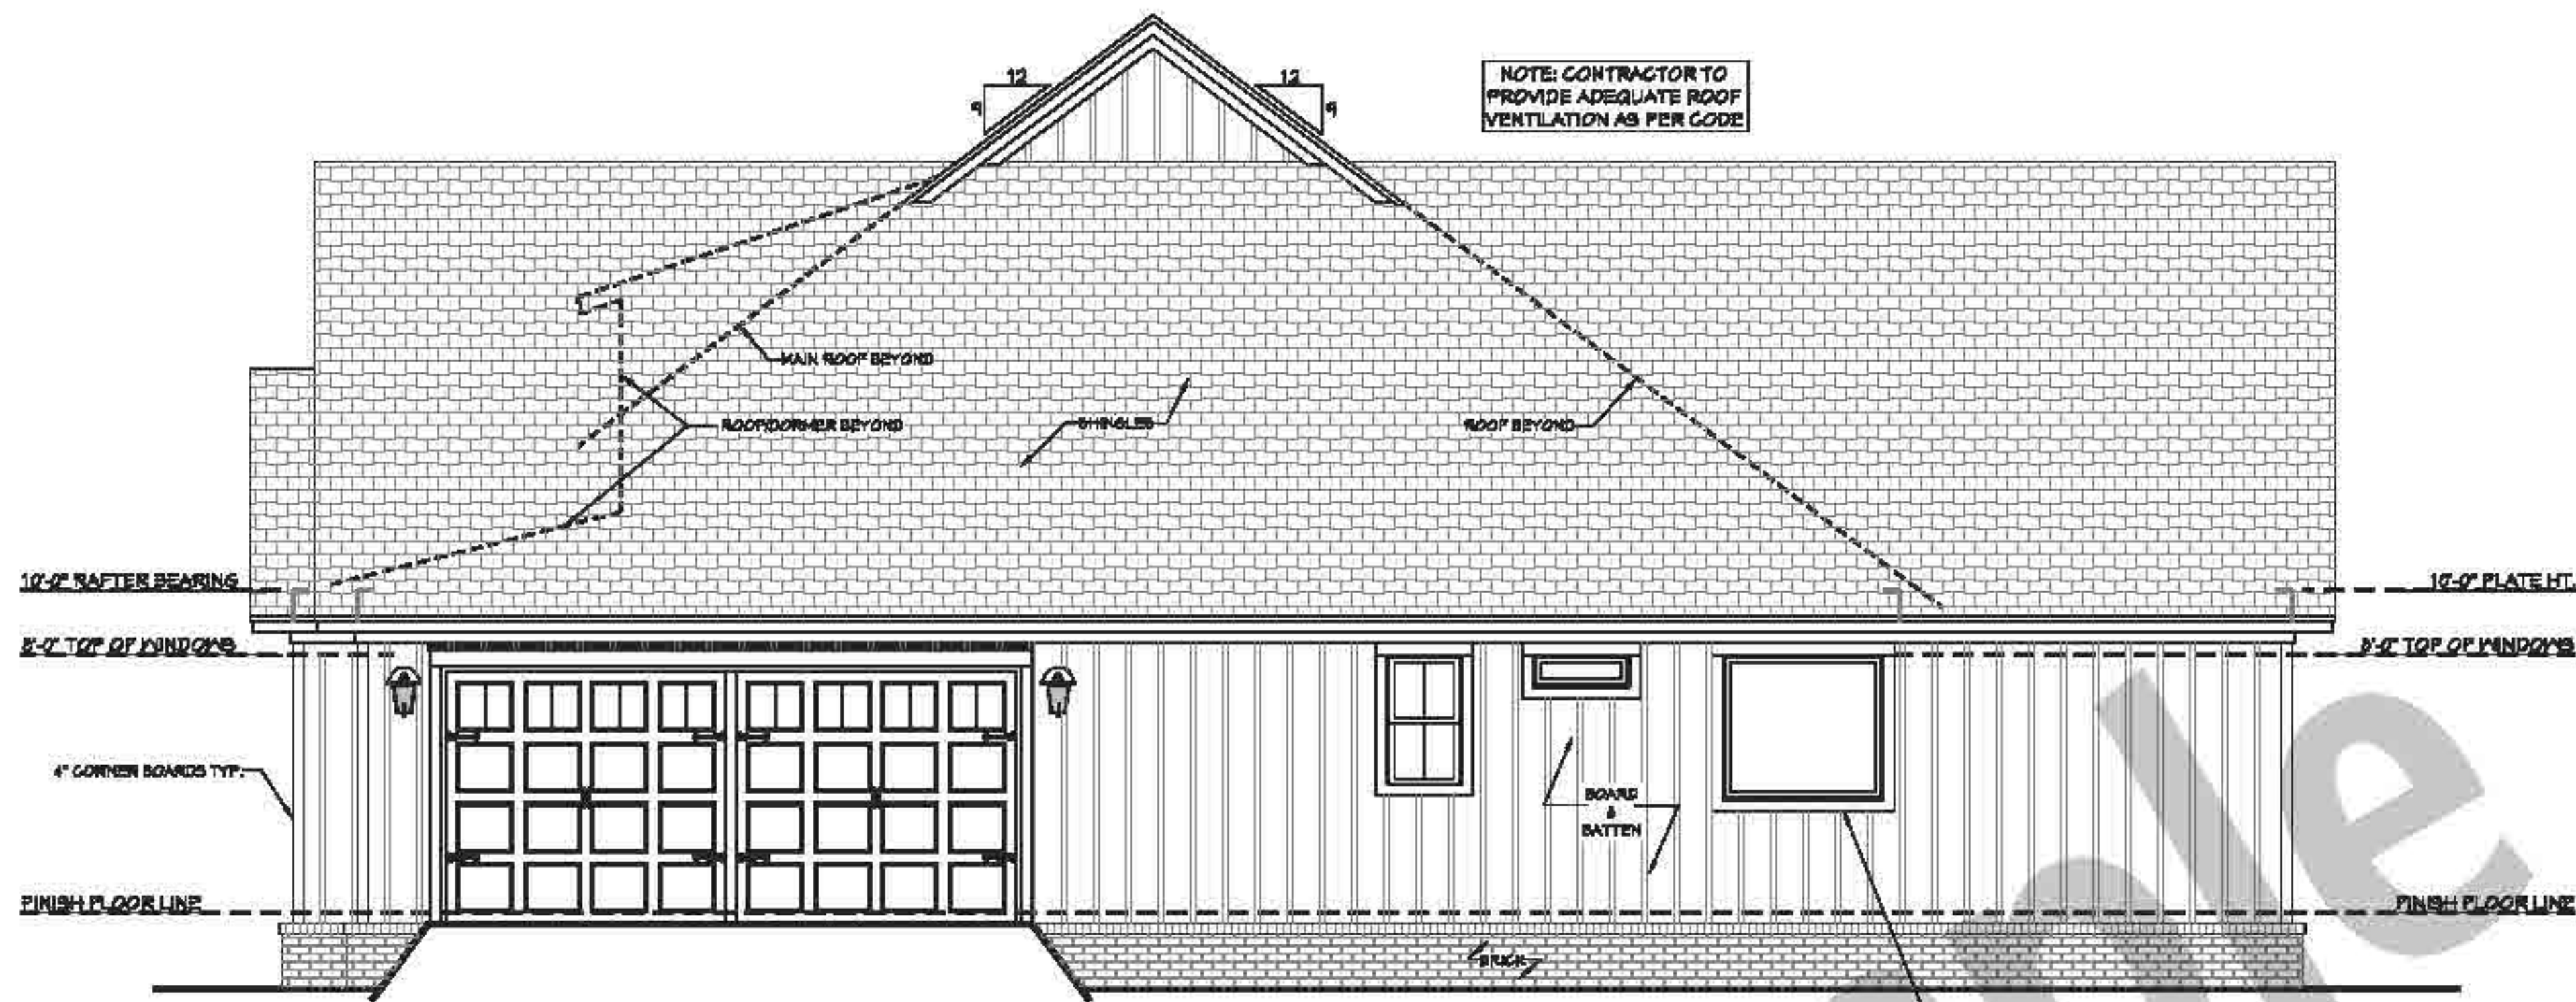


601 RIGHT VIEW
SCALE 1/4" = 1'-0"

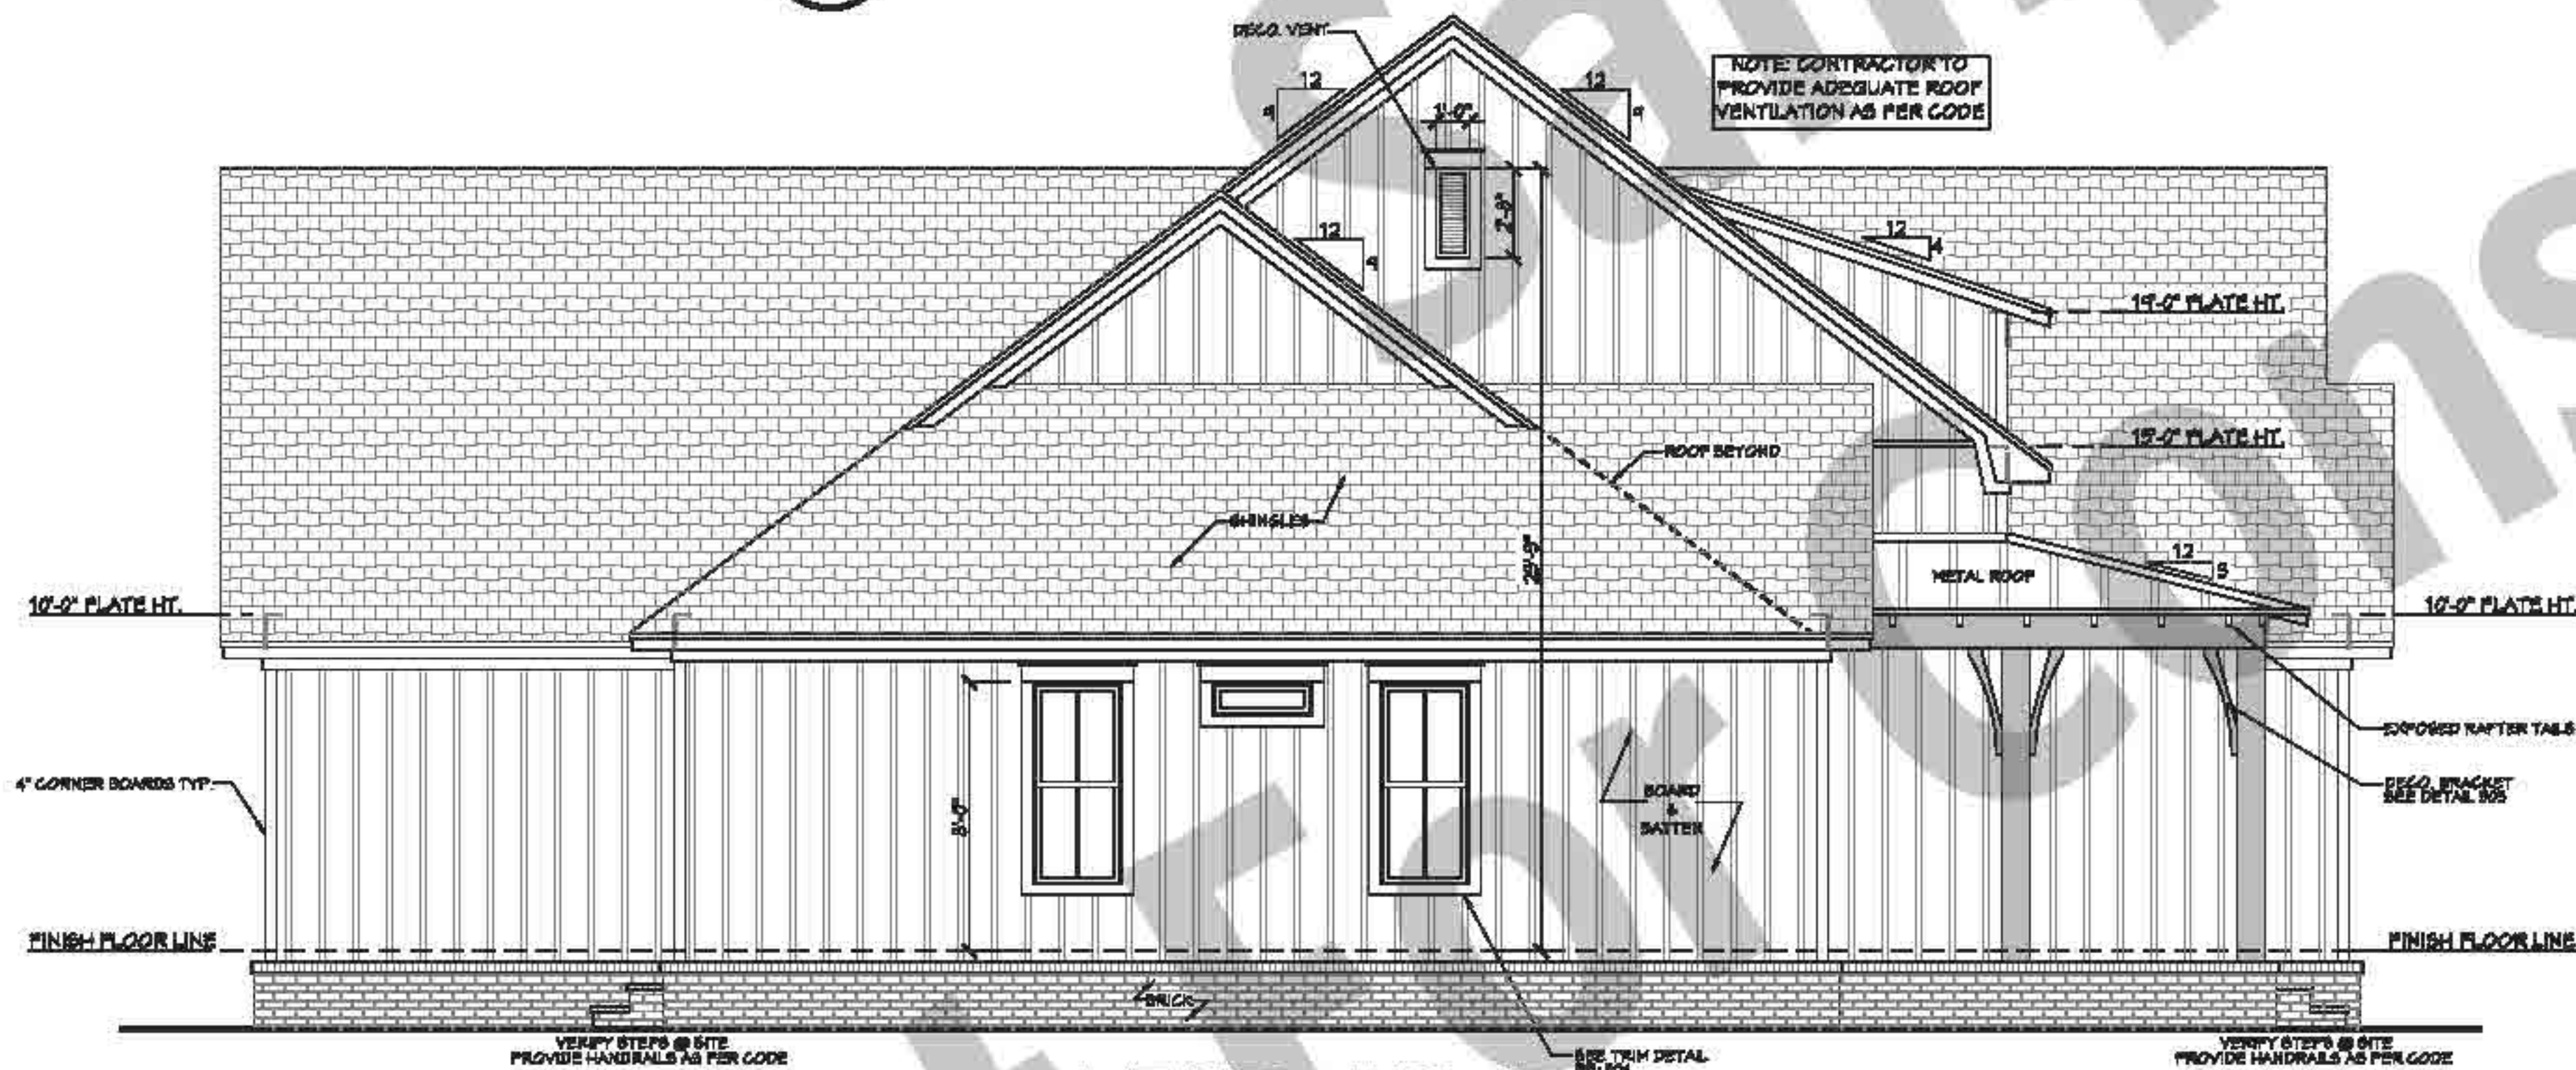


602 LEFT VIEW
SCALE 1/4" = 1'-0"

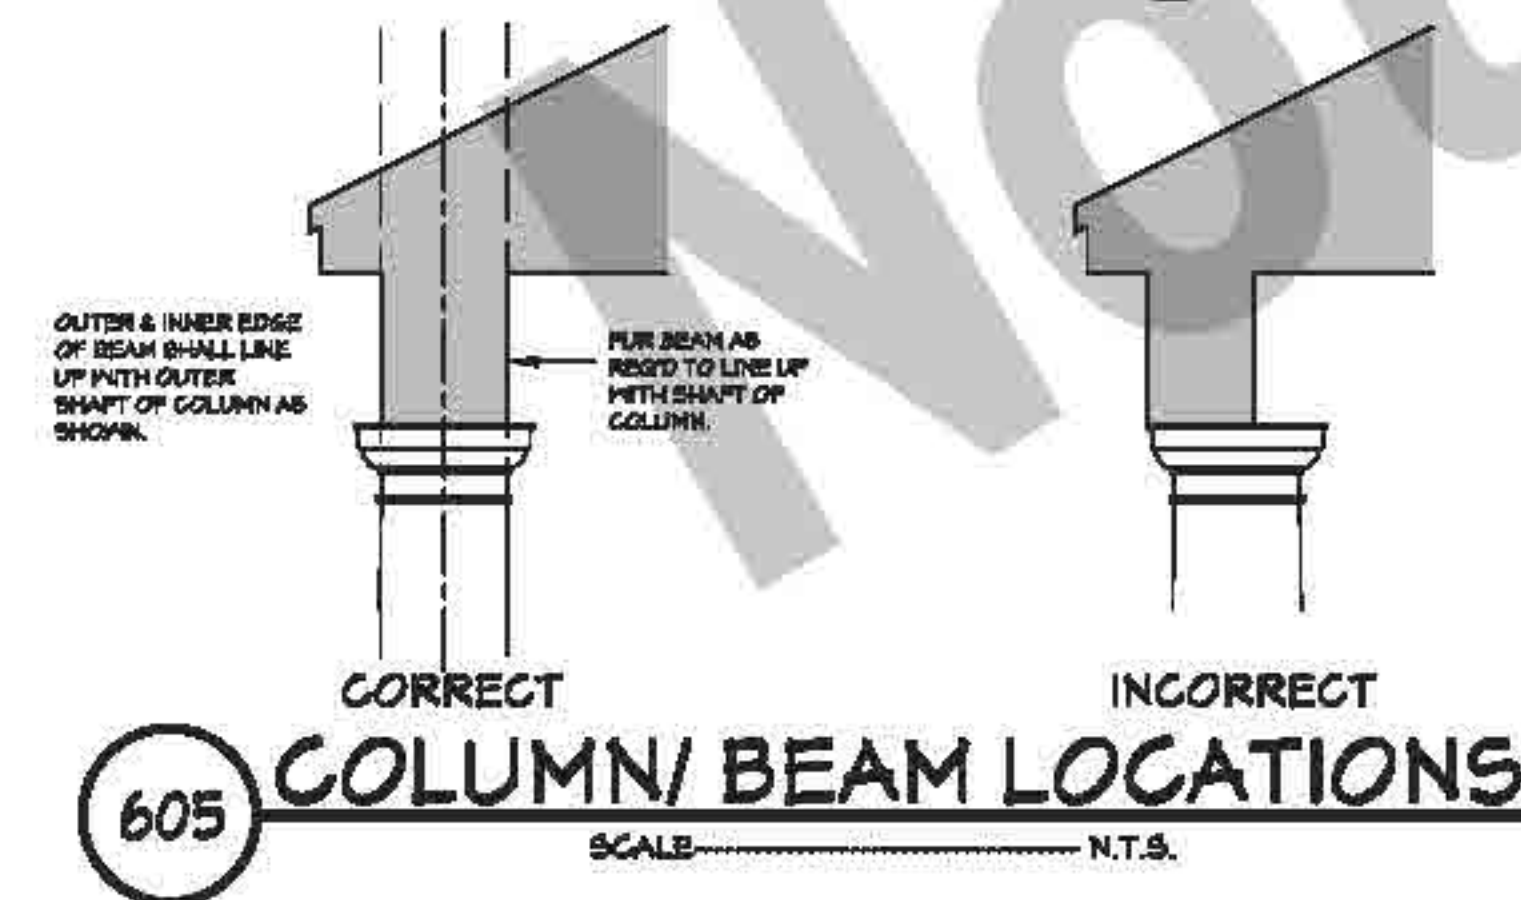

605 CORRECT COLUMN/ BEAM LOCATIONS
SCALE N.T.S.

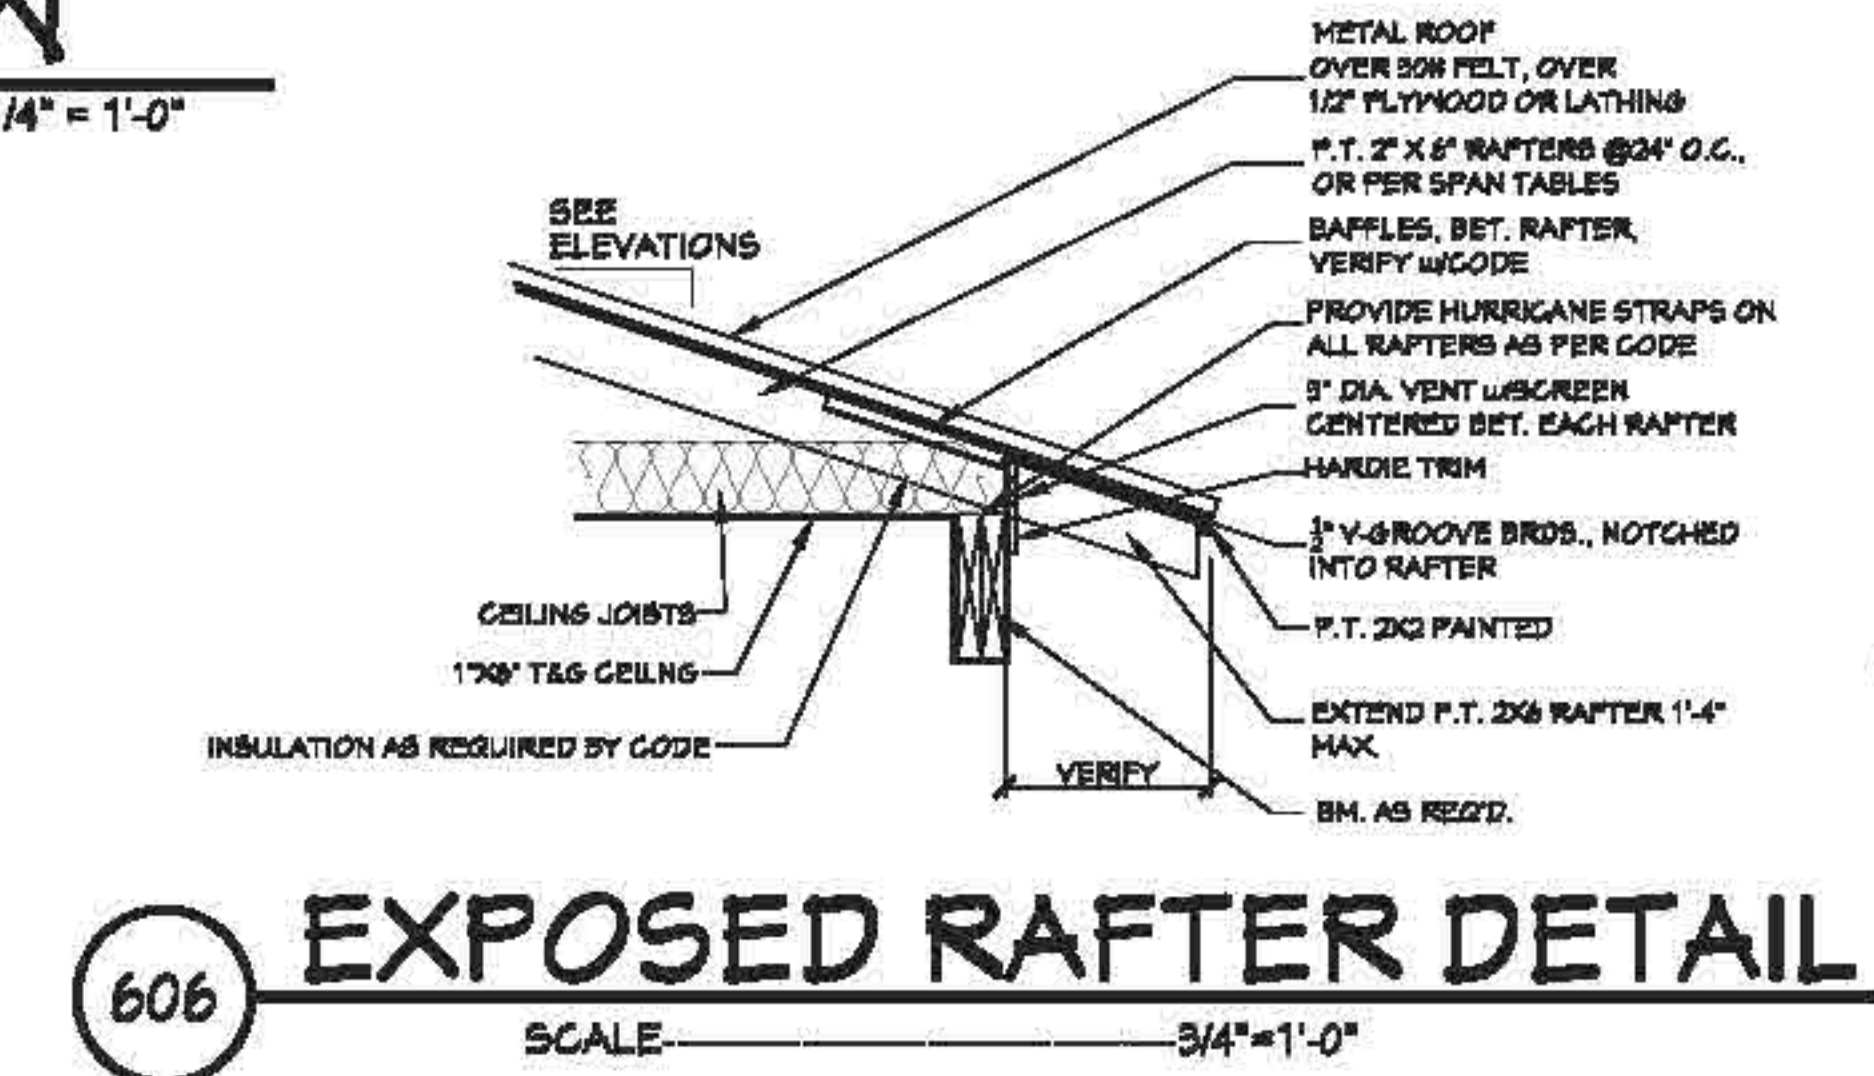


606 EXPOSED RAFTER DETAIL
SCALE 3/4" = 1'-0"

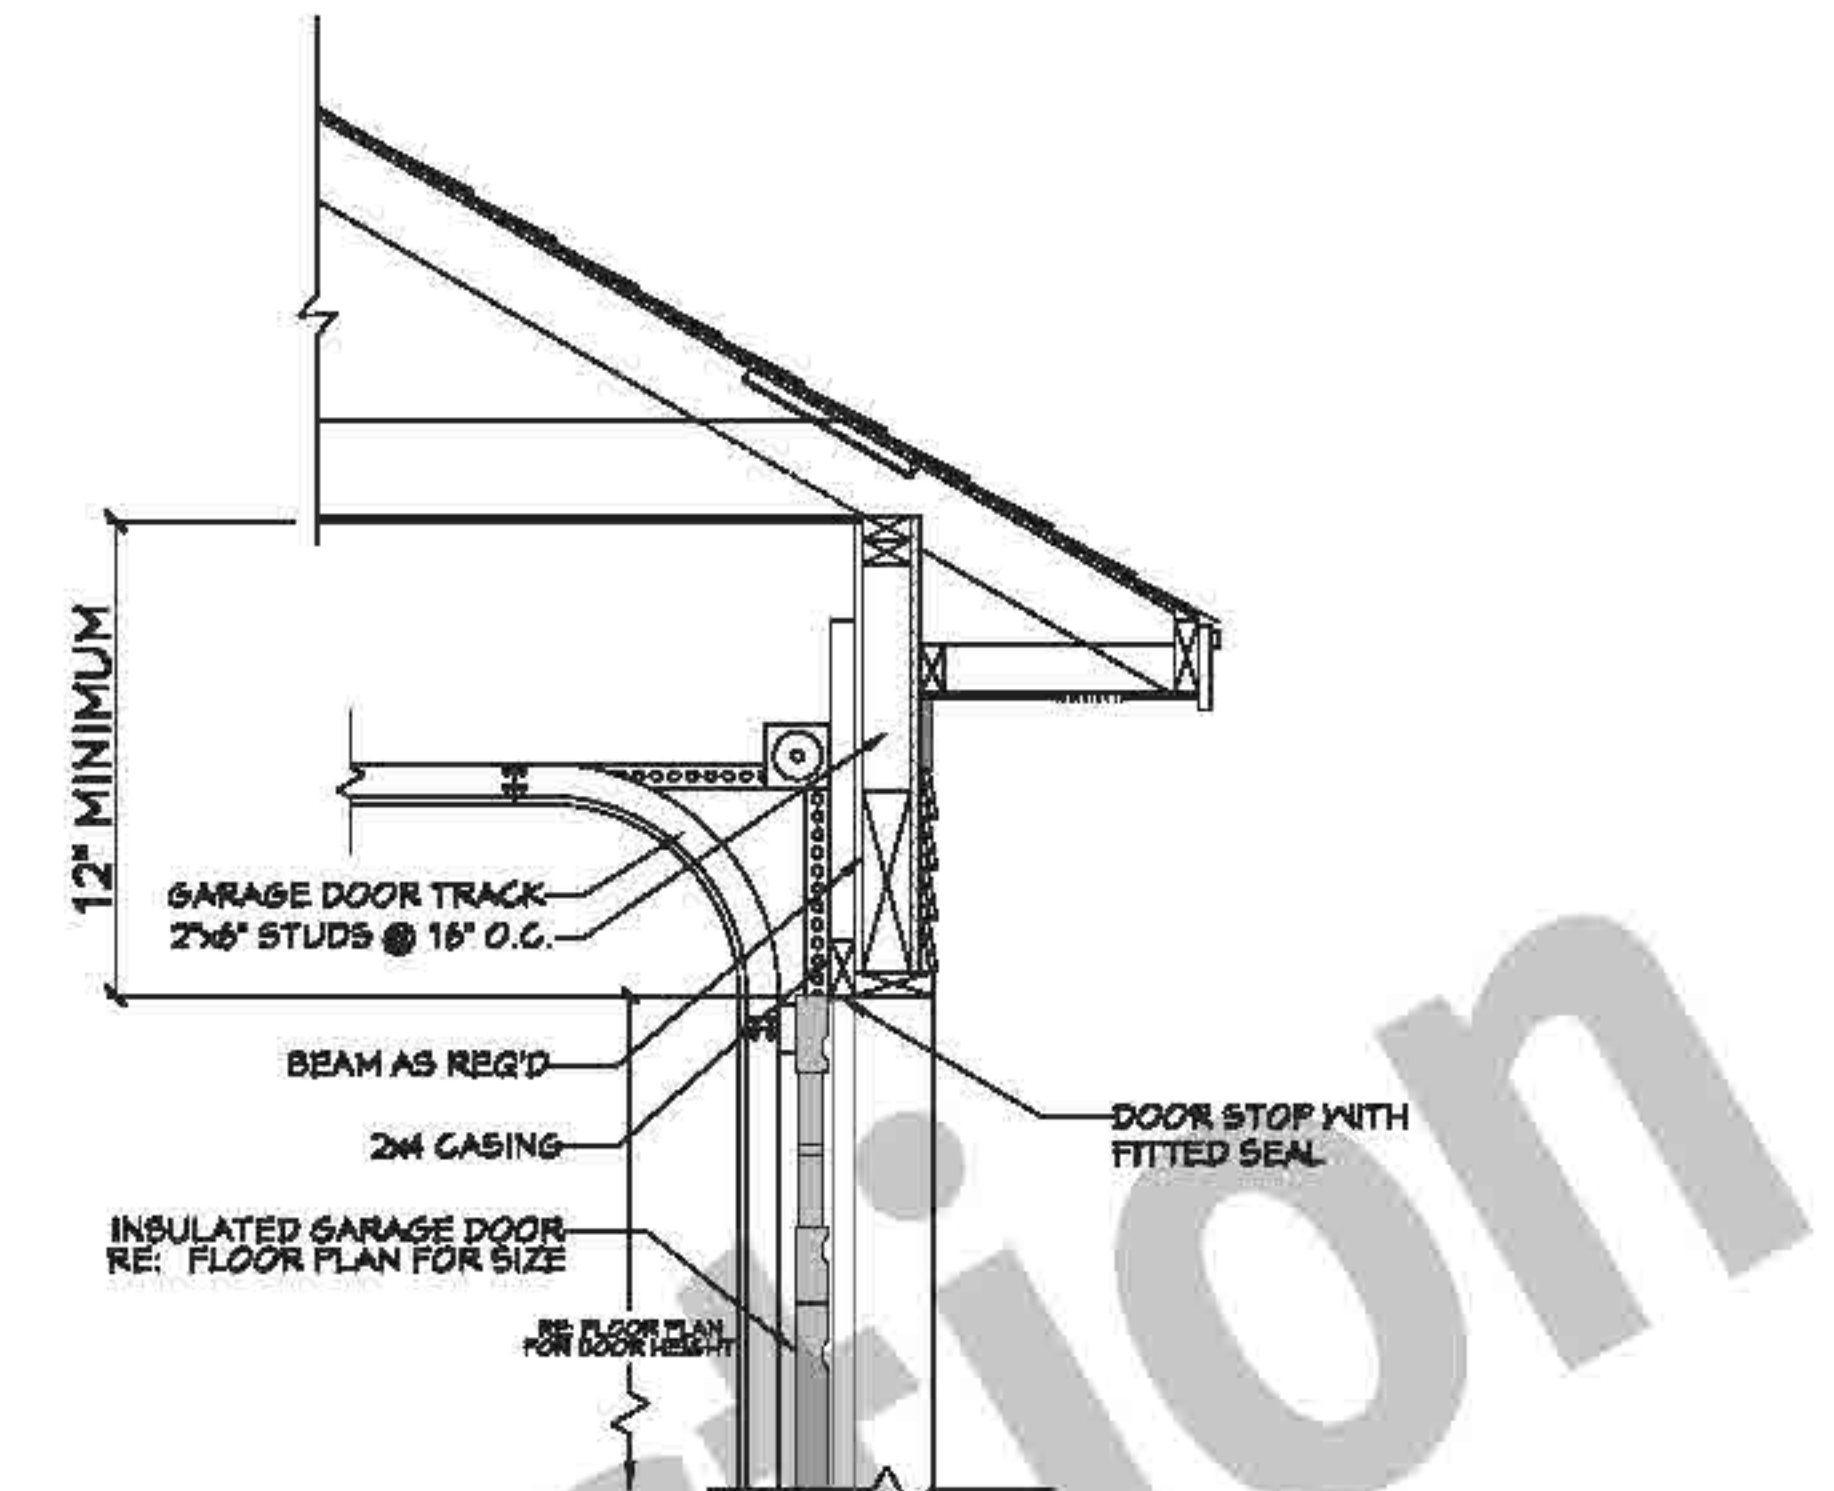

603 GARAGE DOOR CLEARANCE
SCALE N.T.S.

THE INTENT OF THIS DETAIL IS TO SHOW THE MINIMUM REQUIRED DISTANCE FROM THE TOP OF THE GARAGE DOOR OPENING TO THE CEILING OF THE GARAGE.

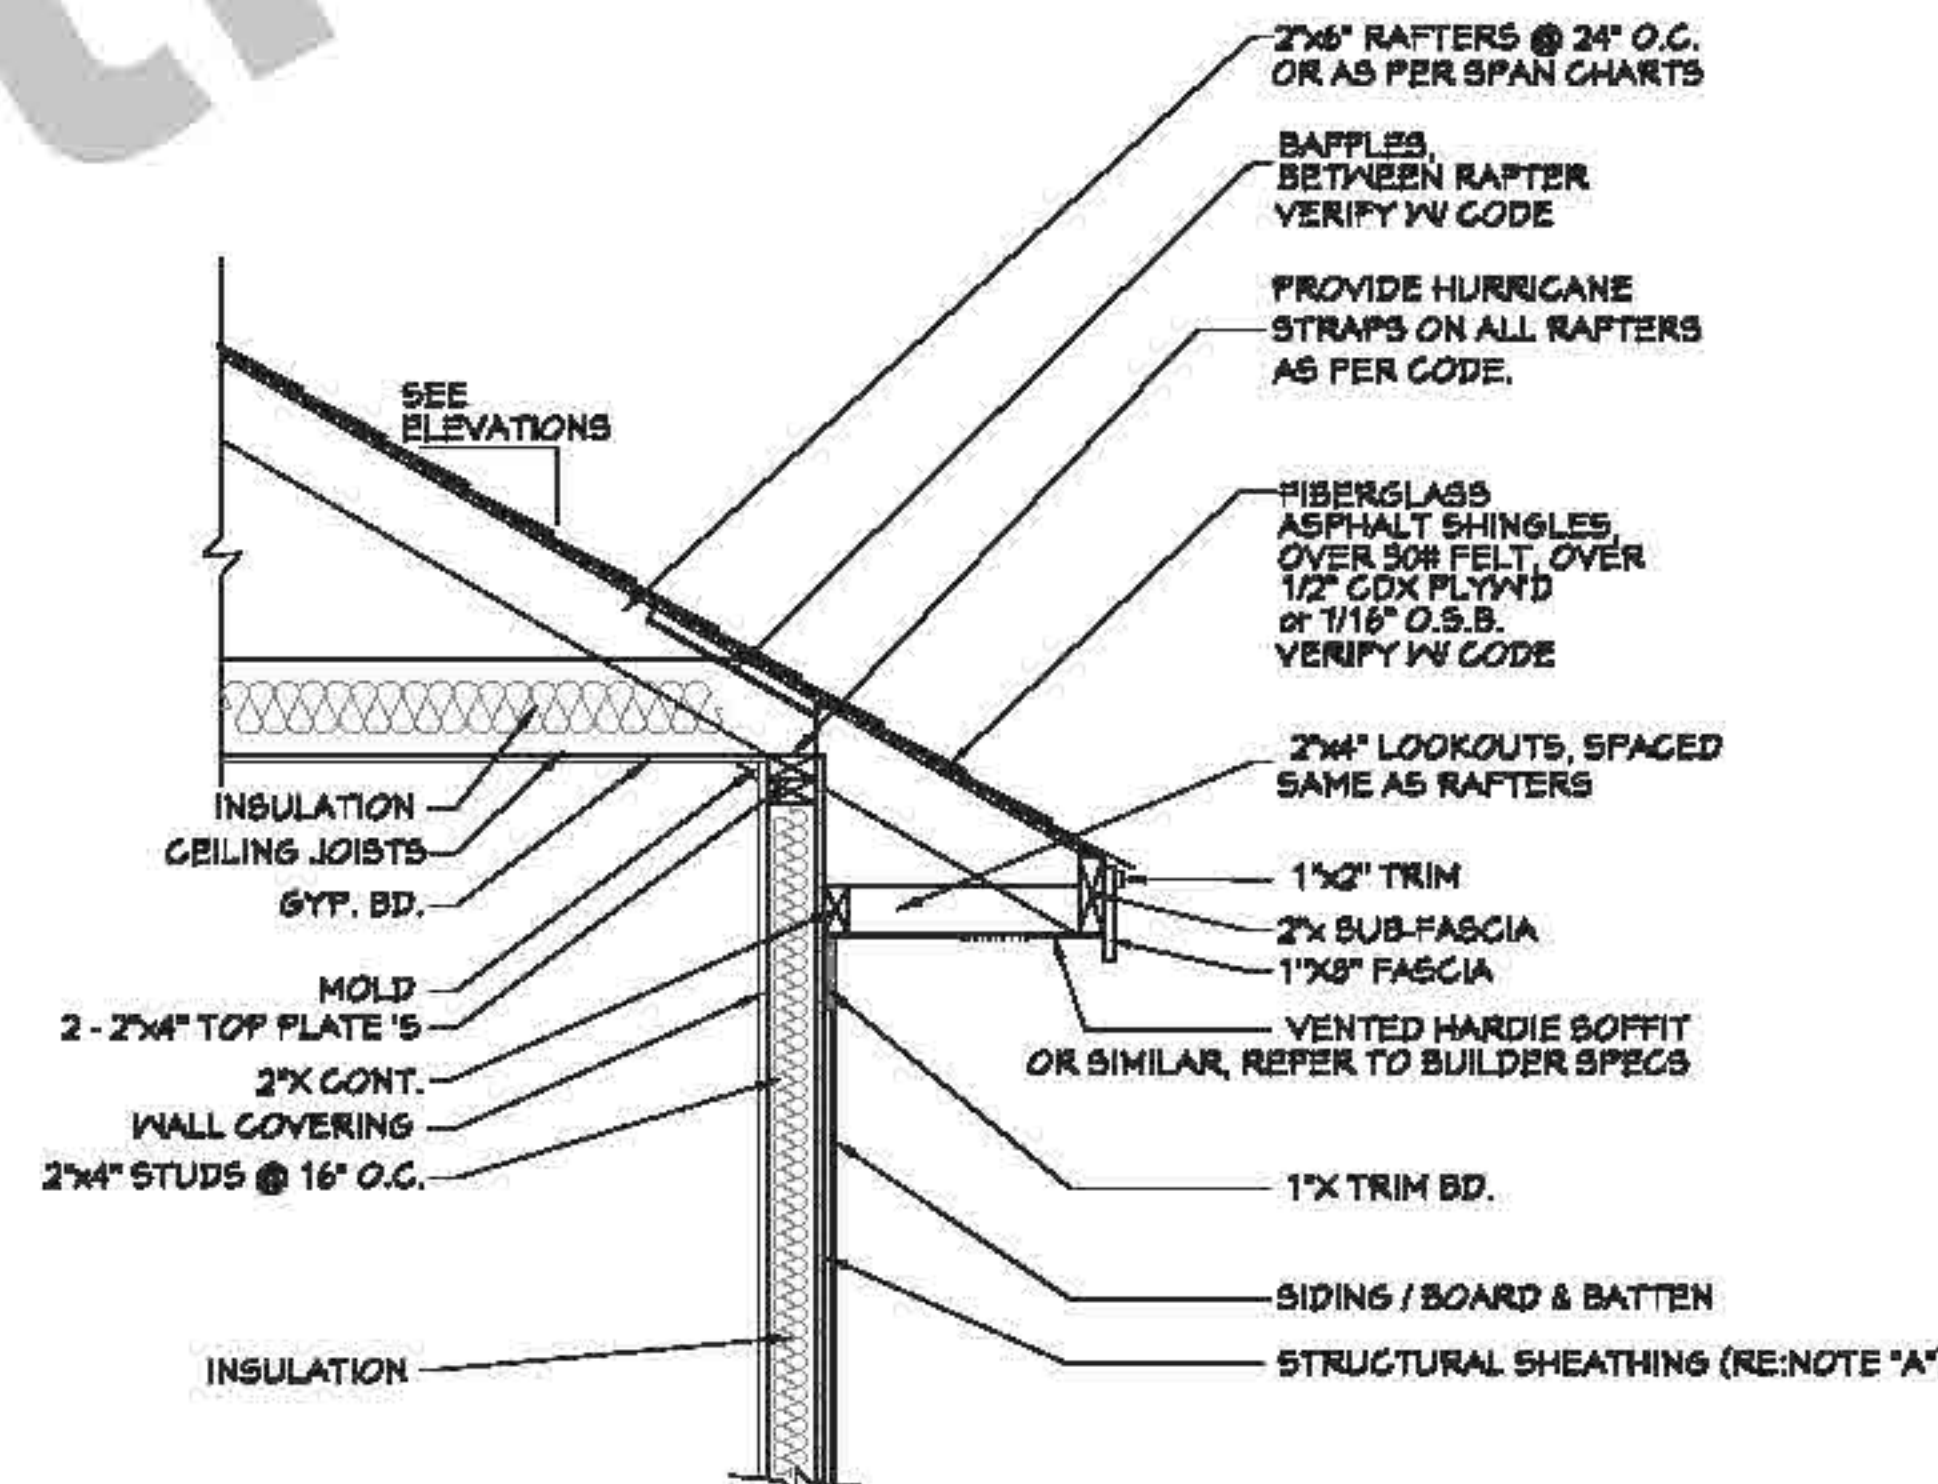

NOTE "A": PROVIDE A MINIMUM OF 7/16" STRUCTURAL WOOD PANEL ATTACHED w/ 8d COMMON OR 10d BOX NAILS AT 4" SPACING ON EDGE AND 12" IN FIELD.
NOTE "B": CORNICE DETAIL FOR REFERENCE ONLY. REFER TO BUILDER SPECS FOR ACTUAL MATERIALS.

604 TYP. CORNICE DETAIL
SCALE 3/4" = 1'-0"




Date: 04.22.20

Drawn By: [Redacted]

© COPYRIGHT ALL RIGHTS RESERVED

SHEET NUMBER **6**

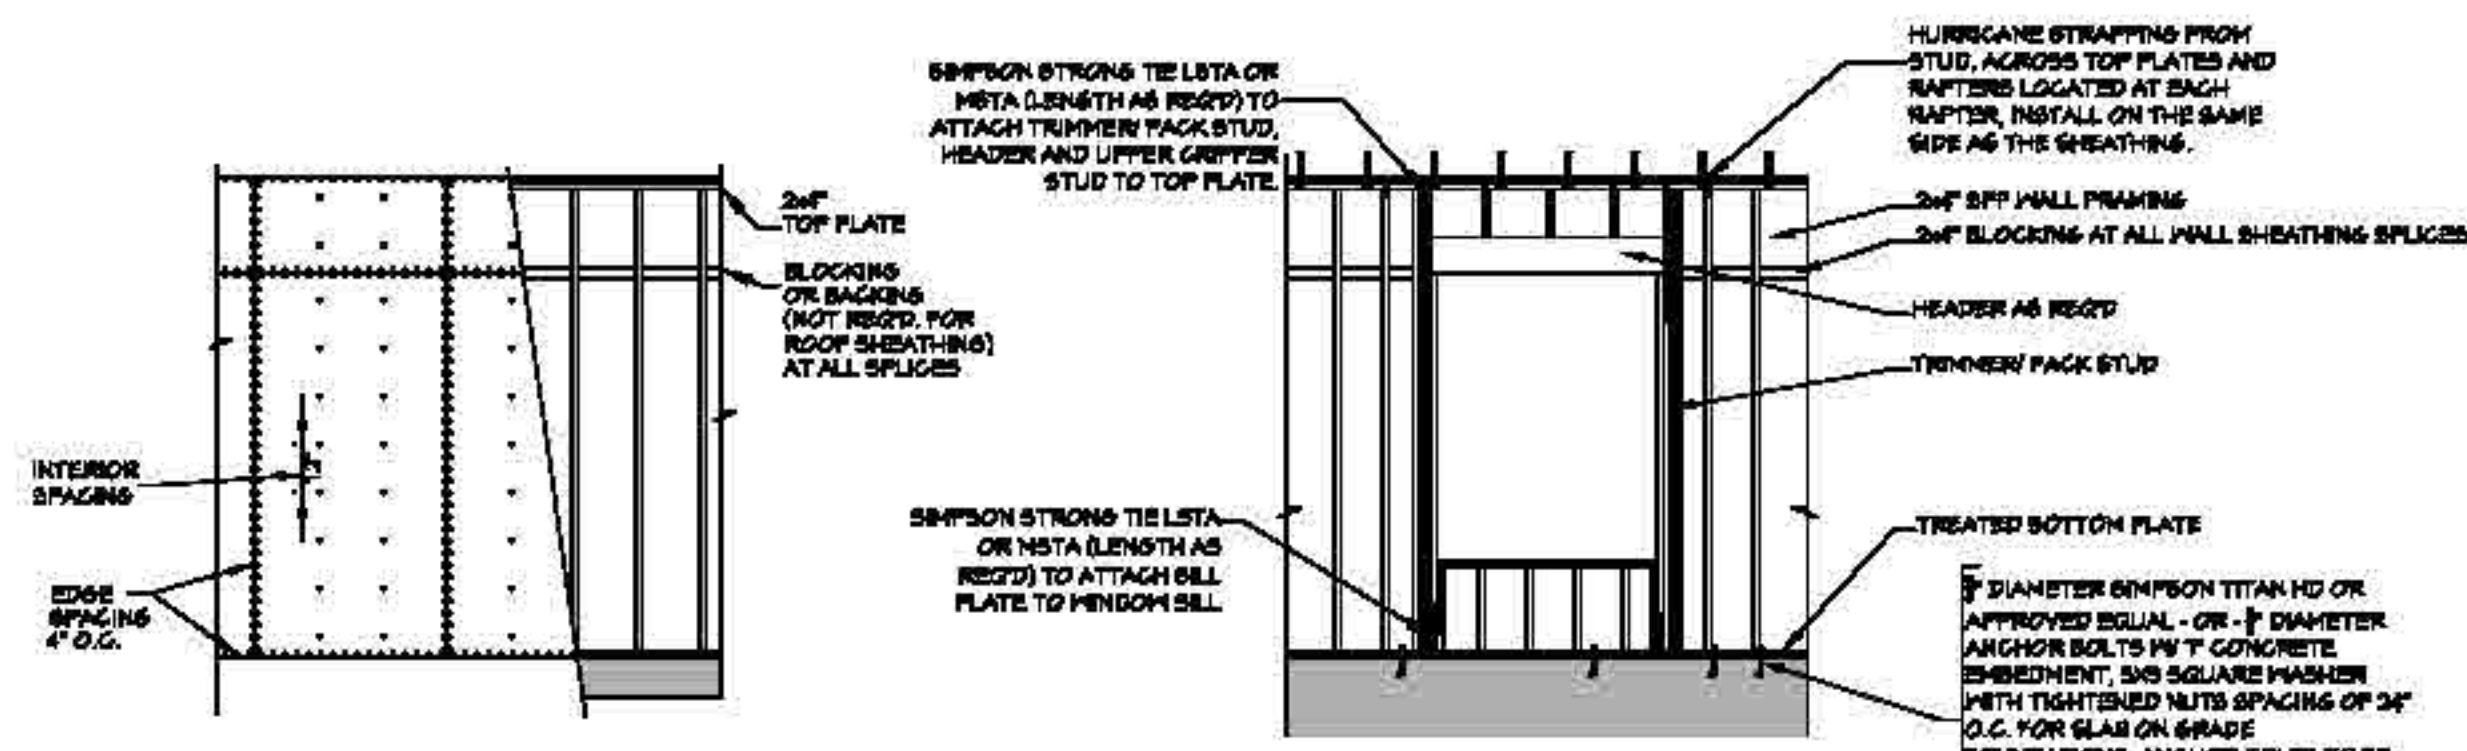

WALL/ROOF FASTENING DETAILS


701 SCALE 1/4" = 1'-0"

NAIL SIZE SPACING FOR WALL SHEATHING
 8d NAILS
 MIN. OF 7/16" O.S.B.
 EDGE SPACING = 4" O.C.
 INTERIOR SPACING = 12" O.C.

NAIL SIZE SPACING FOR ROOF SHEATHING
 8d NAILS
 MIN. OF 7/16" O.S.B.
 EDGE SPACING = 4" O.C.
 INTERIOR SPACING = 4" O.C.


NOTES:

1. ALL EXTERIOR SHEATHING TO EXTEND FROM BOTTOM OF BOTTOM PLATE TO THE TOP OF THE TOP PLATE. PROVIDE 2x4 OR GREATER COLLARIES ON EACH RAFTER IN THE UPPER THIRD OF ATTIC AND ATTACHED TO RAFTERS WITH 3 - 10d NAILS ON EACH SIDE. SHINGLES OR OTHER ROOF MATERIALS TO BE FASTENED AS PER MANUFACTURER'S INSTRUCTIONS FOR HIGH WIND APPLICATIONS.
2. EXTERIOR WALL FINISHES TO BE INSTALLED AS PER MANUFACTURER'S INSTRUCTIONS BASED ON HIGH WIND APPLICATIONS.

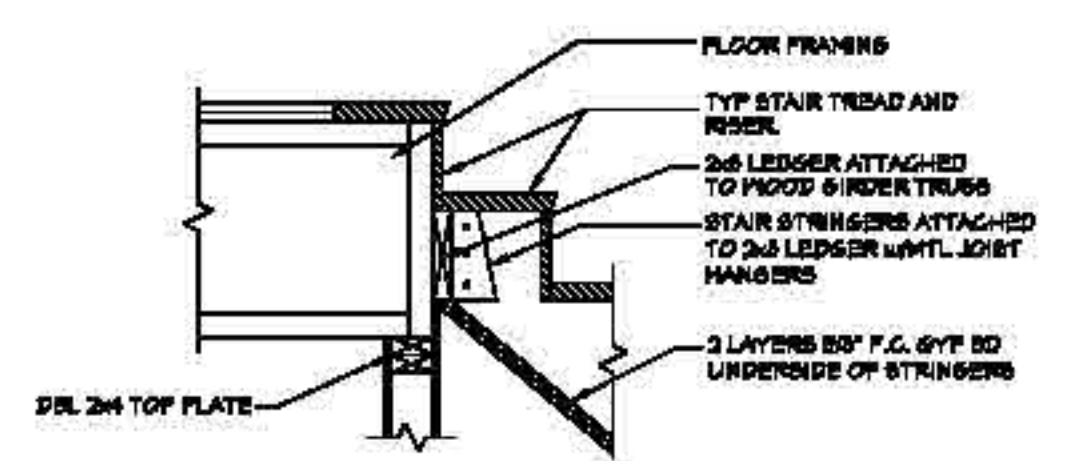


704 TYP. STAIR SECTION

SCALE N.T.S.

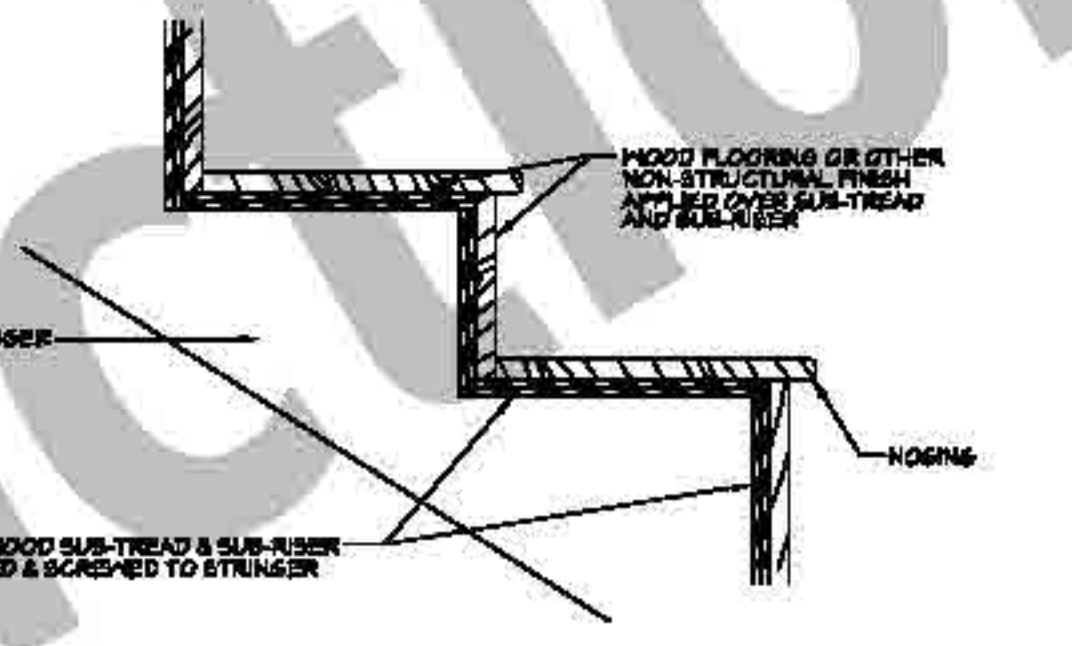



705 TREAD AND RISER

SCALE N.T.S.

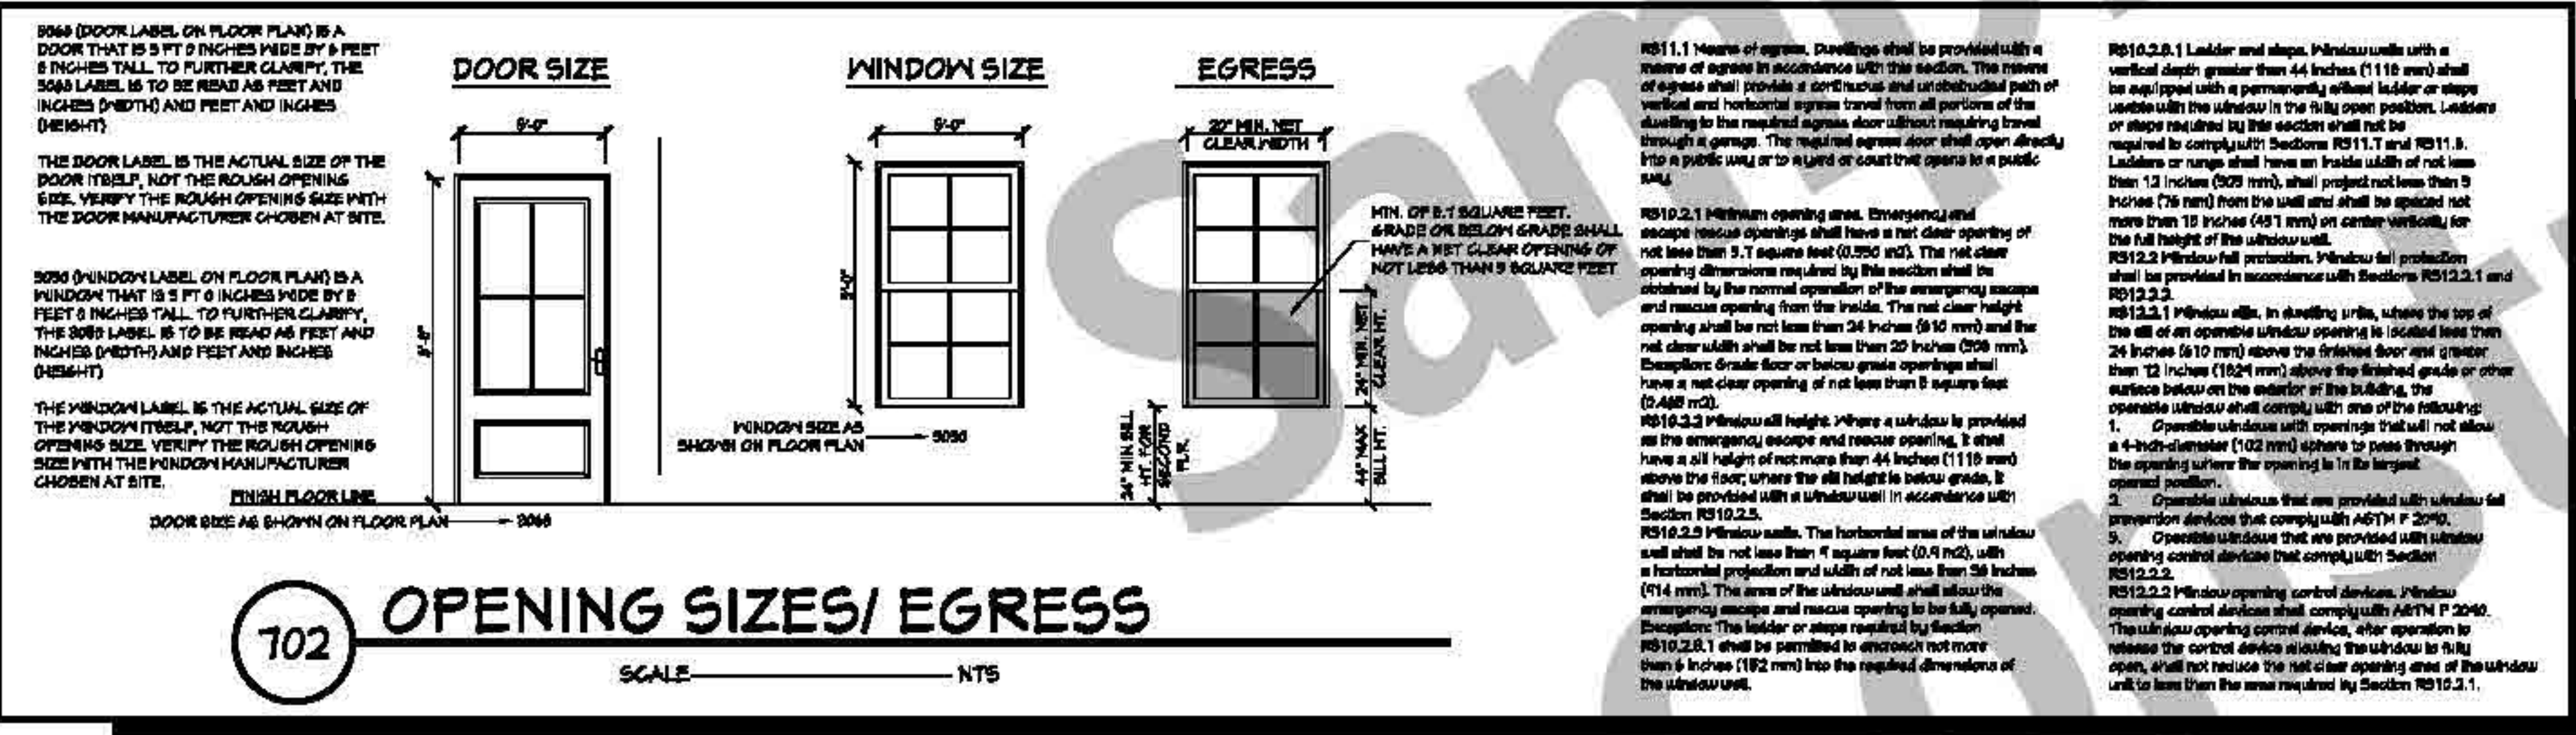

702 OPENING SIZES/ EGRESS


SCALE N.T.S.

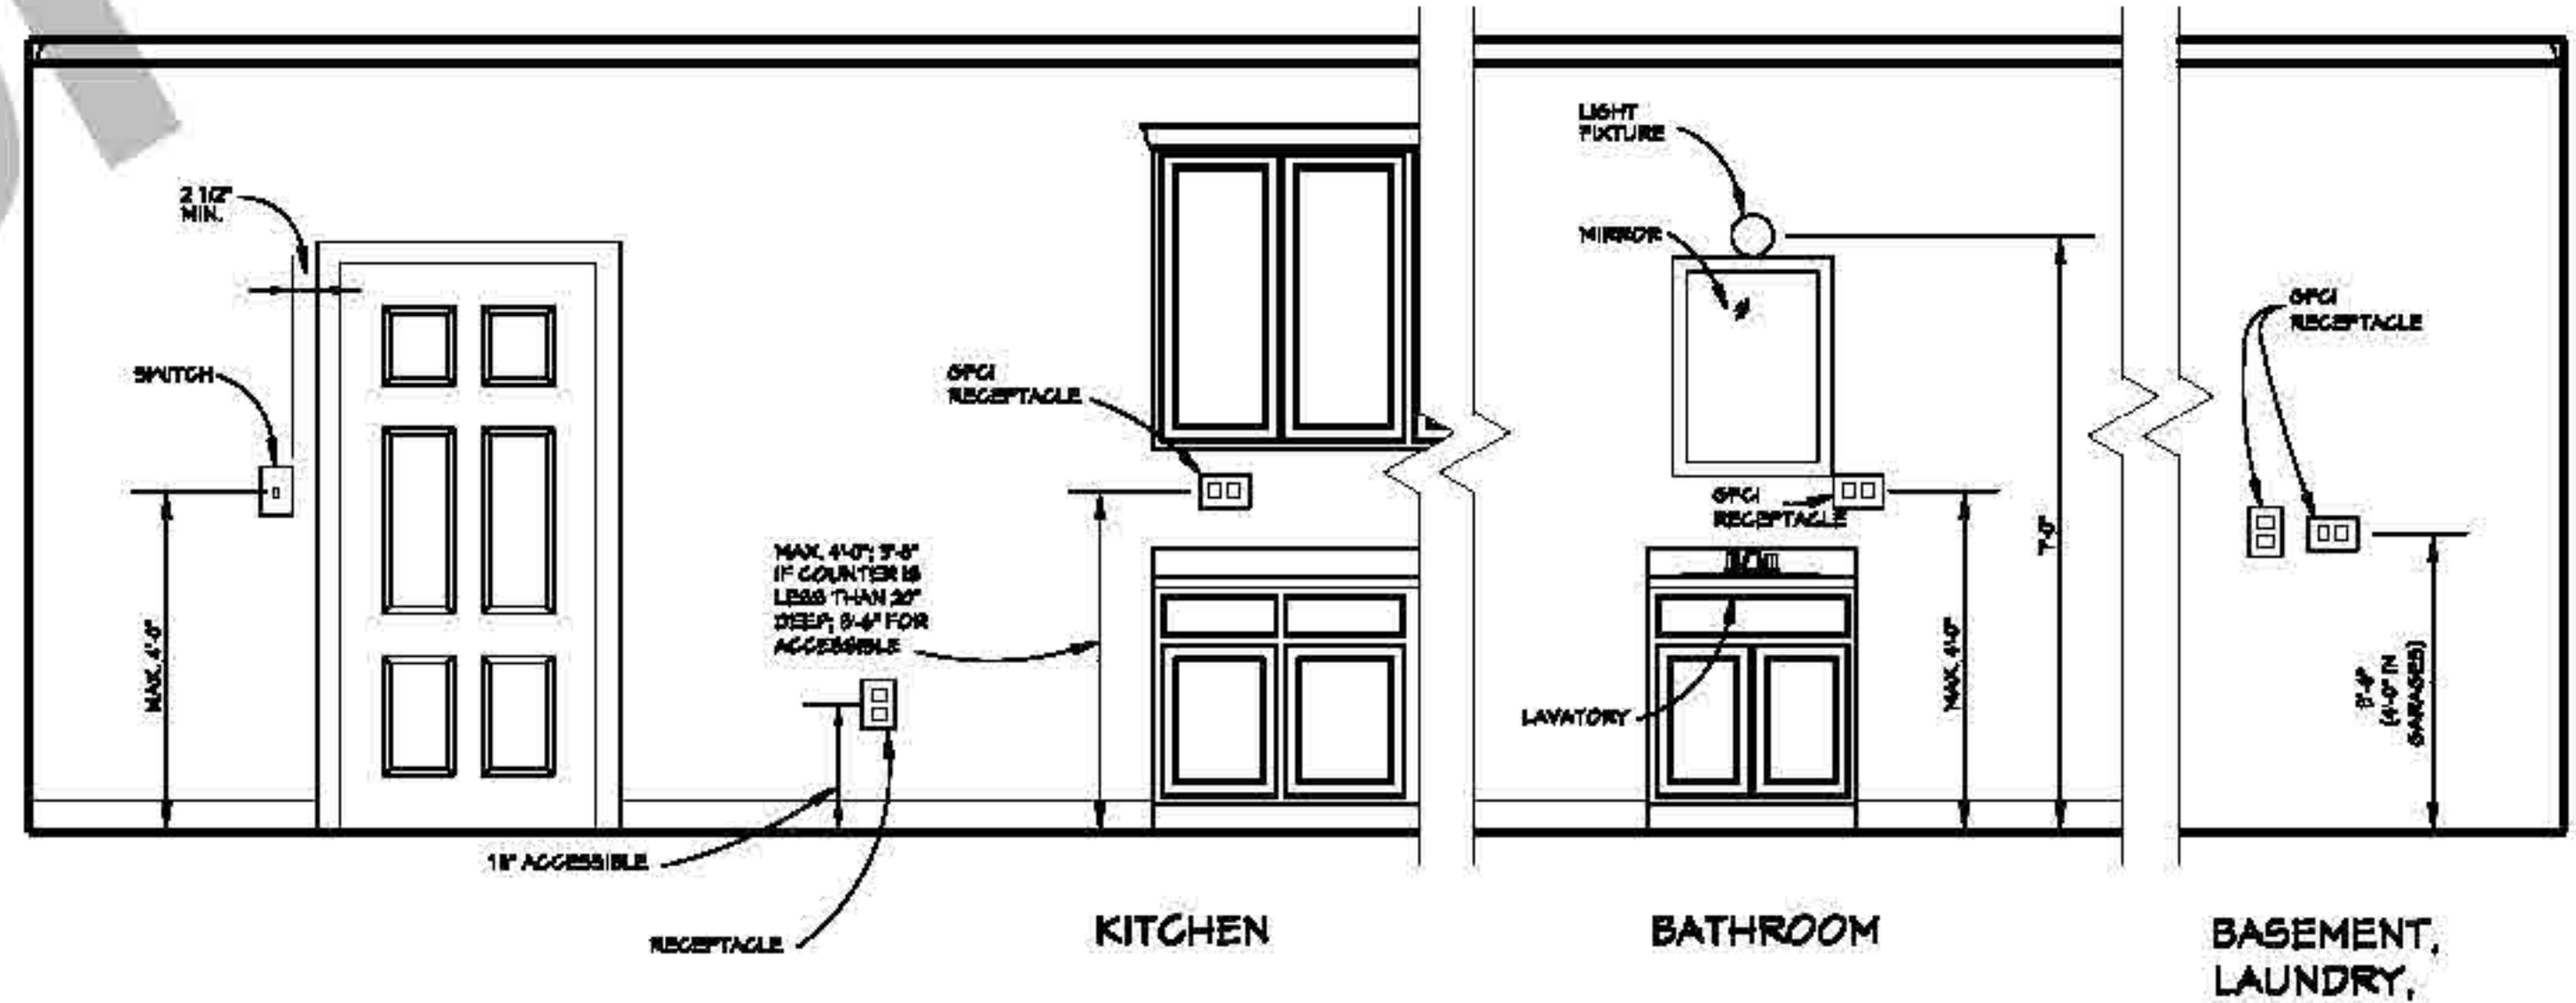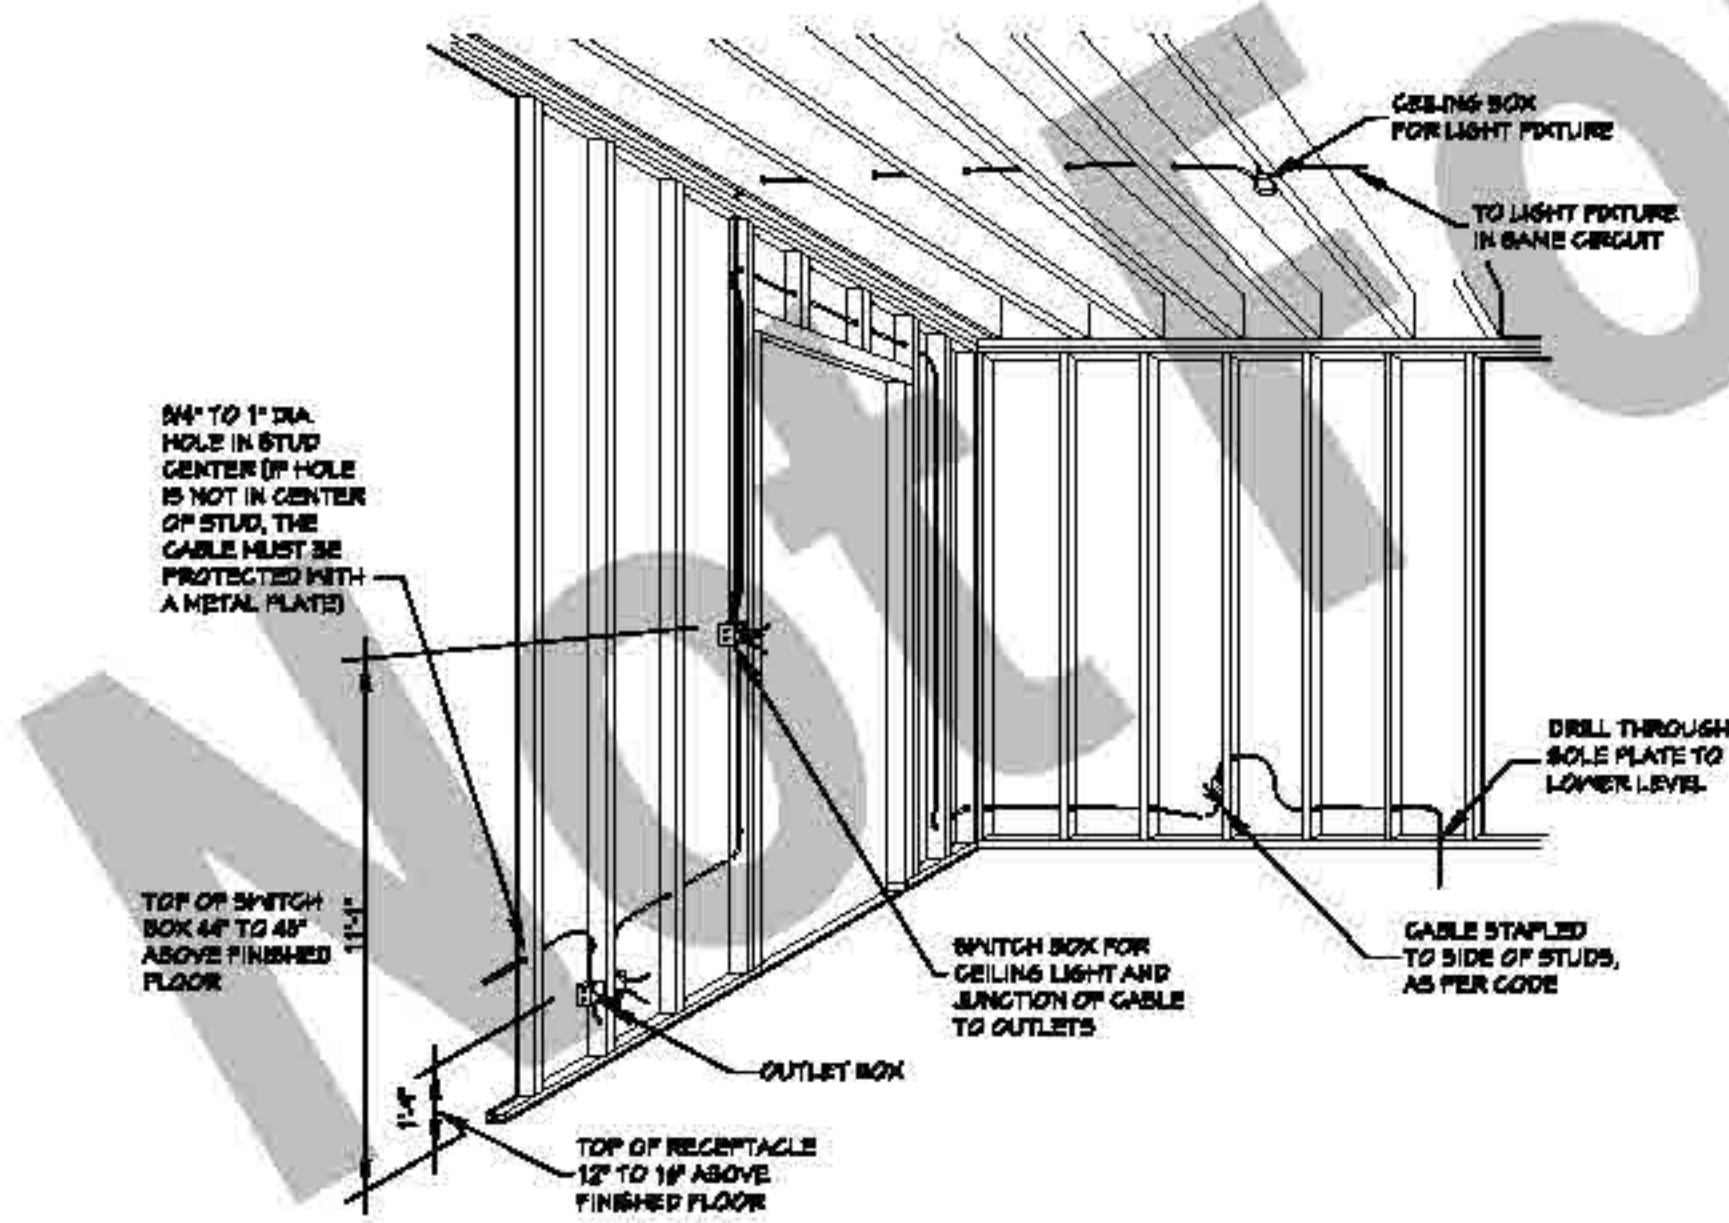

703 TYP. ELEC. DETAILS

SCALE N.T.S.

Date: 04.22.20
 Drawn By: [Redacted]
 © COPYRIGHT ALL RIGHTS RESERVED
 SHEET NUMBER 7

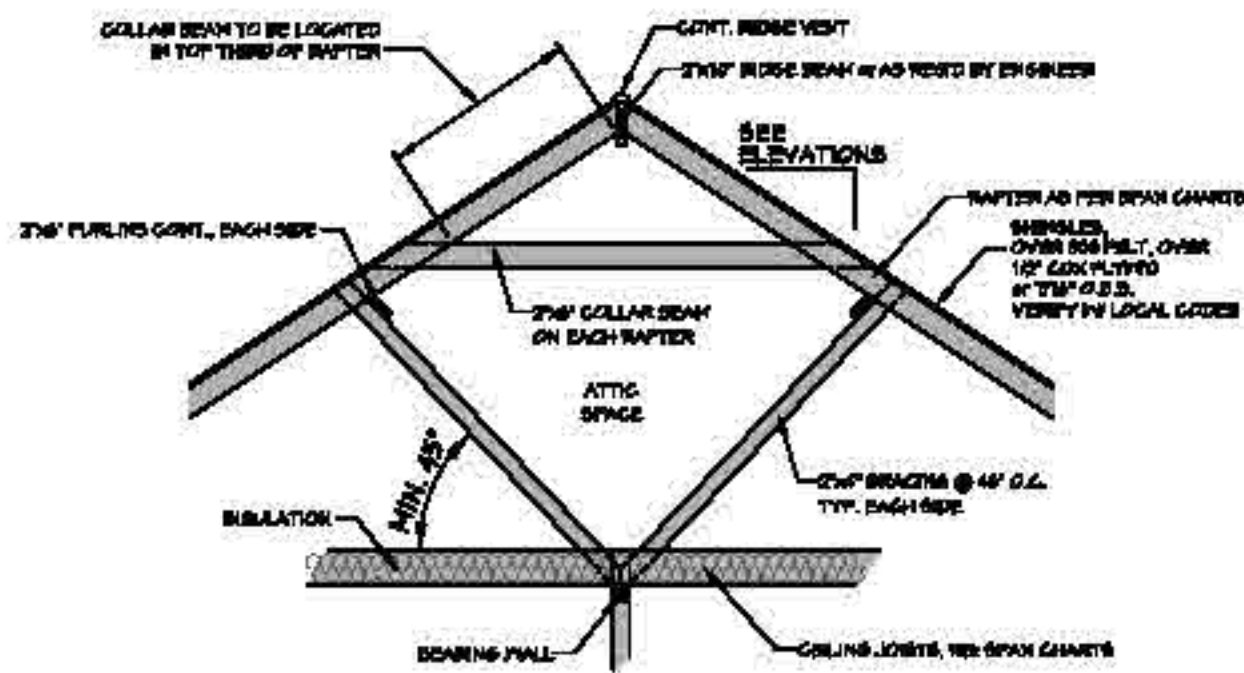

802 TYP. ROOF BRACING
SCALE _____ N.T.S.

- ROOF PLAN NOTES:**
1. CONTRACTOR SHALL COMPLY WITH ALL APPLICABLE CODES
 2. ALL RIDGE BEAMS, HIP RAFTERS, & VALLEY RAFTERS CONTRACTOR TO BE 2" X 10", No.2 S.Y.F. OR AS REQ'D BY ENGINEER.
 3. ALL RAFTERS TO BE SIZED AS PER SPAN CHART.
 4. CONTRACTOR TO WATERPROOF ALL ROOF INTERSECTIONS AS PER CODE.
 5. CONTRACTOR TO VERIFY ALL ROOF PITCHES WITH EXTERIOR ELEVATIONS PRIOR TO CONSTRUCTION.
 6. CONTRACTOR TO PROVIDE ADEQUATE ROOF VENTILATION AS PER CODE.

MAXIMUM HEADER SPANS

HEADER SPANS FOR EXTERIOR BEARING WALLS
SOUTHERN PINE #2 OR BETTER LIVE LOAD=30psf DEAD LOAD = 10psf
ALL SPANS ARE ASSUMING A MAXIMUM OF 24 FEET OF SUPPORTED ROOF FRAMING.

SUPPORTING ROOF AND CEILING ONLY


SIZE NUMBER OF PLIES IN (1)	MAXIMUM SPAN (FEET AND INCHES)	JACK STUDS
(2) 2x6	4-7	1
(2) 2x8	5-9	1
(2) 2x10	6-10	2
(2) 2x12	8-1	2
(3) 2x8	7-5	1
(3) 2x10	8-7	2
(3) 2x12	10-1	2

SUPPORTING ROOF, CEILING AND ONE CENTER BEARING FLOOR

SIZE NUMBER OF PLIES IN (1)	MAXIMUM SPAN (FEET AND INCHES)	JACK STUDS
(2) 2x10	5-8	2
(2) 2x12	6-8	2
(3) 2x10	7-2	2
(3) 2x12	8-5	2

NOTES:

1. THE ABOVE INFORMATION IS FROM THE 2018 IRC TABLE R602.1(1).
2. PLEASE REFER TO THE IRC 2018 FOR ADDITIONAL LUMBER SPECIES AND HEADER OPTIONS.
3. ALL HEADER SIZES SHALL BE DESIGNED/VERIFIED BY A LOCAL PROFESSIONAL.

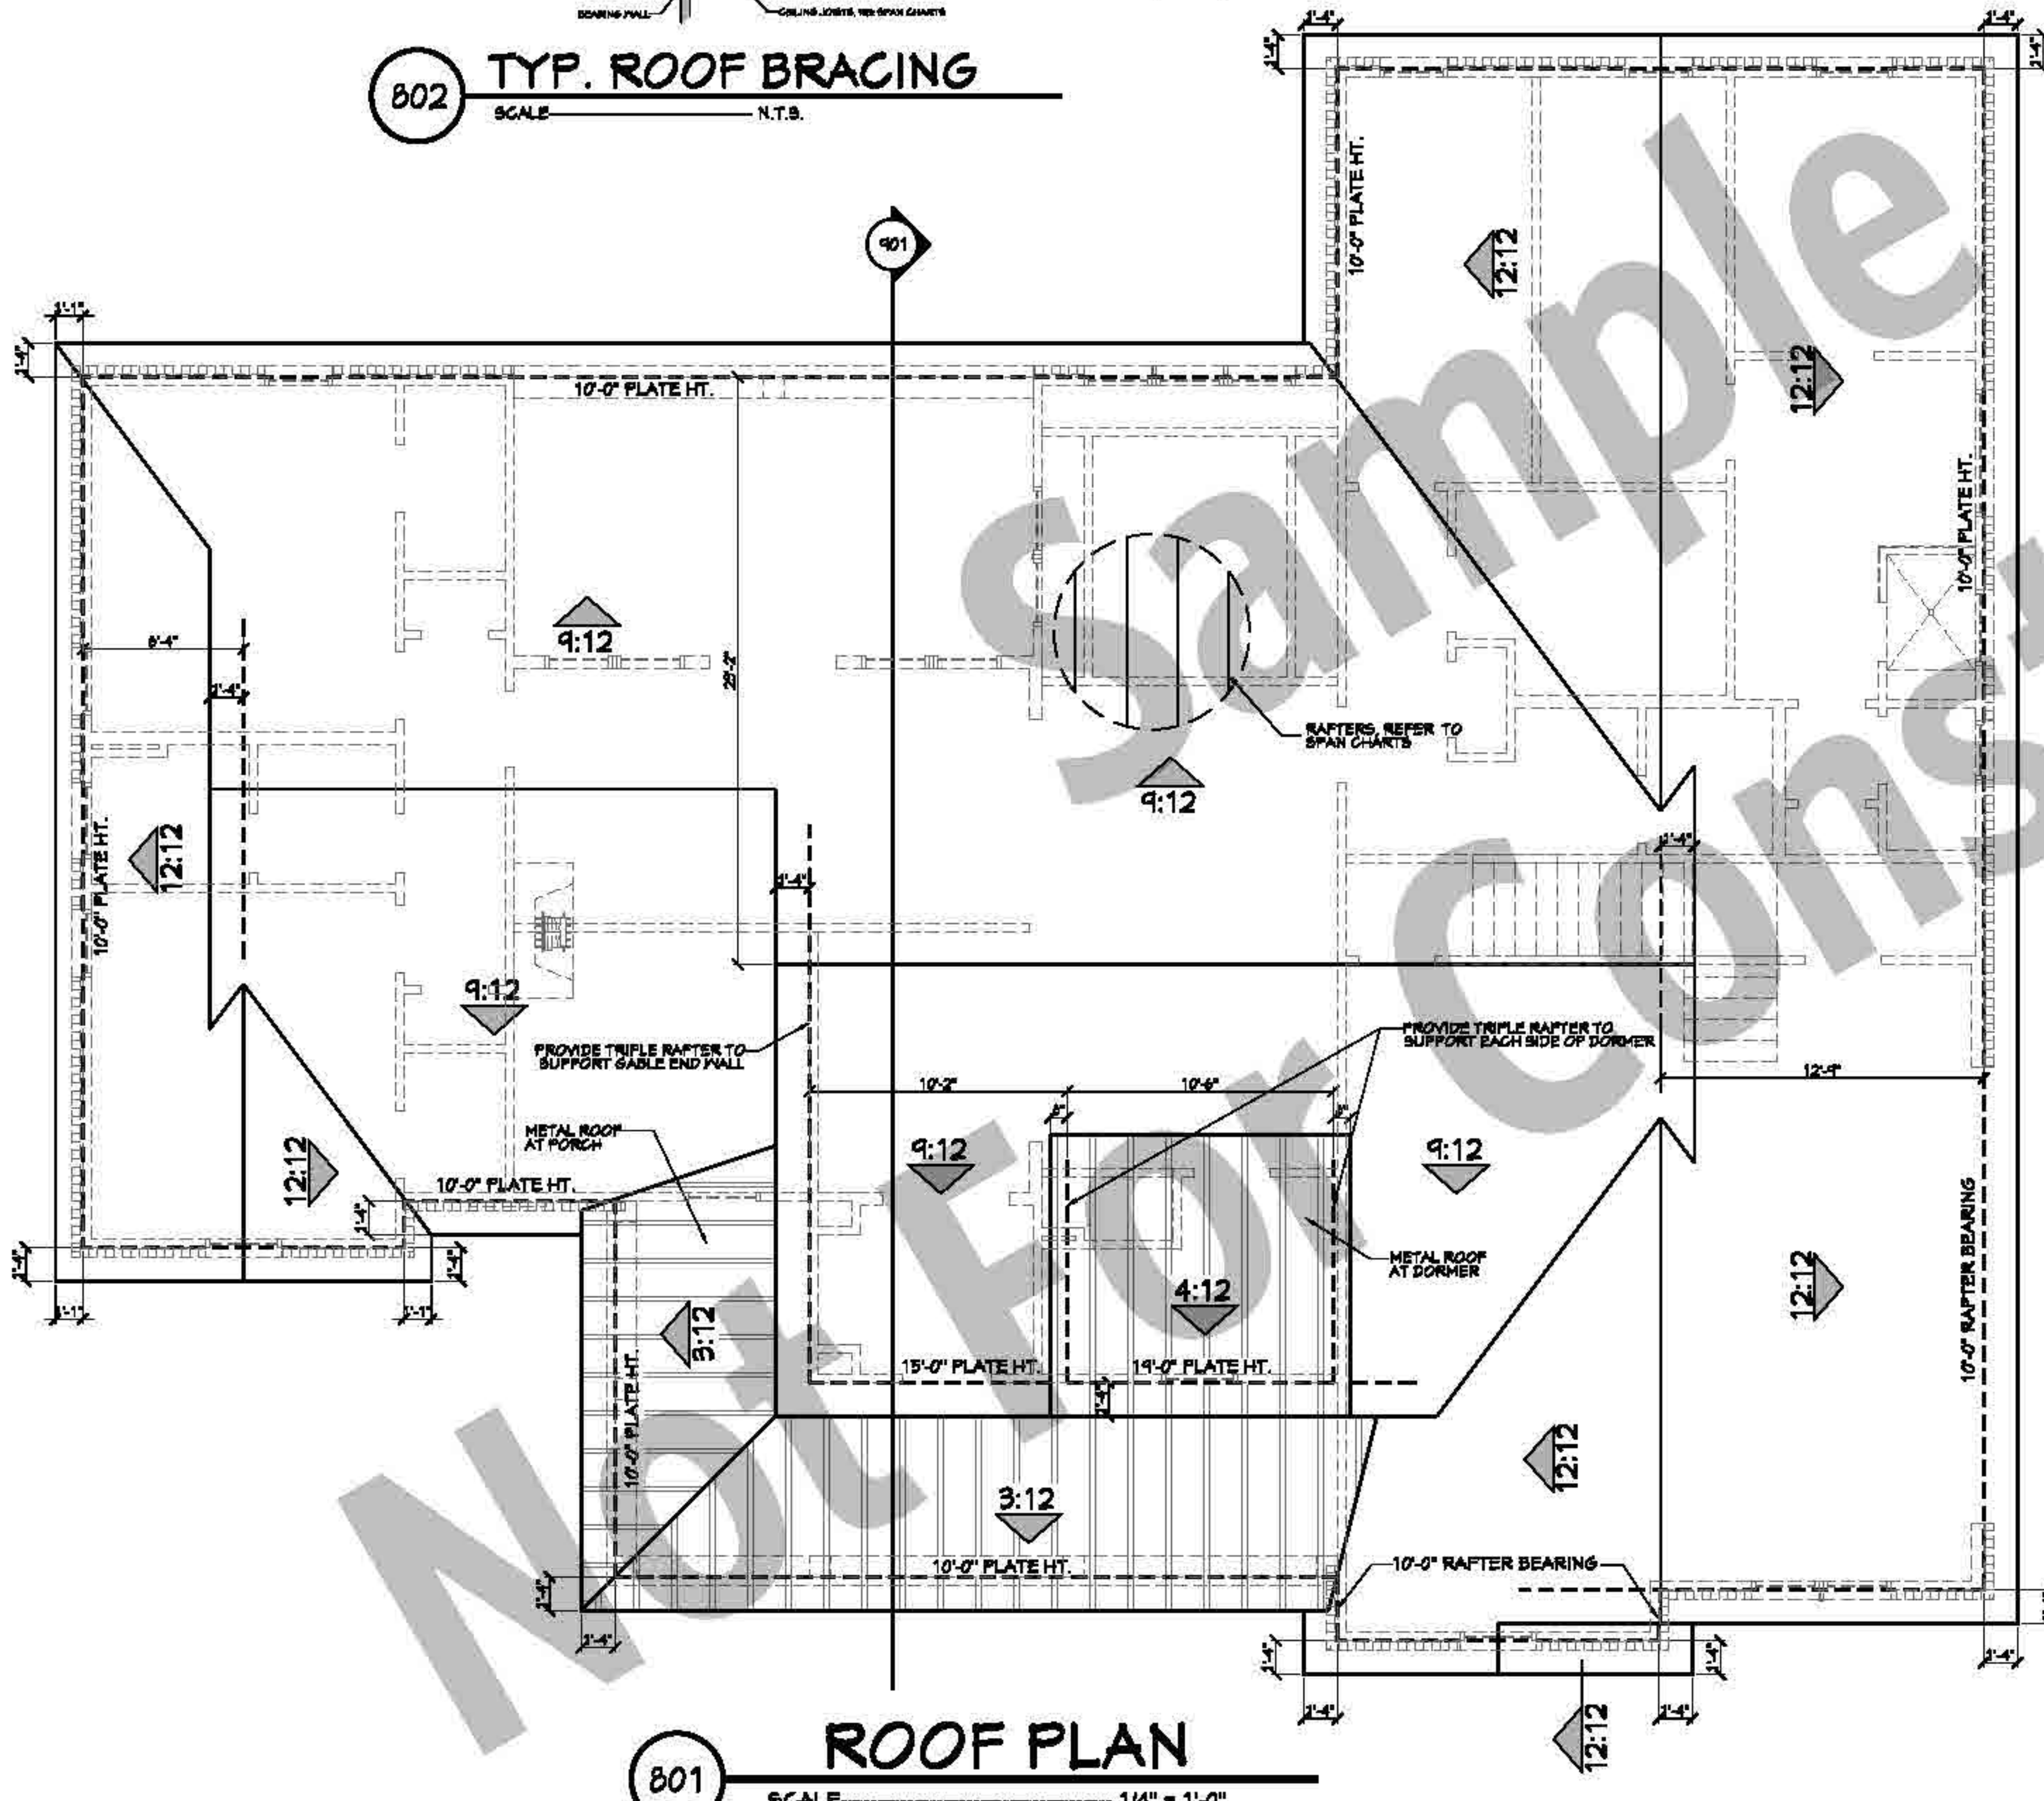

801 ROOF PLAN
SCALE _____ 1/4" = 1'-0"

RAFTER LENGTH CHART

ROOF PITCH	FACTOR
8:12	1.08
9:12	1.01
10:12	1.10
11:12	1.14
12:12	1.11
13:12	1.20
14:12	1.28
15:12	1.50
16:12	1.58
17:12	1.66
18:12	1.84
19:12	1.92
20:12	2.10

MULTIPLY HORIZONTAL SPAN OF MEMBER BY FACTOR TO CHOOSE APPROPRIATE FACTOR BY ROOF PITCH.

HIP/VALLEY CONVERSION

IF COMMON RAFTER ROOF PITCH IS:		THEN HIP/VALLEY RAFTER ROOF PITCH BECOMES:	
RIBS RUN	SLOPE	RIBS RUN	SLOPE
1/12	5°	1/11	5°
2/12	10°	2/11	7°
3/12	14°	3/11	10°
4/12	18°	4/11	13°
5/12	23°	5/11	16°
6/12	27°	6/11	19°
7/12	30°	7/11	22°
8/12	34°	8/11	25°
9/12	37°	9/11	28°
10/12	40°	10/11	30°
11/12	42°	11/11	33°
12/12	45°	12/11	35°

CONVERSION CHART FOR SIMPLE ROOFS ONLY. CHART DOES NOT APPLY FOR DUAL PITCH ROOFS.

CEILING JOIST SPANS

CEILING JOIST SPANS FOR SOUTHERN PINE SPECIES (UNINHABITABLE ATTICS WITH LIMITED STORAGE, LIVE LOAD = 20psf, L₂₄=240) DEAD LOAD = 10psf
IF HABITABLE ATTIC SPACE IS DESIRED, REFER TO THE INTERNATIONAL RESIDENTIAL CODE, SPAN TABLES

SIZE	SPACING (INCHES)	VISUALLY GRADED #2 SOUTHERN PINE (MAXIMUM CEILING JOIST SPANS) (FT. - IN.)
2x4	12.0	4-8
	16.0	6-0
	19.2	7-4
	24.0	8-7
2x6	12.0	10-11
	16.0	12-0
	19.2	11-0
	24.0	14-0
2x8	12.0	11-7
	16.0	15-0
	19.2	15-11
	24.0	12-6
2x10	12.0	20-11
	16.0	18-1
	19.2	16-6
24.0	14-4	

NOTES:
The above tables are based on the IRC 2018 TABLE R602.5.1(2)

RAFTER SPANS


RAFTER SPANS FOR SOUTHERN PINE SPECIES LIVE LOAD=30psf, L₂₄=180 DEAD LOAD = 10psf

SIZE	SPACING (INCHES)	SPANS (MAXIMUM RAFTER SPANS BETWEEN BRACING) (FT. - IN.)
2x6	12.0	12-11
	16.0	11-3
	19.2	10-2
2x8	12.0	9-2
	16.0	16-4
	19.2	14-2
2x10	12.0	12-11
	16.0	11-7
	19.2	11-1
2x12	12.0	19-5
	16.0	16-10
	19.2	15-4
2x12	24.0	13-9
	12.0	22-10
	16.0	14-10
	19.2	15-1
24.0	16-2	

NOTES:
The above tables are based on the IRC 2018 TABLE R602.4.1(3)



Date: 04.22.20
Drawn By: _____
© COPYRIGHT ALL RIGHTS RESERVED
SHEET NUMBER 8

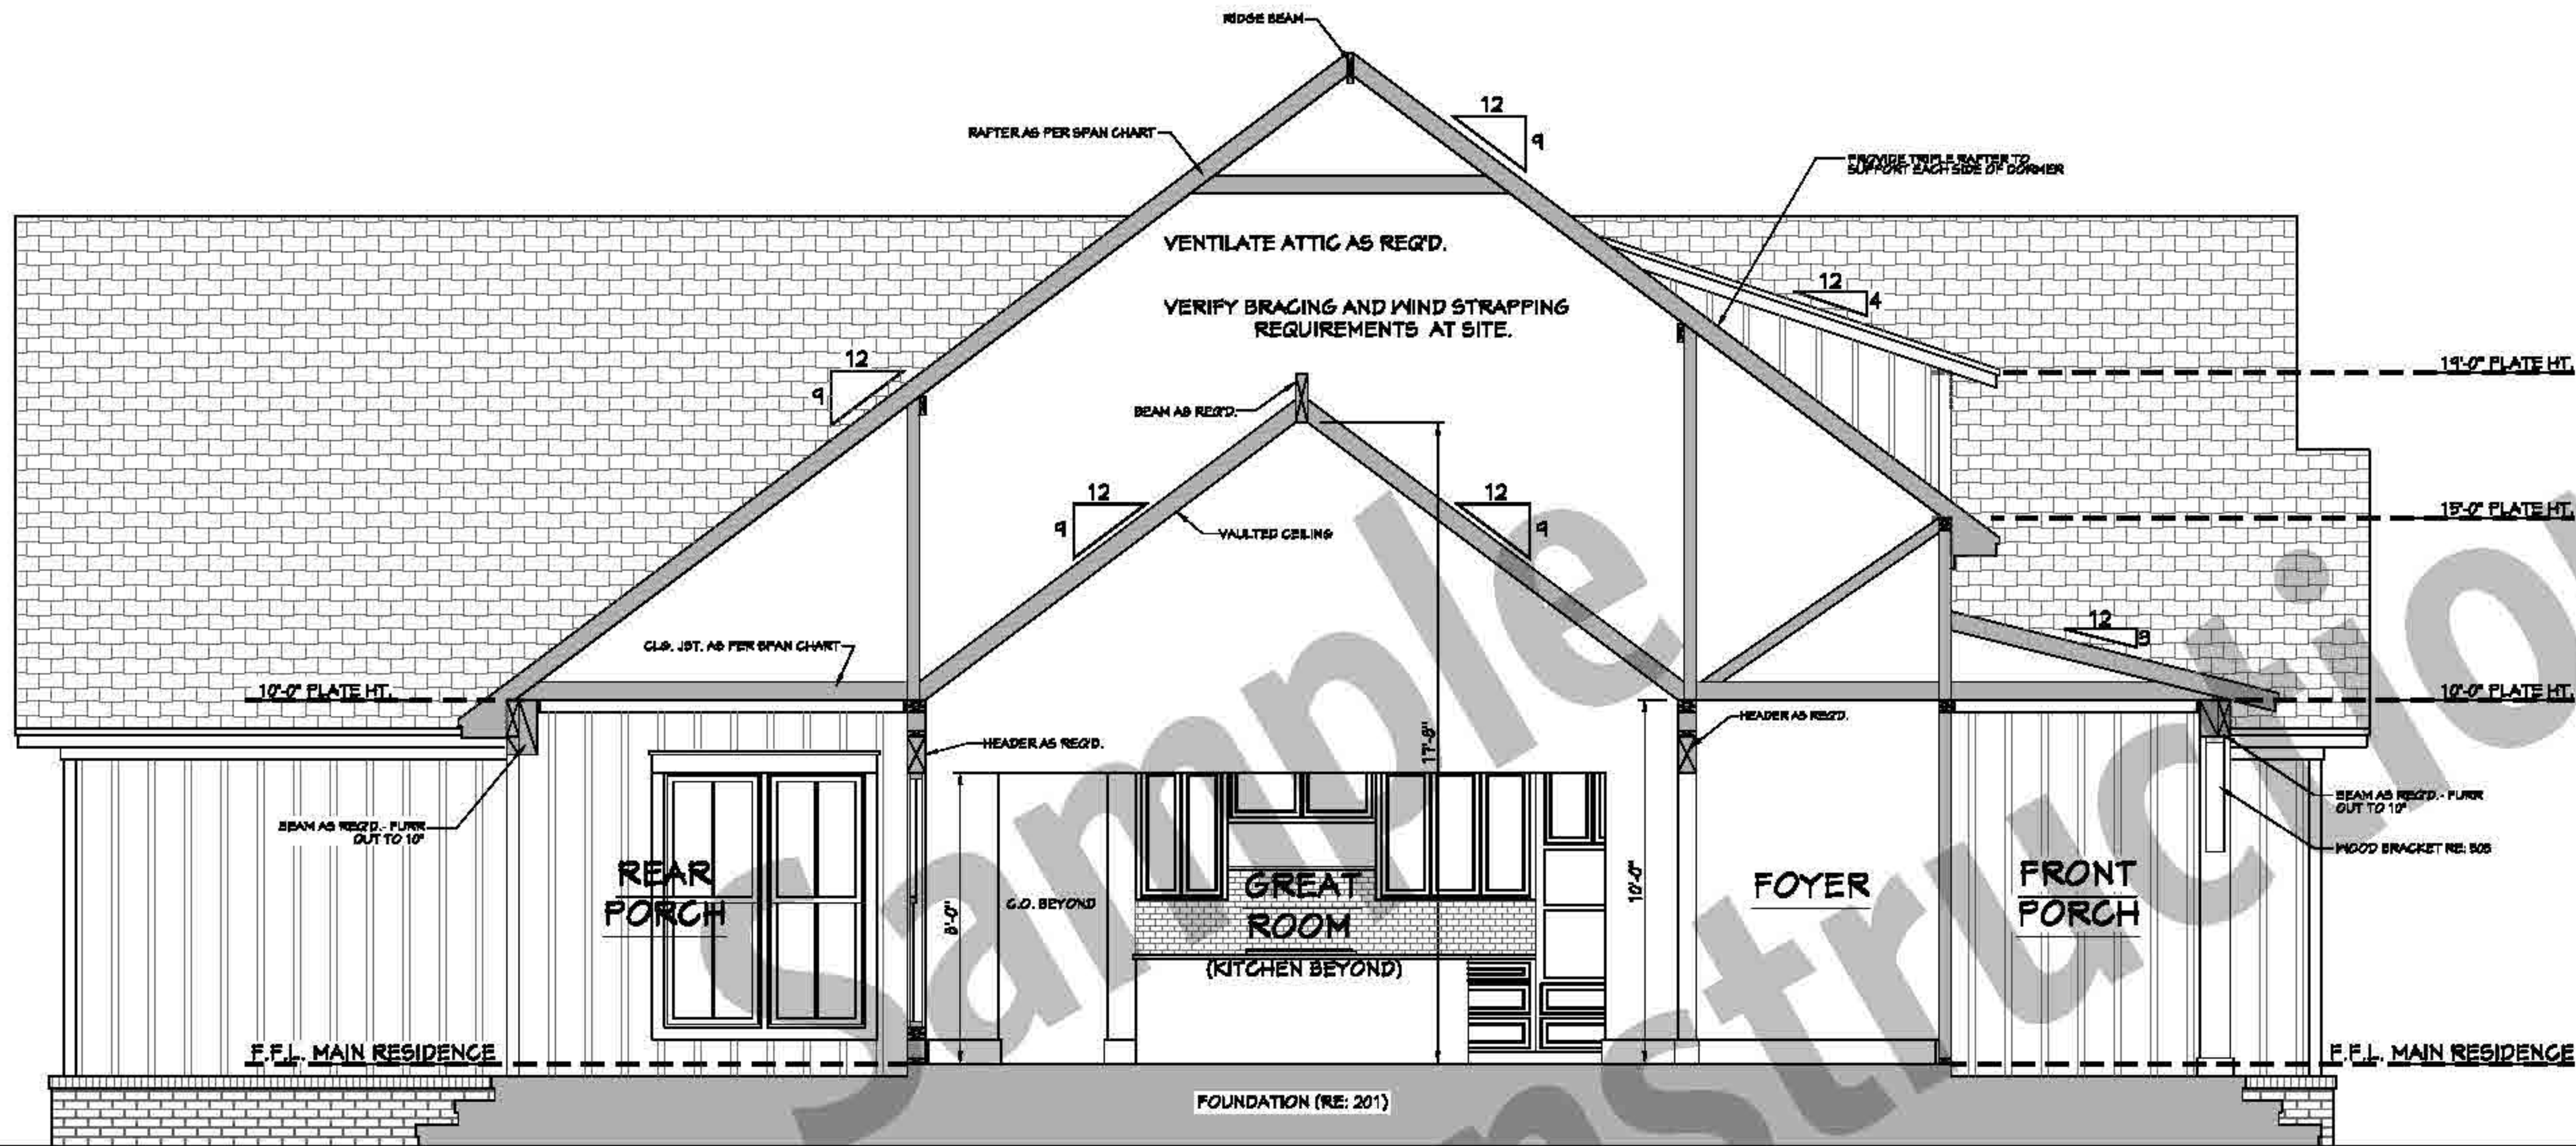


VERIFY STEPS @ SITE
PROVIDE HANDRAILS AS PER CODE

VERIFY STEPS @ SITE
PROVIDE HANDRAILS AS PER CODE


901 CROSS SECTION
SCALE: 3/8" = 1'-0"




- CROSS SECTION NOTES:**
1. CONTRACTOR SHALL COMPLY WITH ALL APPLICABLE CODES AT SITE.
 2. ALL RIDGE BEAMS, HIP RAFTERS, & VALLEY RAFTERS TO BE 2" x 10", OR AS REQUIRED BY LOCAL ENGINEER.
 3. CONTRACTOR TO PROVIDE RAFTER BRACING TO MEET APPLICABLE CODES.
 4. CONTRACTOR TO THOROUGHLY WATERPROOF ALL EXTERIOR INTERSECTIONS AS PER CODE AND TYPICAL BUILDING PRACTICES.
 5. ALL BEAMS TO BE SIZED BY A LOCAL PROFESSIONAL OR LICENSED STRUCTURAL ENGINEER.
 6. ALL LUMBER SIZES AND SPACING TO BE VERIFIED BY CONTRACTOR PRIOR TO CONSTRUCTION.
 7. CONTRACTOR TO PROVIDE ADEQUATE ROOF VENTILATION AS REQ'D. BY CURRENT CODES.

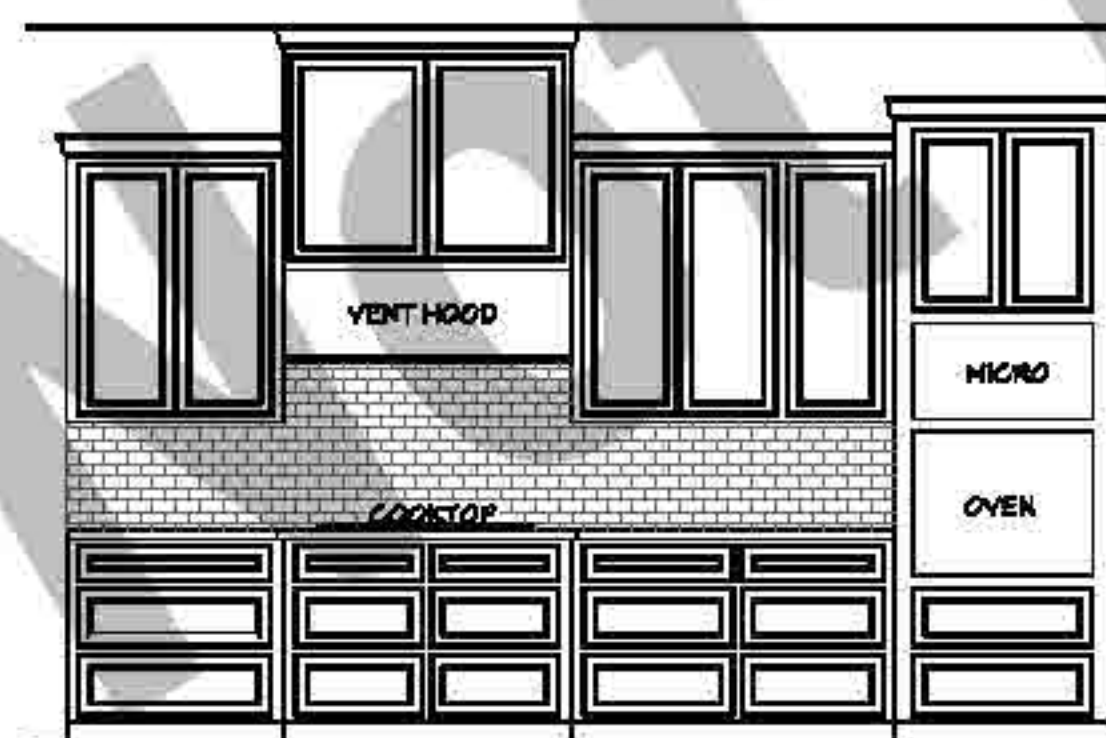


902 KITCHEN
SCALE: 3/8" = 1'-0"

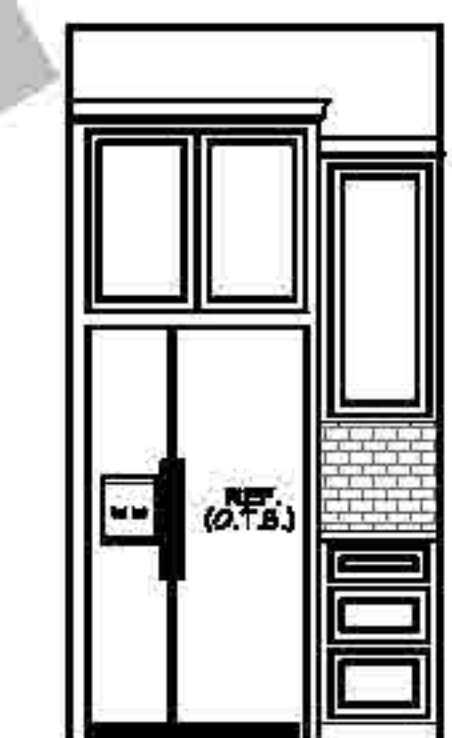


903 KITCHEN
SCALE: 3/8" = 1'-0"

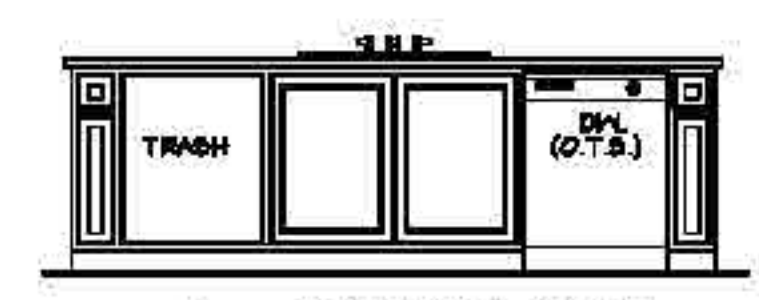


904 KITCHEN
SCALE: 3/8" = 1'-0"

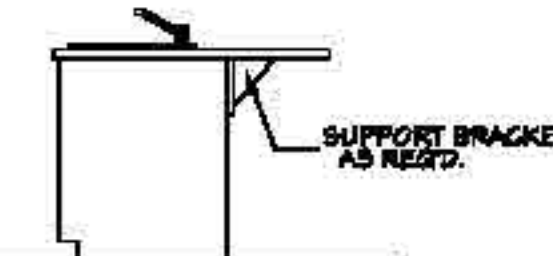

905 KITCHEN
SCALE: 3/8" = 1'-0"

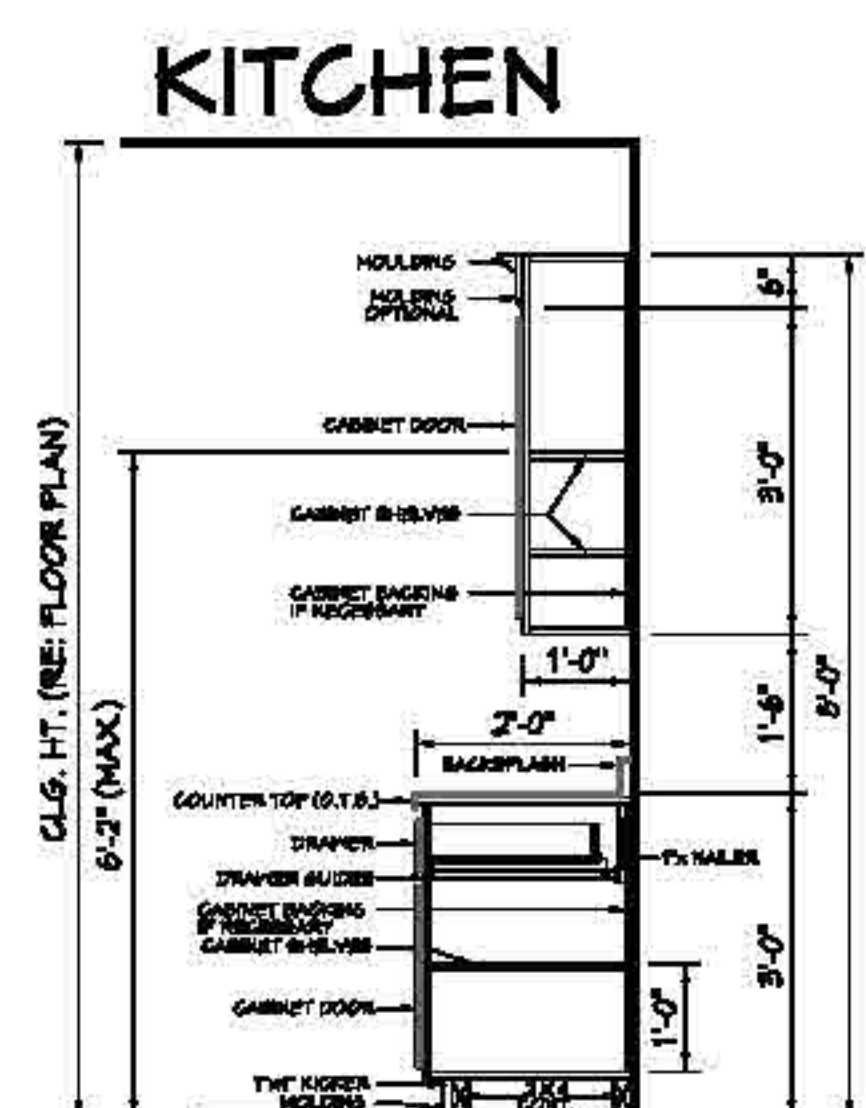

906 TYPICAL CABINET SECTIONS
SCALE: N.T.S.

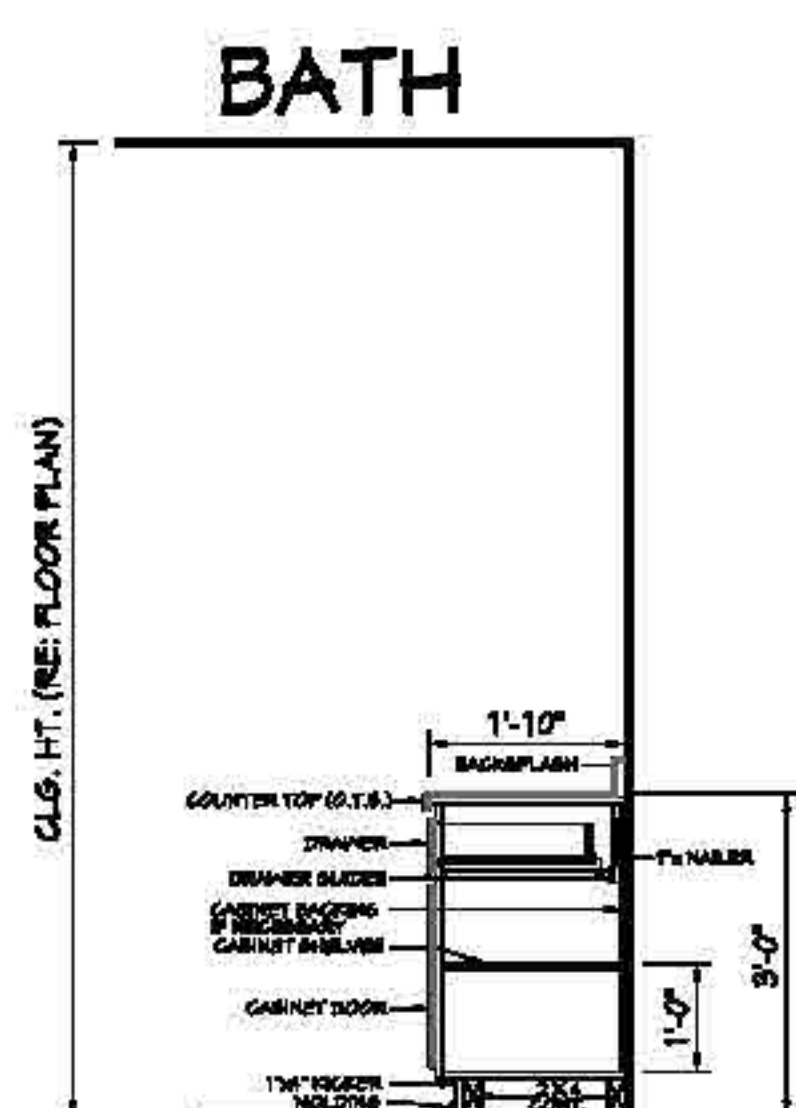


Date: 04.22.20

Drawn By: [Redacted]

© COPYRIGHT
ALL RIGHTS RESERVED

SHEET NUMBER

9

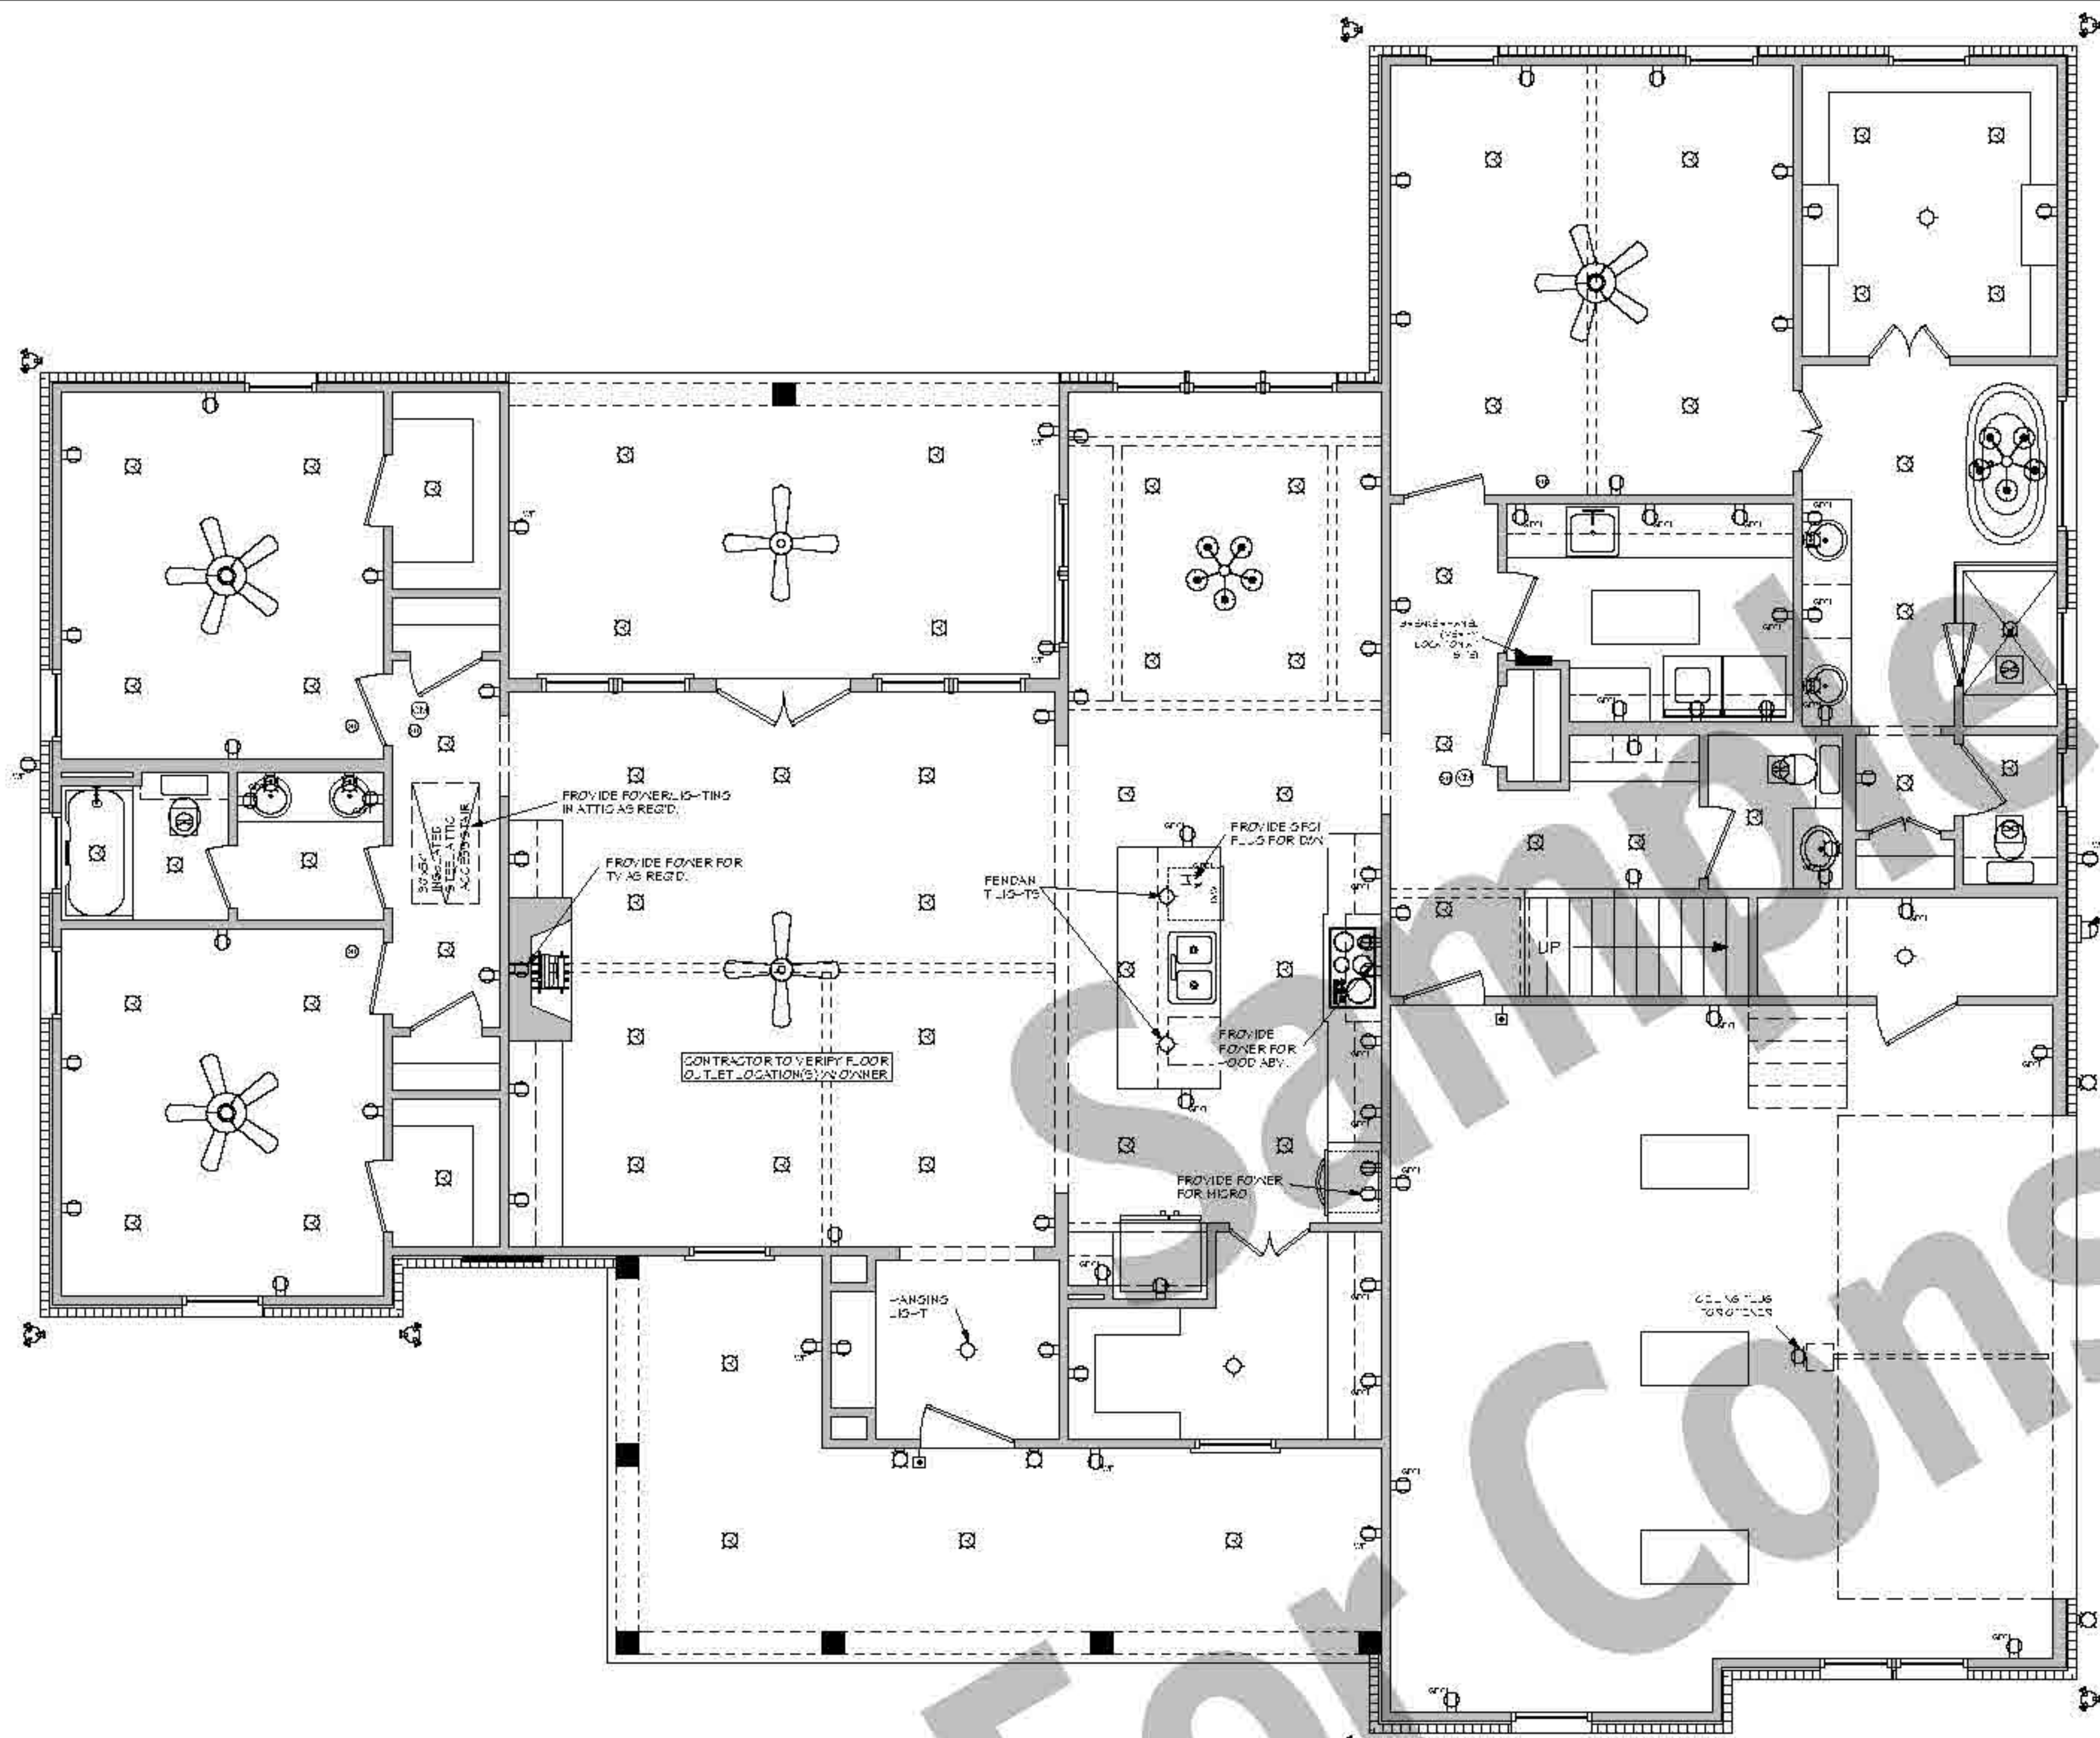


ELECTRICAL PLAN

SCALE: 1/4" = 1'-0"

NOTE: SWITCHES AND ELECTRICAL CONNECTIONS ARE NOT SHOWN. OWNER TO LOCATE THESE ITEMS DURING ELECTRICAL WALK-THROUGH WITH ELECTRICAL CONTRACTOR AT SITE.

ELECTRICAL SYMBOLS LEGEND	
SYMBOL	DESCRIPTION
	110 VOLT OUTLET
	GROUND FAULT PROTECTED OUTLET
	WEATHERPROOF OUTLET
	220 VOLT RECEPTACLE
	FLOOR OUTLET (OWNER TO LOCATE)
	CEILING HUNG FIXTURE
	OVERHANG MOUNTED FLOODLIGHTS
	WALL MOUNTED FLOODLIGHTS
	RECESSED CEILING FIXTURE
	FLUORESCENT LIGHT
	CARBON MONOXIDE DETECTOR
	SMOKE DETECTOR
	SWITCH
	THREE-WAY SWITCH
	WALL MOUNTED LIGHT
	DIMMER SWITCH (OWNER TO LOCATE)
	DOOR ACTIVATED SWITCH
	WEATHERPROOF OUTLET
	CATS NETWORKING JACK (OWNER TO LOCATE)
	TELEPHONE OUTLET (OWNER TO LOCATE)
	TELEVISION OUTLET (OWNER TO LOCATE)
	DOORBELL BUTTON (CONTRACTOR TO LOCATE)
	THERMOSTAT (CONTRACTOR TO LOCATE)
	CEILING EXHAUST FAN, VENT TO EXTERIOR
SYMBOL	DESCRIPTION
	TV SPEAKER
	RADIO SPEAKER
	CEILING FAN ONLY, NO LIGHT KIT
	CEILING FAN WITH LIGHT KIT
	TRACK LIGHTING (OWNER TO LOCATE)
	WALL SCONCE (OWNER TO LOCATE)
	CHANDELIER 1 (O.T.S.)
	CHANDELIER 2 (O.T.S.)
	UNDER COUNTER LIGHTING
	EMERGENCY LIGHTING/EXIT SIGN

- ELECTRICAL NOTES: (2018 IRC)**
1. ALL WORK SHALL COMPLY WITH ALL CODES APPLICABLE AT SITE.
 2. SMOKE ALARMS SHALL BE INSTALLED IN THE FOLLOWING LOCATIONS: EACH SLEEPING ROOM, OUTSIDE EACH SEPARATE SLEEPING AREA IN THE IMMEDIATE VICINITY OF THE BEDROOMS, ON EACH ADDITIONAL STORY OF THE DWELLING, INCLUDING BASEMENTS AND HABITABLE ATTICS. WHEN MORE THAN ONE SMOKE ALARM IS REQUIRED TO BE INSTALLED WITHIN A DWELLING THE ALARM DEVICES SHALL BE INTERCONNECTED IN SUCH A MANNER THAT THE ACTIVATION OF ONE ALARM WILL ACTIVATE ALL OF THE ALARMS IN THE UNIT. SMOKE ALARMS SHALL BE HARD WIRED WITH A BATTERY BACK-UP.
 3. CARBON MONOXIDE ALARMS SHALL BE INSTALLED OUTSIDE OF EACH SEPARATE SLEEPING AREA IN THE IMMEDIATE VICINITY OF THE BEDROOMS IN DWELLING UNITS WITHIN WHICH FIRE-FIRED APPLIANCES ARE INSTALLED AND IN DWELLING UNITS WITH ATTACHED GARAGES.
 4. A 120-VOLT, SINGLE-PHASE, 15-20 AMPERE RATED RECEPTACLE OUTLET SHALL BE INSTALLED AT AN ACCESSIBLE LOCATION FOR THE SERVICES OF HEATING, AIR CONDITIONING AND REFRIGERATION EQUIPMENT. THE RECEPTACLE SHALL BE LOCATED ON THE SAME LEVEL AND WITHIN 25 FEET OF THE EQUIPMENT. THE RECEPTACLE OUTLET SHALL NOT BE CONNECTED TO THE LOAD SIDE OF THE HVAC EQUIPMENT DISCONNECTING MEANS.

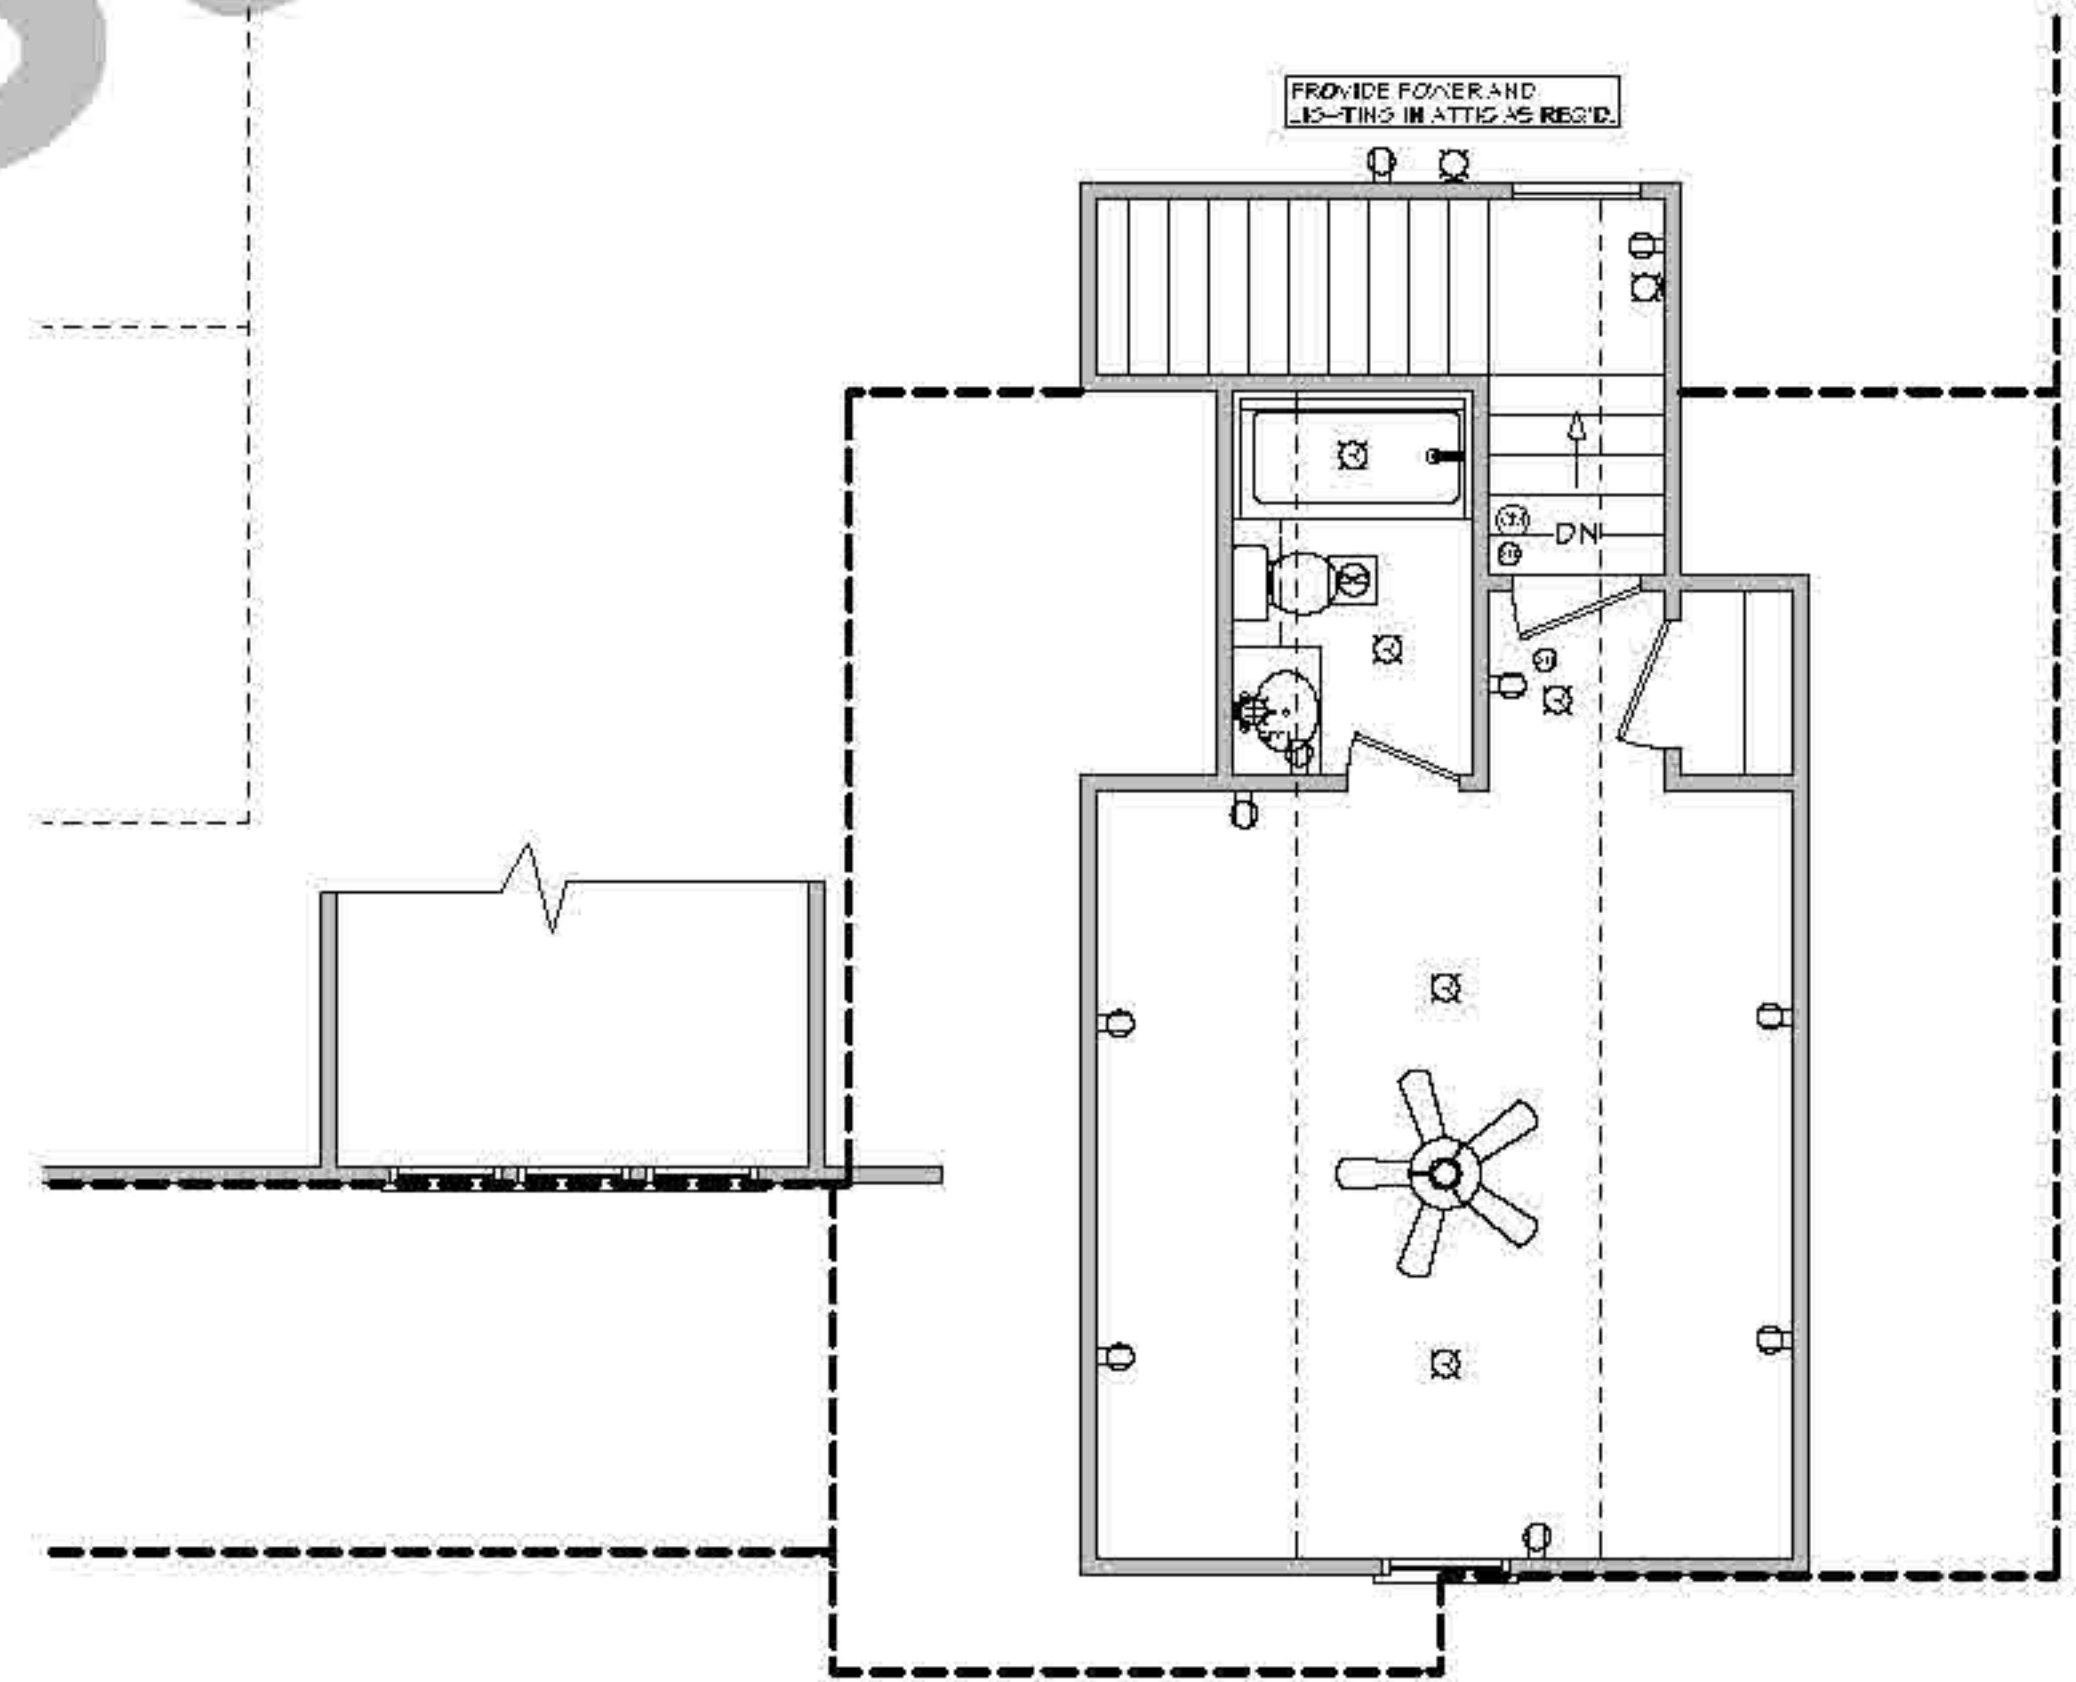

BONUS ELECTRICAL PLAN

SCALE: 1/4" = 1'-0"



Date: 04.22.20

Drawn: [Signature]

© COPYRIGHT ALL RIGHTS RESERVED

10

IMPORTANT DISCLAIMER

THE ENCLOSED INFORMATION IS INTENDED TO ASSIST AND INFORM YOU THROUGH THE CONSTRUCTION OF YOUR HOME. YOUR CONSTRUCTION PLANS HAVE BEEN DRAWN TO PRESCRIBE TO INDUSTRY STANDARDS. THESE PROFESSIONAL STANDARDS DETERMINE HOW CONSTRUCTION PLANS ARE DRAWN AND WHAT INFORMATION THEY INCLUDE. CONSTRUCTION PLANS ARE INTENDED AS A GUIDE TO PROFESSIONAL CONTRACTORS AND ARE NOT INTENDED TO BE A SET OF STEP-BY-STEP INSTRUCTIONS. THEREFORE, IF YOU ARE PLANNING TO BUILD YOUR HOME WITHOUT THE SERVICE OF A PROFESSIONAL BUILDER, WE SUGGEST THAT YOU RECOMMEND THOROUGHLY FAMILIAR WITH READING CONSTRUCTION PLANS OR CONSIDER CONSULTING A CONSTRUCTION SPECIALIST. IF YOU SHOULD HAVE ANY QUESTIONS REGARDING THE CONSTRUCTION PLANS AND/OR THE SUPPORTIVE DOCUMENTATION, PLEASE FEEL FREE TO CONTACT US AT [REDACTED] GREAT CARE AND EFFORT GOES INTO THE CREATION OF THE DESIGN AND ENGINEERING OF YOUR CONSTRUCTION PLANS. HOWEVER, BECAUSE OF THE IMPOSSIBILITY OF PROVIDING ANY PERSONAL AND/OR "ON-SITE" CONSULTATION, SUPERVISION AND CONTROL OVER THE ACTUAL CONSTRUCTION, AND BECAUSE OF THE GREAT VARIANCES IN LOCAL BUILDING CODE REQUIREMENTS AND OTHER LOCATION BUILDING AND WEATHER CONDITIONS, [REDACTED] NOR THE AGENTS OR EMPLOYEES ASSUMES NO RESPONSIBILITY FOR ANY DAMAGES INCLUDING BUT NOT LIMITED TO, ANY DELAYS, OMISSIONS, ERRORS, OR IN THE DESIGN, IN ANY CASE, ANY DISCREPANCIES, ERRORS, AND/OR OMISSIONS IN THE DIMENSIONS, AND/OR DRAWINGS CONTAINED IN THE CONSTRUCTION PLANS SHALL BE BROUGHT TO THE ATTENTION OF [REDACTED] PRIOR TO COMMENCEMENT OF CONSTRUCTION. PROCEEDING WITH CONSTRUCTION CONSTITUTES THE ACCEPTANCE OF THE CONSTRUCTION DOCUMENTS "AS IS" AND ANY DISCREPANCIES, ERRORS, AND/OR OMISSIONS BECOME THE SOLE RESPONSIBILITY OF THE PURCHASER. IF ANY ERRORS ARE DISCOVERED PRIOR TO CONSTRUCTION, [REDACTED] WILL BE GIVEN FULL OPPORTUNITY TO CORRECT ANY ERRORS AND/OR OMISSIONS TO THE CONSTRUCTION PLANS. IN ANY CASE, UNDER ALL CIRCUMSTANCES, THE MAXIMUM FINANCIAL LIABILITY TO [REDACTED] CAN NOT EXCEED THE TOTAL PLAN PURCHASE.

PROFESSIONAL SEAL

THOUGH EVERY EFFORT WAS MADE TO MAKE THE CONSTRUCTION DOCUMENTS FOLLOW THE I.R.C. NATIONAL CODE METHODOLOGIES, A FEW STATES AND CITIES HAVE PASSED BYLAWS REGARDING CONSTRUCTION PLANS THAT WOULD BE SUBJECT TO MUNICIPALITY AND USED FOR THE CONSTRUCTION OF YOUR HOME. THESE BYLAWS REQUIRE THE CONSTRUCTION PLANS TO BE REVIEWED AND/OR PREPARED, INSPECTED, AND SEALED (OR STAMPED) BY A LICENSED ARCHITECT IN YOUR STATE. IT IS ADVISED THAT YOU CONTACT YOUR MUNICIPALITY'S BUILDING DEPARTMENT FOR INSTRUCTIONS TO COMPLY WITH THEIR CONSTRUCTION PLANS REVIEW PROCESS.

COPYRIGHTS

REPRODUCTION OF THESE CONSTRUCTION PLANS, EITHER IN WHOLE OR IN PART, INCLUDING ANY FORM COPYING AND PREPARATION OF A DERIVATIVE WORKS THEREOF, FOR ANY REASON IS STRICTLY PROHIBITED. THE PURCHASE OF A SET OF CONSTRUCTION PLANS IN NO WAY TRANSFERS ANY COPYRIGHT OR OTHER OWNERSHIP INTEREST IN IT TO THE PURCHASER EXCEPT FOR A LIMITED LICENSE TO RELEASE TO USE THE SAID PLAN SET FOR CONSTRUCTING ONE AND ONLY ONE DWELLING UNIT. THE PURCHASE OF AN ADDITIONAL SET OF THE SAID PLANS AT A REDUCED PRICE FROM THE ORIGINAL SET OR AS PART OF A MULTIPLE SET PACKAGE DOES NOT CONVEY TO THE PURCHASER A LICENSE TO CONSTRUCT MORE THAN ONE DWELLING. SIMILARLY, THE PURCHASE OF REPRODUCIBLE CONSTRUCTION PLANS (A.K.A. SEPIAS, MYLARS, OR VELLUMS) CARRIES THE SAME COPYRIGHT PROTECTION AS MENTIONED ABOVE. IT IS GENERALLY ALLOWED TO MAKE A MAXIMUM OF 10 COPIES FOR THE CONSTRUCTION OF A SINGLE DWELLING ONLY. TO USE ANY PLAN MORE THAN ONCE, AND TO AVOID AND COPYRIGHT/LICENCE INFRINGEMENT, IT IS NECESSARY TO CONTACT THE ORIGINAL DESIGNER TO RECEIVE AND LICENSE FOR ANY EXTENDED USAGE. WHEREAS A PURCHASER OF REPRODUCIBLES IS GRANTED A LICENSE TO MAKE COPIES, IT SHOULD BE NOTED THAT AS COPYRIGHTED MATERIALS, MAKING PHOTOCOPIES FROM CONSTRUCTION PLANS IS ILLEGAL. COPYRIGHT AND LICENSE OF CONSTRUCTION PLANS EXISTS TO PROTECT ALL PARTIES. IT RESPECTS AND SUPPORTS THE INTELLECTUAL PROPERTY OF THE ORIGINAL ARCHITECT AND/OR DESIGNER, THEREBY KEEPING IT PROTECTED AND AVAILABLE AT AFFORDABLE PRICES. COPYRIGHT LAW FOR PRE-DRAWN CONSTRUCTION PLANS IS NOW BEING VIGOROUSLY ENFORCED. COPYRIGHT INFRINGEMENT COULD LEAD TO FINES UP TO \$10,000 PER VIOLATION.

GENERAL SITE NOTES

1. CONTRACTOR TO VERIFY LOCATIONS OF SITE UTILITIES, REQUIREMENTS, AND CONNECTIONS FEES. OWNER, CONTRACTOR AND SUB-CONTRACTOR TO PAY ALL OF THESE FEES. THE CONSTRUCTION PERMIT FEES AS AGREED UPON BETWEEN THE OWNER AND CONTRACTOR.
2. BEFORE EXCAVATION, THE CONTRACTOR SHALL EXAMINE ALL DRAWINGS, MAPS, AND BUILDING SITE OF EXISTING FACILITY TO DETERMINE THE ROUTES OF ALL UNDERGROUND UTILITIES. BEFORE DIGGING COMMENCES IT IS ADVISED THAT THE OWNER AND OR CONTRACTOR CALL THEIR STATES UTILITY LOCATOR FACILITY.
3. IT IS RECOMMENDED THAT THE SITE SOIL BE TESTED FOR COMPRESSION RATINGS TO DETERMINE FOUNDATION AND FOOTING DESIGN. CONCRETE FOUNDATIONS AND FOOTING DESIGN SHALL BE IN ACCORDANCE TO CHAPTER 4 OF THE I.R.C. CODE. SEE FOUNDATION SECTION FOR MORE DETAIL.
4. CONSULT A LOCAL CIVIL ENGINEER FOR SITE PLANS AND SURVEYS OF EXISTING PROPERTY. A LANDSCAPE ARCHITECT SHOULD BE CONSULTED FOR MORE EXTENSIVE LANDSCAPE DESIGNS.

CHAPTER 3 :: BUILDING PLANNING

SECTION R304 MINIMUM ROOM AREAS

R304.1 MINIMUM AREA. HABITABLE ROOMS SHALL HAVE A FLOOR AREA OF NOT LESS THAN 70 SQUARE FEET (6.5 M²).
EXCEPTION: KITCHENS.

R304.2 MINIMUM DIMENSIONS. HABITABLE ROOMS SHALL BE NOT LESS THAN 7 FEET (2134 MM) IN ANY HORIZONTAL DIMENSION.
EXCEPTION: KITCHENS.

R304.3 HEIGHT OFF FLOOR AREA. PORTIONS OF A ROOM WITH A SLOPING CEILING MEASURING LESS THAN 6 FEET (1828 MM) OR A FURRED CEILING MEASURING LESS THAN 7 FEET (2134 MM) FROM THE FINISHED CEILING SHALL NOT BE CONSIDERED AS CONTRIBUTING TO THE MINIMUM REQUIRED HABITABLE AREA FOR THAT ROOM.

SECTION R305 CEILING HEIGHT

R305.1 MINIMUM HEIGHT. HABITABLE SPACE, HALLWAYS AND PORTIONS OF BASEMENTS CONTAINING THESE SPACES SHALL HAVE A CEILING HEIGHT OF NOT LESS THAN 7 FEET (2134 MM). BATHROOMS, TOILET ROOMS AND LAUNDRY ROOMS SHALL HAVE A CEILING HEIGHT OF NOT LESS THAN 6 FEET 8 INCHES (2032 MM).
NOTE: SEE SECTION R306.1 FOR EXCEPTIONS.

R305.1.1 BASEMENTS. PORTIONS OF BASEMENTS THAT DO NOT CONTAIN HABITABLE SPACE OR HALLWAYS SHALL HAVE A CEILING HEIGHT OF NOT LESS THAN 6 FEET 4 INCHES (1931 MM) FROM THE FINISHED FLOOR.
EXCEPTION: AT BEAMS, GIRDERS, DUCTS OR OTHER OBSTRUCTIONS, THE CEILING HEIGHT SHALL BE NOT LESS THAN 6 FEET 4 INCHES (1931 MM) FROM THE FINISHED FLOOR.

SECTION R306 SANITATION

R306.1 TOILET FACILITIES. EVERY DWELLING UNIT SHALL BE PROVIDED WITH A WATER CLOSET, LAVATORY, AND A BATHTUB OR SHOWER.

R306.2 KITCHENS. EACH DWELLING UNIT SHALL BE PROVIDED WITH A KITCHEN AREA AND EVERY KITCHEN AREA SHALL BE PROVIDED WITH A SINK.

R306.3 SEWAGE DISPOSAL. PLUMBING FIXTURES SHALL BE CONNECTED TO A SANITARY SEWER OR TO AN APPROVED PRIVATE SEWAGE DISPOSAL SYSTEM.

R306.4 WATER SUPPLY TO FIXTURES. PLUMBING FIXTURES SHALL BE CONNECTED TO AN APPROVED WATER SUPPLY. KITCHEN SINKS, LAVATORIES, BATHTUBS, SHOWERS, BIDDETS, LAUNDRY TUBS AND WASHING MACHINE OUTLETS SHALL BE PROVIDED WITH HOT AND COLD WATER.

SECTION R307 TOILET, BATH, AND SHOWER SPACES

R307.1 SPACE REQUIRED. FIXTURES SHALL BE SPACED IN ACCORDANCE WITH FIGURE R307.1, AND IN ACCORDANCE WITH THE REQUIREMENTS OF SECTION P2708.1.

R307.2 BATHTUB AND SHOWER SPACES. BATHTUB AND SHOWER FLOORS AND WALLS ABOVE BATHTUBS WITH INSTALLED SHOWER HEADS AND IN SHOWER COMPARTMENTS SHALL BE FINISHED WITH A NONABSORBENT SURFACE. SUCH WALL SURFACES SHALL EXTEND TO A HEIGHT OF NOT LESS THAN 8 FEET (2438 MM) ABOVE THE FLOOR.

SECTION R308 GLAZING

R308.1 HAZARDOUS LOCATIONS. THE LOCATIONS SPECIFIED IN SECTIONS R308.1.1 THROUGH R308.4.7 SHALL BE CONSIDERED TO BE SPECIFIC HAZARDOUS LOCATIONS FOR THE PURPOSES OF GLAZING.

R308.1.1 GLAZING IN DOORS. GLAZING IN FIXED OR FOLDABLE PANELS OF SWINGING, SLIDING AND SHOULDER DOORS SHALL BE CONSIDERED TO BE A HAZARDOUS LOCATION.
NOTE: SEE SECTION 308.4.1 FOR EXCEPTIONS.

R308.1.2 GLAZING ADJACENT TO DOORS. GLAZING IN AN INDIVIDUAL FIXED OR OPERABLE PANEL ADJACENT TO A DOOR SHALL BE CONSIDERED TO BE A HAZARDOUS LOCATION WHERE THE BOTTOM EXPOSED EDGE OF THE GLAZING IS LESS THAN 18 INCHES (457 MM) ABOVE THE FLOOR OR WALKING SURFACE AND IT MEETS EITHER OF THE FOLLOWING CONDITIONS:
1. WHERE THE GLAZING IS WITHIN 24 INCHES (610 MM) OF EITHER SIDE OF THE DOOR IN THE PLANE OF THE DOOR IN A CLOSED POSITION.
2. WHERE THE GLAZING IS ON A WALL LESS THAN 180 DEGREES (3.14 RAD) FROM THE PLANE OF THE DOOR IN A CLOSED POSITION AND WITHIN 24 INCHES (610 MM) OF THE HINGE SIDE OF AN INSWINGING DOOR.
EXCEPTIONS:
1. DECORATIVE GLAZING.
2. WHERE THERE IS AN INTERVENING WALL OR OTHER PERMANENT BARRIER BETWEEN THE DOOR AND THE GLAZING.
3. WHERE ACCESS THROUGH THE DOOR IS TO A CLOSET OR STORAGE AREA 3 FEET (914 MM) OR LESS IN DEPTH. GLAZING IN THIS APPLICATION SHALL COMPLY WITH SECTION R308.4.2.
4. GLAZING THAT IS ADJACENT TO THE FIXED PANEL OF PATE DOORS.

R308.1.3 GLAZING IN WINDOWS. GLAZING IN AN INDIVIDUAL FIXED OR OPERABLE PANEL THAT MEETS ALL OF THE FOLLOWING CONDITIONS SHALL BE CONSIDERED TO BE A HAZARDOUS LOCATION:
1. THE EXPOSED AREA OF AN INDIVIDUAL PANEL IS LARGER THAN 8 SQUARE FEET (0.89 M²).
2. THE BOTTOM EDGE OF THE GLAZING IS LESS THAN 18 INCHES (457 MM) ABOVE THE FLOOR.
3. THE TOP EDGE OF THE GLAZING IS MORE THAN 36 INCHES (914 MM) ABOVE THE FLOOR.
4. (914 MM) ABOVE THE FLOOR.
5. ONE OR MORE WALKING SURFACES ARE WITHIN 36 INCHES (914 MM), MEASURED HORIZONTALLY AND IN A STRAIGHT LINE, OF THE GLAZING.
NOTE: SEE SECTION 308.4.1 FOR EXCEPTIONS.

R308.1.4 GLAZING IN GUARDS AND RAILINGS. GLAZING IN GUARDS AND RAILINGS, INCLUDING STRUCTURAL BALUSTER PANELS AND NONSTRUCTURAL INFILL PANELS, REGARDLESS OF AREA OR HEIGHT ABOVE A WALKING SURFACE SHALL BE CONSIDERED TO BE A HAZARDOUS LOCATION.

R308.1.4.1 STRUCTURAL GLASS BALUSTER PANELS. GUARDS WITH STRUCTURAL GLASS BALUSTER PANELS SHALL BE INSTALLED WITH AN ATTACHED TOP RAIL OR HANDRAIL. THE TOP RAIL OR HANDRAIL SHALL BE SUPPORTED BY NOT LESS THAN THREE GLASS BALUSTER PANELS, OR SHALL BE OTHERWISE SUPPORTED TO REMAIN IN PLACE SHOULD ONE GLASS BALUSTER PANEL FAIL.
NOTE: SEE SECTION 308.4.1 FOR EXCEPTIONS.

R308.1.4.2 GLAZING AND WET SURFACES. GLAZING IN WALLS, ENCLOSURES OR FENCES CONTAINING OR FACING HOT TUBS, SPAS, WHIRLPOOLS, SAUNAS, STEAM ROOMS, BATHTUBS, SHOWERS AND INDOOR OR OUTDOOR SWIMMING POOLS WHERE THE BOTTOM EXPOSED EDGE OF THE GLAZING IS LESS THAN 60 INCHES (1524 MM) MEASURED VERTICALLY ABOVE ANY STANDING OR WALKING SURFACE SHALL BE CONSIDERED A HAZARDOUS LOCATION. THIS SHALL APPLY TO SINGLE GLAZING AND ALL PANES IN MULTIPLE GLAZING.
SEE SECTION 308.4.1 FOR EXCEPTIONS.

R309.1 GLAZING ADJACENT TO STAIRS AND RAMPS.

GLAZING WHERE THE BOTTOM EXPOSED EDGE OF THE GLAZING IS LESS THAN 36 INCHES (914 MM) ABOVE THE PLANE OF THE ADJACENT WALKING SURFACE OF STAIRWAYS, LANDINGS BETWEEN FLOORS OF STAIRS AND RAMPS SHALL BE CONSIDERED TO BE A HAZARDOUS LOCATION.
NOTE: SEE SECTION 308.4.1 FOR EXCEPTIONS.

R309.1.7 GLAZING ADJACENT TO THE BOTTOM STAIR LANDING. GLAZING ADJACENT TO THE LANDING AT THE BOTTOM OF A STAIRWAY WHERE THE GLAZING IS LESS THAN 36 INCHES (914 MM) ABOVE THE LANDING AND WITHIN A 60-INCH (1524 MM) HORIZONTAL ARC LESS THAN 180 DEGREES FROM THE BOTTOM TREAD NOSING SHALL BE CONSIDERED TO BE A HAZARDOUS LOCATION.
NOTE: SEE SECTION 308.4.1 FOR EXCEPTIONS.

R309.1.8 GLAZING ADJACENT TO THE BOTTOM STAIR LANDING. GLAZING ADJACENT TO THE LANDING AT THE BOTTOM OF A STAIRWAY WHERE THE GLAZING IS LESS THAN 36 INCHES (914 MM) ABOVE THE LANDING AND WITHIN A 60-INCH (1524 MM) HORIZONTAL ARC LESS THAN 180 DEGREES FROM THE BOTTOM TREAD NOSING SHALL BE CONSIDERED TO BE A HAZARDOUS LOCATION.
NOTE: SEE SECTION 308.4.1 FOR EXCEPTIONS.

R309.1.9 GLAZING ADJACENT TO THE BOTTOM STAIR LANDING. GLAZING ADJACENT TO THE LANDING AT THE BOTTOM OF A STAIRWAY WHERE THE GLAZING IS LESS THAN 36 INCHES (914 MM) ABOVE THE LANDING AND WITHIN A 60-INCH (1524 MM) HORIZONTAL ARC LESS THAN 180 DEGREES FROM THE BOTTOM TREAD NOSING SHALL BE CONSIDERED TO BE A HAZARDOUS LOCATION.
NOTE: SEE SECTION 308.4.1 FOR EXCEPTIONS.

SECTION R309 GARAGES AND CARPORTS

R309.1 FLOOR SURFACE. GARAGE FLOOR SURFACES SHALL BE OF APPROVED NONCOMBUSTIBLE MATERIAL. THE AREA OF FLOOR USED FOR PARKING OF AUTOMOBILES OR OTHER VEHICLES SHALL BE SLOPED TO FACILITATE THE MOVEMENT OF LIQUIDS TO A DRAIN OR TOWARD THE MAIN VEHICLE ENTRY DOORWAY.

R309.2 CARPORTS. CARPORTS SHALL BE OPEN OR NOT LESS THAN TWO SIDES. CARPORT FLOOR SURFACES SHALL BE OF APPROVED NONCOMBUSTIBLE MATERIAL. CARPORTS NOT OPEN ON TWO OR MORE SIDES SHALL BE CONSIDERED TO BE A GARAGE AND SHALL COMPLY WITH THE PROVISIONS OF THIS SECTION FOR GARAGES. THE AREA OF FLOOR USED FOR PARKING OF AUTOMOBILES OR OTHER VEHICLES SHALL BE SLOPED TO FACILITATE THE MOVEMENT OF LIQUIDS TO A DRAIN OR TOWARD THE MAIN VEHICLE ENTRY DOORWAY.
EXCEPTION: ASPHALT SURFACES SHALL BE PERMITTED AT GROUND LEVEL IN CARPORTS.

R309.3 AUTOMATIC GARAGE DOOR OPENERS. AUTOMATIC GARAGE DOOR OPENERS, IF PROVIDED, SHALL BE LISTED AND LABELED IN ACCORDANCE WITH UL 325.

R309.3.1 FIRE SPRINKLERS. PRIVATE GARAGES SHALL BE PROTECTED BY FIRE SPRINKLERS WHERE THE GARAGE WALL HAS BEEN DESIGNED BASED ON TABLE R309.1(2). NOTE: A SPRINKLER IN GARAGES SHALL BE CONNECTED TO AN AUTOMATIC SPRINKLER SYSTEM THAT COMPLES WITH SECTION P2504. GARAGE SPRINKLERS SHALL BE RESIDENTIAL SPRINKLERS OR QUICK-RESPONSE SPRINKLERS, DESIGNED TO PROVIDE A DENSITY OF 0.06 GPM/FT². GARAGE DOORS SHALL NOT BE CONSIDERED OBSTRUCTIONS WITH RESPECT TO SPRINKLER PLACEMENT.

SECTION R310 EMERGENCY ESCAPE AND RESCUE OPENINGS

R310.1 EMERGENCY ESCAPE AND RESCUE OPENING REQUIRED. BASEMENTS, HABITABLE ATTICS AND EVERY SLEEPING ROOM SHALL HAVE NOT LESS THAN ONE OPERABLE EMERGENCY ESCAPE AND RESCUE OPENING. WHERE BASEMENTS CONTAIN ONE OR MORE SLEEPING ROOMS, AN EMERGENCY ESCAPE AND RESCUE OPENING SHALL BE REQUIRED IN EACH SLEEPING ROOM. EMERGENCY ESCAPE AND RESCUE OPENINGS SHALL OPEN DIRECTLY INTO A PUBLIC WAY, OR TO A YARD OR COURT THAT OPENS TO A PUBLIC WAY.
NOTE: SEE SECTION R310.1 FOR EXCEPTIONS.

R310.1.1 OPERATIONAL CONSTRAINTS AND OPENING CONTROL DEVICES. EMERGENCY ESCAPE AND RESCUE OPENINGS SHALL BE OPERATIONAL FROM THE INSIDE OF THE ROOM WITHOUT THE USE OF KEYS, TOOLS OR SPECIAL KNOWLEDGE. WINDOW OPENING CONTROL DEVICES ON WINDOWS SERVING AS A REQUIRED EMERGENCY ESCAPE AND RESCUE OPENING SHALL COMPLY WITH ASTM F2090.

R310.2 EMERGENCY ESCAPE AND RESCUE OPENINGS. EMERGENCY ESCAPE AND RESCUE OPENINGS SHALL HAVE MINIMUM DIMENSIONS AS SPECIFIED IN THIS SECTION.

R310.2.1 MINIMUM OPENING AREA. EMERGENCY ESCAPE AND RESCUE OPENINGS SHALL HAVE A NET CLEAR OPENING OF NOT LESS THAN 5.7 SQUARE FEET (0.53 M²). THE NET CLEAR OPENING DIMENSIONS REQUIRED BY THIS SECTION SHALL BE OBTAINED BY THE NORMAL OPERATION OF THE EMERGENCY ESCAPE AND RESCUE OPENING FROM THE INSIDE. THE NET CLEAR HEIGHT OF THE OPENING SHALL BE NOT LESS THAN 20 INCHES (510 MM) AND THE NET CLEAR WIDTH SHALL BE NOT LESS THAN 20 INCHES (510 MM).

EXCEPTION: GRADE FLOOR OPENINGS OR BELOW-GRADE OPENINGS SHALL HAVE A NET CLEAR OPENING AREA OF NOT LESS THAN 5.7 SQUARE FEET (0.53 M²).

R310.2.2 WINDOW WELL HEIGHT. WHERE A WINDOW IS PROVIDED AS THE EMERGENCY ESCAPE AND RESCUE OPENING, IT SHALL HAVE A WELL HEIGHT OF NOT MORE THAN 44 INCHES (1118 MM) ABOVE THE FLOOR, WHERE THE WELL HEIGHT IS BELOW GRADE, IT SHALL BE PROVIDED WITH A WINDOW WELL IN ACCORDANCE WITH SECTION R310.2.3.

R310.2.3 WINDOW WELLS. THE HORIZONTAL AREA OF THE WINDOW WELL SHALL BE NOT LESS THAN 9 SQUARE FEET (0.83 M²), WITH A HORIZONTAL PROJECTION AND WIDTH OF NOT LESS THAN 36 INCHES (914 MM). THE AREA OF THE WINDOW WELL SHALL ALLOW THE EMERGENCY ESCAPE AND RESCUE OPENING TO BE FULLY OPENED.
SEE SECTION 310.2.3 FOR EXCEPTIONS.

R310.2.3.1 LADDER AND STEPS.

WINDOW WELLS WITH A VERTICAL DEPTH GREATER THAN 44 INCHES (1118 MM) SHALL BE EQUIPPED WITH A PERMANENTLY AFFIXED LADDER OR STEPS USABLE WITH THE WINDOW IN THE FULLY OPEN POSITION. LADDERS OR STEPS REQUIRED BY THIS SECTION SHALL NOT BE REQUIRED TO COMPLY WITH SECTIONS R311.7. LADDERS OR RUNGS SHALL HAVE AN INSIDE WIDTH OF NOT MORE THAN 12 INCHES (305 MM), SHALL PROJECT NOT LESS THAN 3 INCHES (76 MM) FROM THE WALL AND SHALL BE SPACED NOT MORE THAN 18 INCHES (457 MM) ON CENTER VERTICALLY FOR THE FULL HEIGHT OF THE WINDOW WELL.
NOTE: SEE SECTION 310.2.3.2 FOR EXCEPTIONS.

R310.2.3.2 DRAINAGE. WINDOW WELLS SHALL BE DESIGNED FOR PROPER DRAINAGE BY CONNECTING TO THE BUILDING'S FOUNDATION DRAINAGE SYSTEM REQUIRED BY SECTION R406.1 OR BY AN APPROVED ALTERNATIVE METHOD.
NOTE: SEE SECTION 310.2.3.2 FOR EXCEPTIONS.

R310.2.4 EMERGENCY ESCAPE AND RESCUE OPENINGS UNDER DECKS AND PORCHES.

EMERGENCY ESCAPE AND RESCUE OPENINGS INSTALLED UNDER DECKS AND PORCHES SHALL BE FULLY OPERABLE AND PROVIDE A PATH NOT LESS THAN 36 INCHES (914 MM) IN HEIGHT TO A YARD OR COURT.
R310.2.5 REPLACEMENT WINDOWS. REPLACEMENT WINDOWS INSTALLED IN BUILDINGS MEETING THE SCOPE OF THIS CODE SHALL BE EXEMPT FROM THE MAXIMUM SILL HEIGHT REQUIREMENTS OF SECTION R310.2.2, PROVIDED THAT THE REPLACEMENT WINDOW MEETS THE FOLLOWING CONDITIONS:
1. THE REPLACEMENT WINDOW IS THE MANUFACTURER'S LARGEST STANDARD SIZE WINDOW THAT WILL FIT WITHIN THE EXISTING FRAME OR EXISTING ROUGH OPENING. THE REPLACEMENT WINDOW IS OF THE SAME OPERATING STYLE AS THE EXISTING WINDOW OR A STYLE THAT PROVIDES FOR AN EQUAL OR GREATER WINDOW OPENING AREA THAN THE EXISTING WINDOW.
2. THE REPLACEMENT WINDOW IS NOT PART OF A CHANGE OF OCCUPANCY.

R310.3 EMERGENCY ESCAPE AND RESCUE DOORS.

WHERE A DOOR IS PROVIDED AS THE REQUIRED EMERGENCY ESCAPE AND RESCUE OPENING, IT SHALL BE A SIDE-HINGED DOOR OR A BLINDER WHERE THE OPENING IS BELOW THE ADJACENT GRADE. IT SHALL BE PROVIDED WITH AN AREA WELL.
R310.3.1 MINIMUM DOOR OPENING SIZE. THE MINIMUM NET CLEAR HEIGHT OPENING FOR ANY DOOR THAT SERVES AS AN EMERGENCY ESCAPE AND RESCUE OPENING SHALL BE IN ACCORDANCE WITH SECTION R310.2.1.

R310.3.2 AREA WELLS.

AREA WELLS SHALL HAVE A WIDTH OF NOT LESS THAN 36 INCHES (914 MM). THE AREA WELL SHALL BE SIZED TO ALLOW THE EMERGENCY ESCAPE AND RESCUE DOOR TO BE FULLY OPENED.
R310.3.2.1 LADDER AND STEPS. AREA WELLS WITH A VERTICAL DEPTH GREATER THAN 44 INCHES (1118 MM) SHALL BE EQUIPPED WITH A PERMANENTLY AFFIXED LADDER OR STEPS USABLE WITH THE DOOR IN THE FULLY OPEN POSITION. LADDERS OR STEPS REQUIRED BY THIS SECTION SHALL NOT BE REQUIRED TO COMPLY WITH SECTION R311.7. LADDERS OR RUNGS SHALL HAVE AN INSIDE WIDTH OF NOT LESS THAN 12 INCHES (305 MM), SHALL PROJECT NOT LESS THAN 3 INCHES (76 MM) FROM THE WALL AND SHALL BE SPACED NOT MORE THAN 18 INCHES (457 MM) ON CENTER VERTICALLY FOR THE FULL HEIGHT OF THE EXTERIOR STAIRWELL.

R310.3.2.2 DRAINAGE.

AREA WELLS SHALL BE DESIGNED FOR PROPER DRAINAGE BY CONNECTING TO THE BUILDING'S FOUNDATION DRAINAGE SYSTEM REQUIRED BY SECTION R406.1 OR BY AN APPROVED ALTERNATIVE METHOD.
NOTE: SEE SECTION 310.3.2.2 FOR EXCEPTIONS.

R310.3.3 BARS, GRILLES, COVERS AND SCREENS. WHERE BARS, GRILLES, COVERS, SCREENS OR SIMILAR DEVICES ARE PLACED OVER EMERGENCY ESCAPE AND RESCUE OPENINGS, AREA WELLS, OR WINDOW WELLS, THE MINIMUM NET CLEAR OPENING SIZE SHALL COMPLY WITH SECTIONS R310.2.1 THROUGH R310.2.3, AND SUCH DEVICES SHALL BE REMOVABLE OR REMOVABLE FROM THE INSIDE WITHOUT THE USE OF A KEY, TOOL, SPECIAL KNOWLEDGE OR FORCE GREATER THAN THAT REQUIRED FOR THE NORMAL OPERATION OF THE ESCAPE AND RESCUE OPENING.

R310.3.4 DWELLING ADDITIONS.

WHERE DWELLING ADDITIONS CONTAIN SLEEPING ROOMS, AN EMERGENCY ESCAPE AND RESCUE OPENING SHALL BE PROVIDED IN EACH NEW SLEEPING ROOM. WHERE DWELLING ADDITIONS HAVE BASEMENTS, AN EMERGENCY ESCAPE AND RESCUE OPENING SHALL BE PROVIDED IN THE NEW BASEMENT.
NOTE: SEE SECTION 310.5 FOR EXCEPTIONS.

R310.4 ALTERATIONS OR REPAIRS OF EXISTING BASEMENTS. AN EMERGENCY ESCAPE AND RESCUE OPENING IS NOT REQUIRED WHERE EXISTING BASEMENTS UNDERGO ALTERATIONS OR REPAIRS.
NOTE: SEE SECTION 310.5 FOR EXCEPTIONS.

SECTION R311 MEANS OF EGRESS

R311.1 MEANS OF EGRESS. DWELLINGS SHALL BE PROVIDED WITH A MEANS OF EGRESS IN ACCORDANCE WITH THIS SECTION. THE MEANS OF EGRESS SHALL PROVIDE A CONTINUOUS AND UNOBSTRUCTED PATH OF VERTICAL AND HORIZONTAL EGRESS TRAVEL FROM ALL PORTIONS OF THE DWELLING TO THE REQUIRED EGRESS DOOR WITHOUT REQUIRING TRAVEL THROUGH A GARAGE. THE REQUIRED EGRESS DOOR SHALL OPEN DIRECTLY INTO A PUBLIC WAY OR TO A YARD OR COURT THAT OPENS TO A PUBLIC WAY.

R311.2 EGRESS DOOR. NOT LESS THAN ONE EGRESS DOOR SHALL BE PROVIDED FOR EACH DWELLING UNIT. THE EGRESS DOOR SHALL BE SIDE-HINGED, AND SHALL PROVIDE A CLEAR WIDTH OF NOT LESS THAN 32 INCHES (813 MM) WHERE MEASURED BETWEEN THE FACE OF THE DOOR AND THE STOP. WITH THE DOOR OPEN 90 DEGREES (1.57 RAD), THE CLEAR HEIGHT OF THE DOOR OPENING SHALL BE NOT LESS THAN 78 INCHES (1981 MM) IN HEIGHT MEASURED FROM THE TOP OF THE THRESHOLD TO THE BOTTOM OF THE STOP. OTHER DOORS SHALL NOT BE REQUIRED TO COMPLY WITH THESE MINIMUM DIMENSIONS. EGRESS DOORS SHALL BE READILY OPENABLE FROM INSIDE THE DWELLING WITHOUT THE USE OF A KEY OR SPECIAL KNOWLEDGE OR EFFORT.

R311.2.1 EGRESS DOOR. NOT LESS THAN ONE EGRESS DOOR SHALL BE PROVIDED FOR EACH DWELLING UNIT. THE EGRESS DOOR SHALL BE SIDE-HINGED, AND SHALL PROVIDE A CLEAR WIDTH OF NOT LESS THAN 32 INCHES (813 MM) WHERE MEASURED BETWEEN THE FACE OF THE DOOR AND THE STOP. WITH THE DOOR OPEN 90 DEGREES (1.57 RAD), THE CLEAR HEIGHT OF THE DOOR OPENING SHALL BE NOT LESS THAN 78 INCHES (1981 MM) IN HEIGHT MEASURED FROM THE TOP OF THE THRESHOLD TO THE BOTTOM OF THE STOP. OTHER DOORS SHALL NOT BE REQUIRED TO COMPLY WITH THESE MINIMUM DIMENSIONS. EGRESS DOORS SHALL BE READILY OPENABLE FROM INSIDE THE DWELLING WITHOUT THE USE OF A KEY OR SPECIAL KNOWLEDGE OR EFFORT.

R311.2.2 EGRESS DOOR. NOT LESS THAN ONE EGRESS DOOR SHALL BE PROVIDED FOR EACH DWELLING UNIT. THE EGRESS DOOR SHALL BE SIDE-HINGED, AND SHALL PROVIDE A CLEAR WIDTH OF NOT LESS THAN 32 INCHES (813 MM) WHERE MEASURED BETWEEN THE FACE OF THE DOOR AND THE STOP. WITH THE DOOR OPEN 90 DEGREES (1.57 RAD), THE CLEAR HEIGHT OF THE DOOR OPENING SHALL BE NOT LESS THAN 78 INCHES (1981 MM) IN HEIGHT MEASURED FROM THE TOP OF THE THRESHOLD TO THE BOTTOM OF THE STOP. OTHER DOORS SHALL NOT BE REQUIRED TO COMPLY WITH THESE MINIMUM DIMENSIONS. EGRESS DOORS SHALL BE READILY OPENABLE FROM INSIDE THE DWELLING WITHOUT THE USE OF A KEY OR SPECIAL KNOWLEDGE OR EFFORT.

R311.3 FLOORS AND LANDINGS AT EXTERIOR DOORS.

THERE SHALL BE A LANDING OR FLOOR ON EACH SIDE OF EACH EXTERIOR DOOR. THE WIDTH OF EACH LANDING SHALL BE NOT LESS THAN THE DOOR SERVICE.
LANDINGS SHALL HAVE A DIMENSION OF NOT LESS THAN 36 INCHES (914 MM) MEASURED IN THE DIRECTION OF TRAVEL. THE SLOPE AT EXTERIOR LANDINGS SHALL NOT EXCEED 1/4 UNIT VERTICAL IN 12 UNITS HORIZONTAL (2 PERCENT).
NOTE: SEE SECTION 311.3. FOR EXCEPTIONS.

R311.3.1 FLOOR ELEVATIONS AT THE REQUIRED EGRESS DOORS. LANDINGS OR FINISHED FLOORS AT THE REQUIRED EGRESS DOOR SHALL BE NOT MORE THAN 1/2 INCHES (38 MM) LOWER THAN THE TOP OF THE THRESHOLD.
NOTE: SEE SECTION 311.3.1 FOR EXCEPTIONS.

R311.3.2 FLOOR ELEVATIONS AT OTHER EXTERIOR DOORS. DOORS OTHER THAN THE REQUIRED EGRESS DOOR SHALL BE PROVIDED WITH LANDINGS OR FLOORS NOT MORE THAN 7/8 INCHES (198 MM) BELOW THE TOP OF THE THRESHOLD.
NOTE: SEE SECTION 311.3.2 FOR EXCEPTIONS.

R311.3.3 STORM AND SCREEN DOORS. STORM AND SCREEN DOORS SHALL BE PERMITTED TO SWING OVER EXTERIOR STAIRS AND LANDINGS.

R311.4 EXTERIOR EGRESS.

EGRESS FROM HABITABLE LEVELS INCLUDING HABITABLE ATTIC AND BASEMENTS THAT ARE NOT PROVIDED WITH AN EGRESS DOOR IN ACCORDANCE WITH SECTION R311.2 SHALL BE BY A RAMP IN ACCORDANCE WITH SECTION R311.5 OR A STAIRWAY IN ACCORDANCE WITH SECTION R311.7.

R311.5 LANDING, DECK, BALCONY AND STAIR CONSTRUCTION, AND ATTACHMENT. EXTERIOR LANDINGS, DECKS, BALCONIES, STAIRS AND SIMILAR FACILITIES SHALL BE POSITIVELY ANCHORED TO THE PRIMARY STRUCTURE TO RESIST BOTH VERTICAL AND LATERAL FORCES OR SHALL BE DESIGNED TO BE SELF-SUPPORTING. ATTACHMENT SHALL NOT BE ACCOMPLISHED BY USE OF TOWELS OR RAILS SUBJECT TO WITHDRAWAL.

R311.6 HALLWAYS. THE WIDTH OF A HALLWAY SHALL BE NOT LESS THAN 3 FEET (914 MM).

R311.7 STAIRWAYS.

R311.7.1 WIDTH.

STAIRWAYS SHALL BE NOT LESS THAN 36 INCHES (914 MM) IN CLEAR WIDTH AT ALL POINTS ABOVE THE PERMITTED HANDRAIL HEIGHT AND BELOW THE REQUIRED HEADROOM HEIGHT. THE CLEAR WIDTH OF STAIRWAYS AT AND BELOW THE HANDRAIL HEIGHT, INCLUDING TREADS AND LANDINGS, SHALL BE NOT LESS THAN 31 1/2 INCHES (787 MM) WHERE A HANDRAIL IS INSTALLED ON ONE SIDE AND 27 INCHES (686 MM) WHERE HANDRAILS ARE INSTALLED ON BOTH SIDES.
NOTE: SEE SECTION 311.7.1 FOR EXCEPTIONS.

R311.7.2 HEADROOM. THE HEADROOM IN STAIRWAYS SHALL BE NOT LESS THAN 6 FEET 8 INCHES (2032 MM) MEASURED VERTICALLY FROM THE SLOPED LINE ADJOINING THE TREAD NOSING OR FROM THE FLOOR SURFACE OF THE LANDING OR PLATFORM ON THAT PORTION OF THE STAIRWAY.
NOTE: SEE SECTION 311.7.2 FOR EXCEPTIONS.

R311.7.3 VERTICAL RISE. A FLIGHT OF STAIRS SHALL NOT HAVE A VERTICAL RISE LARGER THAN 19 1/2 INCHES (493 MM) BETWEEN FLOOR LEVELS OR LANDINGS.

R311.7.4 WALK-LINE.

THE WALK-LINE ACROSS WINDER TREADS AND LANDINGS SHALL BE CONCENTRIC TO THE TURN AND PARALLEL TO THE DIRECTION OF TRAVEL ENTERING AND EXITING THE TURN. THE WALK-LINE SHALL BE LOCATED 12 INCHES (305 MM) FROM THE INSIDE OF THE TURN. THE 12-INCH (305mm) DIMENSION SHALL BE MEASURED FROM THE WIDEST POINT OF THE CLEAR STAIR WIDTH AT THE WALKING SURFACE. WHERE WINDERS ARE ADJACENT WITHIN A FLIGHT, THE POINT OF THE WIDEST CLEAR STAIR WIDTH OF THE ADJACENT WINDERS SHALL BE USED.

R311.7.5 STAIR TREADS AND RISERS. STAIR TREADS AND RISERS SHALL MEET THE REQUIREMENTS OF THIS SECTION. FOR THE PURPOSES OF THIS SECTION, DIMENSIONS AND DIMENSIONED SURFACES SHALL BE EXCLUSIVE OF CARPETS, RUGS OR RUNNERS.

R311.7.6 RISERS. THE RISER HEIGHT SHALL BE NOT MORE THAN 7 3/4 INCHES (196 MM). THE RISER SHALL BE MEASURED VERTICALLY BETWEEN LEADING EDGES OF THE ADJACENT TREADS. THE GREATEST RISER HEIGHT WITHIN ANY FLIGHT OF STAIRS SHALL NOT EXCEED THE SMALLEST BY MORE THAN 3/8 INCH (9.5 MM). RISERS SHALL BE VERTICAL OR SLOPED FROM THE UNDERSIDE OF THE NOSING OF THE TREAD ABOVE AT AN ANGLE NOT MORE THAN 30 DEGREES (0.52 RAD) FROM THE VERTICAL. AT OPEN RISERS, OPENINGS LOCATED MORE THAN 30 INCHES (762 MM) AW, MEASURED VERTICALLY, TO THE FLOOR OR GRADE BELOW SHALL NOT PERMIT THE PASSAGE OF 4-INCH-DIA (102 MM) SPHERE.
NOTE: SEE SECTION 311.6.1 FOR EXCEPTIONS.

R311.7.6.2 TREADS.

THE TREAD DEPTH SHALL BE NOT LESS THAN 10 INCHES (254 MM). THE TREAD DEPTH SHALL BE MEASURED HORIZONTALLY BETWEEN THE VERTICAL PLANES OF THE FOREMOST PROJECTION OF ADJACENT TREADS AND AT A RIGHT ANGLE TO THE TREADS' LEADING EDGE. THE GREATEST TREAD DEPTH WITHIN ANY FLIGHT OF STAIRS SHALL NOT EXCEED THE SMALLEST BY MORE THAN 3/8 INCH (9.5 MM).

R311.7.6.3 WINDER TREADS. WINDER TREADS SHALL HAVE A TREAD DEPTH OF NOT LESS THAN 10 INCHES (254MM) MEASURED BETWEEN THE VERTICAL PLANES OF THE FOREMOST PROJECTION OF ADJACENT TREADS AT THE INTERSECTIONS WITH THE WALK-LINE. WINDER TREADS SHALL HAVE A TREAD DEPTH OF NOT LESS THAN 6 INCHES (152 MM) AT ANY POINT WITHIN THE CLEAR WIDTH OF THE STAIR. WITHIN ANY FLIGHT OF STAIRS, THE LARGEST WINDER TREAD DEPTH AT THE WALK-LINE SHALL NOT EXCEED THE SMALLEST WINDER TREAD BY MORE THAN 3/8 INCH (9.5 MM). CONSISTENTLY SHAPED WINDERS AT THE WALK-LINE SHALL BE ALLOWED WITHIN THE SAME FLIGHT OF STAIRS AS RECTANGULAR TREADS AND SHALL NOT BE REQUIRED TO BE WITHIN 3/8 INCH (9.5 MM) OF THE RECTANGULAR TREAD DEPTH.

R311.7.6.4 TREADS.

THE TREAD DEPTH SHALL BE NOT LESS THAN 10 INCHES (254 MM). THE TREAD DEPTH SHALL BE MEASURED HORIZONTALLY BETWEEN THE VERTICAL PLANES OF THE FOREMOST PROJECTION OF ADJACENT TREADS AND AT A RIGHT ANGLE TO THE TREADS' LEADING EDGE. THE GREATEST TREAD DEPTH WITHIN ANY FLIGHT OF STAIRS SHALL NOT EXCEED THE SMALLEST BY MORE THAN 3/8 INCH (9.5 MM).

R311.7.6.5 WINDER TREADS. WINDER TREADS SHALL HAVE A TREAD DEPTH OF NOT LESS THAN 10 INCHES (254MM) MEASURED BETWEEN THE VERTICAL PLANES OF THE FOREMOST PROJECTION OF ADJACENT TREADS AT THE INTERSECTIONS WITH THE WALK-LINE. WINDER TREADS SHALL HAVE A TREAD DEPTH OF NOT LESS THAN 6 INCHES (152 MM) AT ANY POINT WITHIN THE CLEAR WIDTH OF THE STAIR. WITHIN ANY FLIGHT OF STAIRS, THE LARGEST WINDER TREAD DEPTH AT THE WALK-LINE SHALL NOT EXCEED THE SMALLEST WINDER TREAD BY MORE THAN 3/8 INCH (9.5 MM). CONSISTENTLY SHAPED WINDERS AT THE WALK-LINE SHALL BE ALLOWED WITHIN THE SAME FLIGHT OF STAIRS AS RECTANGULAR TREADS AND SHALL NOT BE REQUIRED TO BE WITHIN 3/8 INCH (9.5 MM) OF THE RECTANGULAR TREAD DEPTH.

R311.7.6.6 TREADS. THE TREAD DEPTH SHALL BE NOT LESS THAN 10 INCHES (254 MM). THE TREAD DEPTH SHALL BE MEASURED HORIZONTALLY BETWEEN THE VERTICAL PLANES OF THE FOREMOST PROJECTION OF ADJACENT TREADS AND AT A RIGHT ANGLE TO THE TREADS' LEADING EDGE. THE GREATEST TREAD DEPTH WITHIN ANY FLIGHT OF STAIRS SHALL NOT EXCEED THE SMALLEST BY MORE THAN 3/8 INCH (9.5 MM).

R311.7.6.7 TREADS. THE TREAD DEPTH SHALL BE NOT LESS THAN 10 INCHES (254 MM). THE TREAD DEPTH SHALL BE MEASURED HORIZONTALLY BETWEEN THE VERTICAL PLANES OF THE FOREMOST PROJECTION OF ADJACENT TREADS AND AT A RIGHT ANGLE TO THE TREADS' LEADING EDGE. THE GREATEST TREAD DEPTH WITHIN ANY FLIGHT OF STAIRS SHALL NOT EXCEED THE SMALLEST BY MORE THAN 3/8 INCH (9.5 MM).

R311.7.6.8 TREADS.

THE TREAD DEPTH SHALL BE NOT LESS THAN 10 INCHES (254 MM). THE TREAD DEPTH SHALL BE MEASURED HORIZONTALLY BETWEEN THE VERTICAL PLANES OF THE FOREMOST PROJECTION OF ADJACENT TREADS AND AT A RIGHT ANGLE TO THE TREADS' LEADING EDGE. THE GREATEST TREAD DEPTH WITHIN ANY FLIGHT OF STAIRS SHALL NOT EXCEED THE SMALLEST BY MORE THAN 3/8 INCH (9.5 MM).

R311.7.6.9 TREADS. THE TREAD DEPTH SHALL BE NOT LESS THAN 10 INCHES (254 MM). THE TREAD DEPTH SHALL BE MEASURED HORIZONTALLY BETWEEN THE VERTICAL PLANES OF THE FOREMOST PROJECTION OF ADJACENT TREADS AND AT A RIGHT ANGLE TO THE TREADS' LEADING EDGE. THE GREATEST TREAD DEPTH WITHIN ANY FLIGHT OF STAIRS SHALL NOT EXCEED THE SMALLEST BY MORE THAN 3/8 INCH (9.5 MM).

R311.7.6.10 TREADS.

THE TREAD DEPTH SHALL BE NOT LESS THAN 10 INCHES (254 MM). THE TREAD DEPTH SHALL BE MEASURED HORIZONTALLY BETWEEN THE VERTICAL PLANES OF THE FOREMOST PROJECTION OF ADJACENT TREADS AND AT A RIGHT ANGLE TO THE TREADS' LEADING EDGE. THE GREATEST TREAD DEPTH WITHIN ANY FLIGHT OF STAIRS SHALL NOT EXCEED THE SMALLEST BY MORE THAN 3/8 INCH (9.5 MM).

R311.7.6.11 TREADS. THE TREAD DEPTH SHALL BE NOT LESS THAN 10 INCHES (254 MM). THE TREAD DEPTH SHALL BE MEASURED HORIZONTALLY BETWEEN THE VERTICAL PLANES OF THE FOREMOST PROJECTION OF ADJACENT TREADS AND AT A RIGHT ANGLE TO THE TREADS' LEADING EDGE. THE GREATEST TREAD DEPTH WITHIN ANY

R311.8.3 HANDRAILS REQUIRED.
HANDRAILS SHALL BE PROVIDED ON NOT LESS THAN ONE SIDE OF RAMPS EXCEEDING A SLOPE OF ONE UNIT VERTICAL IN 12 UNITS HORIZONTAL (8.33-PERCENT SLOPE).

R311.8.3.1 HEIGHT.
HANDRAIL HEIGHT, MEASURED ABOVE THE FINISHED SURFACE OF THE RAMP, SHALL BE NOT LESS THAN 34 INCHES (864 MM) AND NOT MORE THAN 38 INCHES (965 MM).

R311.8.3.2 GRIP SIZE.
HANDRAILS ON RAMPS SHALL COMPLY WITH SECTION R311.7.8.5.

R311.8.3.5 CONTINUITY.
HANDRAILS WHERE REQUIRED ON RAMPS SHALL BE CONTINUOUS FOR THE FULL LENGTH OF THE RAMP. HANDRAIL ENDS SHALL BE RETURNED OR SHALL TERMINATE IN NEVEL POSTS OR SAFETY TERMINALS. HANDRAILS ADJACENT TO A WALL SHALL HAVE A SPACE OF NOT LESS THAN 1 1/2 INCHES (38 MM) BETWEEN THE WALL AND THE HANDRAILS.

SECTION R312 GUARDS AND WINDOW FALL PROTECTION

R312.1 GUARDS.
GUARDS SHALL BE PROVIDED IN ACCORDANCE WITH SECTIONS R312.1.1 THROUGH R312.1.4.

R312.1.1 WHERE REQUIRED.
GUARDS SHALL BE PROVIDED FOR THOSE PORTIONS OF OPEN-SIDED WALKING SURFACES, INCLUDING STAIRS, RAMPS AND LANDINGS, THAT ARE LOCATED MORE THAN 30 INCHES (762 MM) MEASURED VERTICALLY TO THE FLOOR OR GRADE BELOW AT ANY POINT WITHIN 36 INCHES (914 MM) HORIZONTALLY TO THE EDGE OF THE OPEN SIDE. INSECT SCREENING SHALL NOT BE CONSIDERED AS A GUARD.

R312.1.2 HEIGHT.
REQUIRED GUARDS AT OPEN-SIDED WALKING SURFACES, INCLUDING STAIRS, PORCHES, BALCONIES OR LANDINGS, SHALL BE NOT LESS THAN 36 INCHES (914 MM) IN HEIGHT AS MEASURED VERTICALLY ABOVE THE ADJACENT WALKING SURFACE OR THE LINE CONNECTING THE NOSINGS.

NOTE: SEE SECTION R312.1.2 FOR EXCEPTIONS

R312.1.3 OPENING LIMITATIONS.
REQUIRED GUARDS SHALL NOT HAVE OPENINGS FROM THE WALKING SURFACE TO THE REQUIRED GUARD HEIGHT THAT ALLOW PASSAGE OF A SPHERE 4 INCHES (102 mm) IN DIAMETER.

NOTE: SEE SECTION R312.1.3 FOR EXCEPTIONS

R312.1.4 EXTERIOR PLASTIC COMPOSITE GUARDS.
PLASTIC COMPOSITE EXTERIOR GUARDS SHALL COMPLY WITH THE REQUIREMENTS OF SECTION R317.4.

R312.2 WINDOW FALL PROTECTION.
WINDOW FALL PROTECTION SHALL BE PROVIDED IN ACCORDANCE WITH SECTIONS R312.2.1 AND R312.2.2.

R312.2.1 WINDOW SILL.
IN DWELLING UNITS, WHERE THE TOP OF THE SILL OF AN OPERABLE WINDOW OPENING IS LOCATED LESS THAN 24 INCHES (610 MM) ABOVE THE FINISHED FLOOR AND GREATER THAN 72 INCHES (1828 MM) ABOVE THE FINISHED GRADE OR OTHER SURFACE BELOW ON THE EXTERIOR OF THE BUILDING, THE OPERABLE WINDOW SHALL COMPLY WITH ONE OF THE FOLLOWING:

1. OPERABLE WINDOW OPENINGS WILL NOT ALLOW A 4-INCH-DIAMETER (102 MM) SPHERE TO PASS THROUGH WHERE THE OPENING ARE IN THEIR LARGEST OPEN POSITION.
 2. OPERABLE WINDOWS ARE PROVIDED WITH WINDOW FALL PREVENTION DEVICES THAT COMPLY WITH ASTM F2090.
 3. OPERABLE WINDOWS THAT ARE PROVIDED WITH WINDOW 4. OPENING CONTROL DEVICES THAT COMPLY WITH SECTION R312.2.2.
- R312.2.2 WINDOW OPENING CONTROL DEVICE.**
WINDOW OPENING CONTROL DEVICES SHALL COMPLY WITH ASTM F2090, THE WINDOW OPENING CONTROL DEVICE, AFTER OPERATION TO RELEASE THE CONTROL DEVICE ALLOWING THE WINDOW TO FULLY OPEN, SHALL NOT REDUCE THE NET CLEAR OPENING AREA OF THE WINDOW UNIT TO LESS THAN THE AREA REQUIRED BY SECTION R3102.1.

SECTION R313 AUTOMATIC FIRE SPRINKLER SYSTEMS

R313.1 TOWNHOUSES AUTOMATIC FIRE SPRINKLER SYSTEMS.
AN AUTOMATIC RESIDENTIAL FIRE SPRINKLER SYSTEM SHALL BE INSTALLED IN TOWNHOUSES.

NOTE: SEE SECTION R313.1 FOR EXCEPTION

R313.1.1 DESIGN AND INSTALLATION.
AUTOMATIC RESIDENTIAL FIRE SPRINKLER SYSTEMS FOR TOWNHOUSES SHALL BE DESIGNED AND INSTALLED IN ACCORDANCE WITH SECTION P2004 OR NFPA 13D.

R313.2 ONE- AND TWO-FAMILY DWELLINGS AUTOMATIC FIRE SPRINKLER SYSTEMS.
AUTOMATIC RESIDENTIAL FIRE SPRINKLER SYSTEM SHALL BE INSTALLED IN ONE- AND TWO-FAMILY DWELLINGS.

NOTE: SEE SECTION R313.2 FOR EXCEPTION

R313.2.1 DESIGN AND INSTALLATION.
AUTOMATIC RESIDENTIAL FIRE SPRINKLER SYSTEMS SHALL BE DESIGNED AND INSTALLED IN ACCORDANCE WITH SECTION P2004 OR NFPA 13D.

SECTION R314 SMOKE ALARMS

R314.1 GENERAL.
SMOKE ALARMS SHALL COMPLY WITH NFPA 72 AND SECTION R314.

R314.1.1 LISTINGS.
SMOKE ALARMS SHALL BE LISTED IN ACCORDANCE WITH UL 217, COMBINATION SMOKE AND CARBON MONOXIDE ALARMS SHALL BE LISTED IN ACCORDANCE WITH UL 217 AND UL 2034.

R314.2 WHERE REQUIRED.
SMOKE ALARMS SHALL BE PROVIDED IN ACCORDANCE WITH THIS SECTION.

R314.2.1 NEW CONSTRUCTION.
SMOKE ALARMS SHALL BE PROVIDED IN DWELLING UNITS.

R314.2.2 ALTERATIONS, REPAIRS AND ADDITIONS.
WHERE ALTERATIONS, REPAIRS OR ADDITIONS REQUIRING A PERMIT OCCUR, THE INDIVIDUAL DWELLING UNIT SHALL BE EQUIPPED WITH SMOKE ALARMS LOCATED AS REQUIRED FOR NEW DWELLINGS.

NOTE: SEE SECTION R314.2.2 FOR EXCEPTIONS

R314.3 LOCATION.
SMOKE ALARMS SHALL BE INSTALLED IN THE FOLLOWING LOCATIONS:

1. IN EACH SLEEPING ROOM.
2. OUTSIDE EACH SEPARATE SLEEPING AREA IN THE IMMEDIATE VICINITY OF THE BEDROOMS.
3. ON EACH ADDITIONAL STORY OF THE DWELLING, INCLUDING BASEMENTS AND HABITABLE ATTICS AND NOT INCLUDING CRAWL SPACES AND UNINHABITABLE ATTICS, IN DWELLINGS OR DWELLING UNITS WITH SPLIT LEVELS AND WITHOUT AN INTERVENING DOOR BETWEEN THE ADJACENT LEVELS, A SMOKE ALARM INSTALLED ON THE UPPER LEVEL SHALL SUFFICE FOR THE ADJACENT LOWER LEVEL PROVIDED THAT THE LOWER LEVEL IS LESS THAN ONE FULL STORY BELOW THE UPPER LEVEL.
4. SMOKE ALARMS SHALL BE INSTALLED NOT LESS THAN 3 FEET (914 MM) HORIZONTALLY FROM THE DOOR OR OPENING OF A BATHROOM THAT CONTAINS A BATHTUB OR SHOWER UNLESS THIS WOULD PREVENT PLACEMENT OF A SMOKE ALARM REQUIRED BY THIS SECTION.

R314.3.1 INSTALLATION NEAR COOKING APPLIANCES.
SMOKE ALARMS SHALL NOT BE INSTALLED IN THE FOLLOWING LOCATIONS UNLESS THIS WOULD PREVENT PLACEMENT OF A SMOKE ALARM IN A LOCATION REQUIRED BY SECTION R314.3.

1. IONIZATION SMOKE ALARMS SHALL NOT BE INSTALLED LESS THAN 20 FEET (6096 MM) HORIZONTALLY FROM A PERMANENTLY INSTALLED COOKING APPLIANCE.
2. IONIZATION SMOKE ALARMS WITH AN ALARM-SILENCING SWITCH SHALL NOT BE INSTALLED LESS THAN 10 FEET (3048 mm) HORIZONTALLY FROM A PERMANENTLY INSTALLED COOKING APPLIANCE.
3. PHOTOELECTRIC SMOKE ALARMS SHALL NOT BE INSTALLED LESS THAN 6 FEET (1828 MM) HORIZONTALLY FROM A PERMANENTLY INSTALLED COOKING APPLIANCE.

R314.4 INTERCONNECTION.
WHERE MORE THAN ONE SMOKE ALARM IS REQUIRED TO BE INSTALLED WITHIN AN INDIVIDUAL DWELLING UNIT IN ACCORDANCE WITH SECTION R314.3, THE ALARM DEVICES SHALL BE INTERCONNECTED IN SUCH A MANNER THAT THE ACTUATION OF ONE ALARM WILL ACTIVATE ALL OF THE ALARMS IN THE INDIVIDUAL DWELLING UNIT. PHYSICAL INTERCONNECTION OF SMOKE ALARMS SHALL NOT BE REQUIRED WHERE LISTED WIRELESS ALARMS ARE INSTALLED AND ALL ALARMS SOUND UPON ACTIVATION OF ONE ALARM.

R314.5 COMBINATION ALARMS.
COMBINATION SMOKE AND CARBON MONOXIDE ALARMS SHALL BE PERMITTED TO BE USED IN LIEU OF SMOKE ALARMS.

R314.6 POWER SOURCE.
SMOKE ALARMS SHALL RECEIVE THEIR PRIMARY POWER FROM THE BUILDING WIRING WHERE SUCH WIRING IS SERVED FROM A COMMERCIAL SOURCE AND, WHERE PRIMARY POWER IS INTERRUPTED, SHALL RECEIVE POWER FROM A BATTERY. WIRING SHALL BE PERMANENT AND WITHOUT A DISCONNECTING SWITCH OTHER THAN THOSE REQUIRED FOR OVERCURRENT PROTECTION.

NOTE: SEE SECTION R314.6 FOR EXCEPTIONS

R314.7 FIRE ALARM SYSTEMS.
FIRE ALARM SYSTEMS SHALL BE PERMITTED TO BE USED IN LIEU OF SMOKE ALARMS AND SHALL COMPLY WITH SECTIONS R314.7.1 THROUGH R314.7.4.

SECTION R315 CARBON MONOXIDE ALARMS

R315.1 GENERAL.
CARBON MONOXIDE ALARMS SHALL COMPLY WITH SECTION R315.

R315.1.1 LISTINGS.
CARBON MONOXIDE ALARMS SHALL BE LISTED IN ACCORDANCE WITH UL 2034, COMBINATION CARBON MONOXIDE AND SMOKE ALARMS SHALL BE LISTED IN ACCORDANCE WITH UL 2034 AND UL 217.

R315.2 WHERE REQUIRED.
CARBON MONOXIDE ALARMS SHALL BE PROVIDED IN ACCORDANCE WITH SECTIONS R315.2.1 AND R315.2.2.

R315.2.1 NEW CONSTRUCTION.
FOR NEW CONSTRUCTION, CARBON MONOXIDE ALARMS SHALL BE PROVIDED IN DWELLING UNITS WHERE EITHER OR BOTH OF THE FOLLOWING CONDITIONS EXIST:

1. THE DWELLING UNIT CONTAINS A FUEL-FIRED APPLIANCE.
2. THE DWELLING UNIT HAS AN ATTACHED GARAGE WITH AN OPENING THAT COMMUNICATES WITH THE DWELLING UNIT.

R315.2.2 ALTERATIONS, REPAIRS AND ADDITIONS.
WHERE ALTERATIONS, REPAIRS OR ADDITIONS REQUIRING A PERMIT OCCUR, THE INDIVIDUAL DWELLING UNIT SHALL BE EQUIPPED WITH CARBON MONOXIDE ALARMS LOCATED AS REQUIRED FOR NEW DWELLINGS.

EXCEPTIONS:

NOTE: SEE SECTION R315.2.2 FOR EXCEPTIONS

R315.3 LOCATION.
CARBON MONOXIDE ALARMS IN DWELLING UNITS SHALL BE INSTALLED OUTSIDE OF EACH SEPARATE SLEEPING AREA IN THE IMMEDIATE VICINITY OF THE BEDROOMS. WHERE A FUEL-BURNING APPLIANCE IS LOCATED WITHIN A BEDROOM OR ITS ATTACHED BATHROOM, A CARBON MONOXIDE ALARM SHALL BE INSTALLED WITHIN THE BEDROOM.

R315.4 COMBINATION ALARMS.
COMBINATION CARBON MONOXIDE AND SMOKE ALARMS SHALL BE PERMITTED TO BE USED IN LIEU OF CARBON MONOXIDE ALARMS.

R315.5 INTERCONNECTIVITY.
WHERE MORE THAN ONE CARBON MONOXIDE ALARM IS REQUIRED TO BE INSTALLED WITHIN AN INDIVIDUAL DWELLING UNIT IN ACCORDANCE WITH SECTION R315.3, THE ALARM DEVICES SHALL BE INTERCONNECTED IN SUCH A MANNER THAT THE ACTUATION OF ONE ALARM WILL ACTIVATE ALL OF THE ALARMS IN THE INDIVIDUAL DWELLING UNIT. PHYSICAL INTERCONNECTION OF CARBON MONOXIDE ALARMS SHALL NOT BE REQUIRED WHERE LISTED WIRELESS ALARMS ARE INSTALLED AND ALL ALARMS SOUND UPON ACTIVATION OF ONE ALARM.

NOTE: SEE SECTION R315.5 FOR EXCEPTIONS

R315.6 POWER SOURCE.
CARBON MONOXIDE ALARMS SHALL RECEIVE THEIR PRIMARY POWER FROM THE BUILDING WIRING WHERE SUCH WIRING IS SERVED FROM A COMMERCIAL SOURCE AND, WHERE PRIMARY POWER IS INTERRUPTED, SHALL RECEIVE POWER FROM A BATTERY. WIRING SHALL BE PERMANENT AND WITHOUT A DISCONNECTING SWITCH OTHER THAN THOSE REQUIRED FOR OVERCURRENT PROTECTION.

NOTE: SEE SECTION R315.6 FOR EXCEPTIONS

R315.7 CARBON MONOXIDE DETECTION SYSTEMS.
CARBON MONOXIDE DETECTION SYSTEMS SHALL BE PERMITTED TO BE USED IN LIEU OF CARBON MONOXIDE ALARMS AND SHALL COMPLY WITH SECTIONS R315.7.1 THROUGH R315.7.4.

SECTION R321 ELEVATORS AND PLATFORM LIFTS

R321.1 ELEVATORS.
WHERE PROVIDED, PASSENGER ELEVATORS, LIMITED-USE AND LIMITED-APPLICATION ELEVATORS OR PRIVATE RESIDENCE ELEVATORS SHALL COMPLY WITH ASME A17.1/CSA B44.

SECTION R322 FLOOD-RESISTANT CONSTRUCTION

R322.1 GENERAL.
BUILDINGS AND STRUCTURES CONSTRUCTED IN WHOLE OR IN PART IN FLOOD HAZARD AREAS, INCLUDING A OR V ZONES AND COASTAL A ZONES, AS ESTABLISHED IN TABLE R301.1(1), AND SUBSTANTIAL IMPROVEMENT AND REPAIR OF SUBSTANTIAL DAMAGE OF BUILDINGS AND STRUCTURES IN FLOOD HAZARD AREAS, SHALL BE DESIGNED AND CONSTRUCTED IN ACCORDANCE WITH THE PROVISIONS CONTAINED IN THIS SECTION. BUILDINGS AND STRUCTURES THAT ARE LOCATED IN MORE THAN ONE FLOOD HAZARD AREA SHALL COMPLY WITH THE PROVISIONS APPLICABLE TO THE MOST RESTRICTIVE FLOOD HAZARD AREA. BUILDINGS AND STRUCTURES LOCATED IN WHOLE OR IN PART IN IDENTIFIED FLOODWAYS SHALL BE DESIGNED AND CONSTRUCTED IN ACCORDANCE WITH ABCE 24.

R322.1.2 STRUCTURAL SYSTEMS.
STRUCTURAL SYSTEMS, DRIBBLES AND STRUCTURES SHALL BE DESIGNED, CONNECTED AND ANCHORED TO RESIST FLOATION, COLLAPSE OR PERMANENT LATERAL MOVEMENT DUE TO STRUCTURAL LOADS AND STRESSES FROM FLOODING EQUAL TO THE DESIGN FLOOD ELEVATION.

R322.1.3 FLOOD-RESISTANT CONSTRUCTION.
BUILDINGS AND STRUCTURES ERECTED IN AREAS PRONE TO FLOODING SHALL BE CONSTRUCTED BY METHODS AND PRACTICES THAT MINIMIZE FLOOD DAMAGE.

R322.1.4 ESTABLISHING THE DESIGN FLOOD ELEVATION.
THE DESIGN FLOOD ELEVATION SHALL BE USED TO DEFINE FLOOD HAZARD AREAS AND TO MINIMIZE THE DESIGN FLOOD ELEVATION SHALL BE THE HIGHER OF THE FOLLOWING:

1. THE BASE FLOOD ELEVATION AT THE DEPTH OF PEAK ELEVATION OF FLOODING, INCLUDING WAVE HEIGHT, THAT HAS A 1 PERCENT (100-YEAR FLOOD) OR GREATER CHANCE OF BEING EXCEEDED BY EXCESSIVE SURGE.
2. THE ELEVATION OF THE DESIGN FLOOD ASSOCIATED WITH THE AREA DESIGNATED ON A FLOOD HAZARD MAP ADOPTED BY THE COMMUNITY, OR OTHERWISE LEGALLY DESIGNATED. FOR DETERMINING DESIGN FLOOD ELEVATIONS AND IMPACTS REFER TO SECTIONS R322.1.4.1 AND R322.1.4.2

R322.1.5 LOWEST FLOOR.
THE LOWEST FLOOR SHALL BE THE LOWEST FLOOR OF THE LOWEST ENCLOSED AREA, INCLUDING BASEMENT, AND EXCLUDING ANY UNFINISHED FLOOD-RESISTANT ENCLOSURE THAT IS USABLE SOLELY FOR FUEL PAVING, BUILDING ACCESS OR LIMITED STORAGE PROVIDED THAT SUCH ENCLOSURE IS NOT BUILT SO AS TO RENDER THE BUILDING OR STRUCTURE IN VIOLATION OF THIS SECTION.

R322.1.6 PROTECTION OF MECHANICAL, PLUMBING AND ELECTRICAL SYSTEMS.
ELECTRICAL SYSTEMS, EQUIPMENT AND COMPONENTS, HEATING, VENTILATING, AIR CONDITIONING, PLUMBING APPLIANCES AND PLUMBING FIXTURES, DUCT SYSTEMS, AND OTHER SERVICE EQUIPMENT SHALL BE LOCATED AT OR ABOVE THE ELEVATION REQUIRED IN SECTION R322.2 OR R322.3. IF REPLACED AS PART OF A SUBSTANTIAL IMPROVEMENT, ELECTRICAL SYSTEMS, EQUIPMENT AND COMPONENTS, HEATING, VENTILATING, AIR CONDITIONING AND PLUMBING APPLIANCES AND PLUMBING FIXTURES, DUCT SYSTEMS, AND OTHER SERVICE EQUIPMENT SHALL MEET THE REQUIREMENTS OF THIS SECTION. SYSTEMS, FIXTURES, AND EQUIPMENT AND COMPONENTS SHALL NOT BE MOUNTED ON OR PENETRATE THROUGH WALLS INTENDED TO BREAK AWAY UNDER FLOOD LOADS.

NOTE: SEE SECTION R322.1.6 FOR EXCEPTION

R322.1.7 PROTECTION OF WATER SUPPLY AND SANITARY SEWAGE SYSTEMS.
NEW AND REPLACEMENT WATER SUPPLY SYSTEMS SHALL BE DESIGNED TO MINIMIZE OR ELIMINATE INFILTRATION OF FLOOD WATERS INTO THE SYSTEMS IN ACCORDANCE WITH THE PLUMBING PROVISIONS OF THIS CODE. NEW AND REPLACEMENT SANITARY SEWAGE SYSTEMS SHALL BE DESIGNED TO MINIMIZE OR ELIMINATE INFILTRATION OF FLOODWATERS INTO SYSTEMS AND DISCHARGES FROM SYSTEMS INTO FLOODWATERS IN ACCORDANCE WITH THE PLUMBING PROVISIONS OF THIS CODE AND CHAPTER 3 OF THE INTERNATIONAL PRIVATE SEWAGE DISPOSAL CODE.

R322.2.2 ENCLOSED AREA BELOW DESIGN FLOOD ELEVATION.
ENCLOSED AREAS, INCLUDING CRAWL SPACES, THAT ARE BELOW THE DESIGN FLOOD ELEVATION SHALL:

1. BE SEALED SOLELY FOR PARKING OF VEHICLES, BUILDING ACCESS OR STORAGE.
2. BE PROVIDED WITH FLOOD OPENINGS THAT MEET THE FOLLOWING CRITERIA AND ARE INSTALLED IN ACCORDANCE WITH SECTION R322.2.2.1 SECTIONS 2.1 THROUGH 2.3, AS WELL AS, SECTIONS:

-R322.2.2.1 FOR INSTALLATION OF OPENINGS.
-R322.2.3 FOUNDATION DESIGN AND CONSTRUCTION.
-R322.2.4 TANKS.

REFER TO SECTION R322.3 FOR COASTAL HIGH-HAZARD AREAS INCLUDING V ZONES AND COASTAL A ZONES, WHERE DESIGNATED, INCLUDING:

R322.3.1 LOCATION AND SITE PREPARATION
R322.3.2 ELEVATION REQUIREMENTS
R322.3.3 FOUNDATIONS
R322.3.4 CONSTRUCTION OF SLABS
R322.3.5 WALLS BELOW DESIGN FLOOD ELEVATION
R322.3.6 ENCLOSED AREAS BELOW DESIGN FLOOD ELEVATION.
R322.3.7 STAIRWAYS AND RAMPS
R322.3.8 DECKS AND PORCHES
R322.3.9 CONSTRUCTION DOCUMENTS
R322.3.10 TANKS

SECTION R323 STORM SHELTERS

R323.1 GENERAL.
THIS SECTION APPLIES TO STORM SHELTERS WHERE CONSTRUCTED AS SEPARATE DETACHED BUILDINGS OR WHERE CONSTRUCTED AS SAFE ROOMS WITHIN BUILDINGS FOR THE PURPOSE OF PROVIDING REFUGE FROM STORMS THAT PRODUCE HIGH WINDS, SUCH AS TORNADOES AND HURRICANES. IN ADDITION TO OTHER APPLICABLE REQUIREMENTS IN THIS CODE, STORM SHELTERS SHALL BE CONSTRUCTED IN ACCORDANCE WITH ICC/ANSI-308.

SECTION R326 SWIMMING POOLS, SPAS AND HOT TUBS

R326.1 GENERAL.
THE DESIGN AND CONSTRUCTION OF POOLS AND SPAS SHALL COMPLY

CHAPTER 4 :: FOUNDATIONS

SECTION R401 GENERAL.

R401.1 REQUIREMENTS.
FOUNDATION CONSTRUCTION SHALL BE CAPABLE OF ACCOMMODATING ALL LOADS IN ACCORDANCE WITH SECTION R301 AND OF TRANSMITTING THE RESULTING LOADS TO THE SUPPORTING SOIL. FILL SOILS THAT SUPPORT FOOTINGS AND FOUNDATIONS SHALL BE DESIGNED, INSTALLED AND TESTED IN ACCORDANCE WITH ACCEPTED ENGINEERING PRACTICE.

R401.2 DRAINAGE.
SURFACE DRAINAGE SHALL BE DIVERTED TO A STORM SEWER COLLECTION OR OTHER APPROVED POINT OF COLLECTION THAT DOES NOT CREATE A HAZARD. LOTS SHALL BE GRADED TO DRAIN SURFACE WATER AWAY FROM FOUNDATION WALLS. THE GRADE SHALL FALL NOT FEWER THAN 8 INCHES (192 MM) WITHIN THE FIRST 10 FEET (3048 MM).

NOTE: SEE SECTION R401.2 FOR EXCEPTIONS

R401.3 SOIL TESTS.
WHERE QUANTIFIABLE DATA DERIVED BY ACCEPTED SOIL SCIENCE METHODOLOGIES INDICATE EXPANSIVE SOILS, COMPRESSIBLE SOILS, SHIFTING SOILS, OR OTHER QUESTIONABLE SOIL CHARACTERISTICS ARE LIKELY TO BE PRESENT, THE BUILDING OFFICIAL SHALL DETERMINE WHETHER TO REQUIRE A SOIL TEST TO DETERMINE THE SOIL'S CHARACTERISTICS AT A PARTICULAR LOCATION. THIS TEST SHALL BE DONE BY AN APPROVED AGENCY USING AN APPROVED METHOD.

SECTION R402 MATERIALS

R402.1 WOOD FOUNDATIONS.
WOOD FOUNDATION SYSTEMS SHALL BE DESIGNED AND INSTALLED IN ACCORDANCE WITH THE PROVISIONS OF THIS CODE.

R402.1.1 FASTENERS.
FASTENERS USED BELOW GRADE TO ATTACH PLYWOOD TO THE EXTERIOR SIDE OF EXTERIOR BASEMENT OR DRAIN SPACE WALL, STUDS, OR FASTENERS USED IN KNEE WALL CONSTRUCTION SHALL BE OF TYPE 304 OR 316 STAINLESS STEEL. FASTENERS USED ABOVE GRADE TO ATTACH PLYWOOD AND ALL LUMBER-TOLUMBER FASTENERS EXCEPT THOSE USED IN KNEE WALL CONSTRUCTION SHALL BE OF TYPE 304 OR 316 STAINLESS STEEL, SILICON BRONZE, COPPER, HOT-DIP GALVANIZED (ZINC COATED) STEEL, GALV. OR HOT-DIP GALVANIZED (ZINC COATED) STEEL NAILS, ELECTRO-GALVANIZED STEEL NAILS AND GALVANIZED (ZINC COATED) STEEL STAPLES SHALL NOT BE PERMITTED.

R402.1.2 WOOD TREATMENT.
LUMBER AND PLYWOOD SHALL BE PRESERVE-PRESERVATIVE TREATED AND DRIED AFTER TREATMENT IN ACCORDANCE WITH AWPA 11 (COMMUNITY SPECIFICATION A SPECIAL REQUIREMENT 4.2) AND SHALL BEAR THE LABEL OF AN ACCREDITED AGENCY. WHERE LUMBER OR PLYWOOD IS CUT OR DRILLED AFTER TREATMENT, THE TREATED SURFACE SHALL BE FIELD TREATED WITH COPPER NAPHTHENATE. THE CONCENTRATION OF WHICH SHALL CONTAIN NOT LESS THAN 2-PERCENT COPPER METAL, BY REPEATED BRUSHING, DIPPING OR SOAKING UNTIL THE WOOD CANNOT ABSORB MORE PRESERVATIVE.

R402.2 CONCRETE.
CONCRETE SHALL HAVE A MINIMUM SPECIFIED COMPRESSIVE STRENGTH OF F' OF 3,000 AS SHOWN IN TABLE R402.2. CONCRETE SUBJECT TO MODERATE OR SEVERE WEATHERING AS INDICATED IN TABLE R301.2(1) SHALL BE AIR ENTRAINED AS SPECIFIED IN TABLE R402.2. THE MAXIMUM WEIGHT OF FLY ASH, OTHER POZZOLANS, SILICA FUME, SLAG OR BLENDED CEMENTS THAT IS INCLUDED IN CONCRETE MIXTURES FOR GARAGE FLOOR SLABS AND FOR EXTERIOR PORCHES, CARPORT SLABS AND STEPS THAT WILL BE EXPOSED TO DEICING CHEMICALS SHALL NOT EXCEED THE PERCENTAGES OF THE TOTAL WEIGHT OF CEMENTITIOUS MATERIALS SPECIFIED IN SECTION 19.3.3.4 OF ACI MATERIALS USED TO PRODUCE CONCRETE AND TESTING THEREOF SHALL COMPLY WITH THE APPLICABLE STANDARDS LISTED IN CHAPTERS 19 AND 20 OF ACI 318 OR ACI 302.2.1

SECTION 403 FOOTINGS

R403.1 GENERAL.
ALL EXTERIOR WALLS SHALL BE SUPPORTED ON CONTINUOUS SOLID OR FULLY GROUTED MASONRY OR CONCRETE FOOTINGS, CRUSHED STONE FOOTINGS, WOOD FOUNDATIONS, OR OTHER APPROVED STRUCTURAL SYSTEMS THAT SHALL BE OF SUFFICIENT DESIGN TO ACCOMMODATE ALL LOADS ACCORDING TO SECTION R301 AND TO TRANSMIT THE LOADS TO THE SOIL WITHIN THE LIMITATIONS AS DETERMINED FROM THE CHARACTER OF THE SOIL. FOOTINGS SHALL BE SUPPORTED ON UNDISTURBED NATURAL SOILS OR ENGINEERED FILL. CONCRETE FOOTINGS SHALL BE DESIGNED AND CONSTRUCTED IN ACCORDANCE WITH THE PROVISIONS OF SECTION R403 OR IN ACCORDANCE WITH ACI 302.

R403.1.1 MINIMUM SIZE.
THE MINIMUM WIDTH, W, AND THICKNESS, T, FOR CONCRETE FOOTINGS SHALL BE IN ACCORDANCE WITH TABLES R403.1(1) THROUGH R403.1(8) AND FIGURE R403.1(1) OR R403.1.3, AS APPLICABLE. THE FOOTING WIDTH SHALL BE BASED ON THE LOAD-BEARING VALUE OF THE SOIL IN ACCORDANCE WITH TABLE R403.1.1. FOOTING PROJECTIONS, P, SHALL BE NOT LESS THAN 2 INCHES (51 MM) AND SHALL NOT EXCEED THE THICKNESS OF THE FOOTING. FOOTING THICKNESS AND PROJECTION FOR FIREPLACES SHALL BE IN ACCORDANCE WITH SECTION R1001.2. THE SIZE OF FOOTINGS SUPPORTING PIERES AND COLUMNS SHALL BE BASED ON THE TRIBUTARY LOAD AND ALLOWABLE SOIL PRESSURE IN ACCORDANCE WITH TABLE R401.4.1. FOOTINGS FOR WOOD FOUNDATIONS SHALL BE IN ACCORDANCE WITH THE DETAILS SET FORTH IN SECTION R403.2, AND FIGURES R403.1(2) AND R403.1(3). FOOTINGS FOR PRECAST FOUNDATIONS SHALL BE IN ACCORDANCE WITH THE DETAILS SET FORTH IN SECTION R403.4, TABLE R403.4, AND FIGURES R403.4(1) AND R403.4(2).

REFER TO THESE SECTIONS FOR THE FOLLOWING TOPICS:

- R403.1.2 CONTINUOUS FOOTING IN SEISMIC DESIGN CATEGORIES D1, D1 AND D2.
- R403.1.3 FOOTING AND STEEL WALL REINFORCING IN SEISMIC DESIGN CATEGORIES D0, D1, AND D2.
- R403.1.3.4 INTERIOR REINFORCING AND BRACED WALL PANEL FOOTINGS IN SEISMIC DESIGN CATEGORIES D0, D1 AND D2.
- R403.1.3.5 REINFORCEMENT.
- R403.1.3.6 ISOLATED CONCRETE FOOTINGS.

SECTION 404 FOUNDATION AND RETAINING WALLS

R404.1 CONCRETE AND MASONRY FOUNDATION WALLS.
REFER TO SECTION 404.1 FOR FURTHER SPECIFICATIONS, NOTES AND DESIGN CRITERIA FOR CONCRETE AND MASONRY FOUNDATION WALLS.

R404.2 WOOD FOUNDATION WALLS.
REFER TO SECTION 404.2 FOR FURTHER SPECIFICATIONS, NOTES AND DESIGN CRITERIA FOR WOOD FOUNDATION WALLS.

R404.3 WOOD SILL PLATES.
WOOD SILL PLATES SHALL BE NOT LESS THAN 2-INCH BY 4-INCH (51 MM BY 102 MM) NOMINAL LUMBER. SILL PLATE ANCHORAGE SHALL BE IN ACCORDANCE WITH SECTIONS R403.1.4 AND R403.1.2.

R404.4 CONCRETE AND MASONRY FOUNDATION DAMPPROOFING.
-R404.4.1 CONCRETE AND MASONRY FOUNDATION DAMPPROOFING WATERPROOFING.
-R404.4.2 CONCRETE AND MASONRY FOUNDATION DAMPPROOFING FOR WOOD FOUNDATIONS.
-R404.4.3 PRECAST CONCRETE FOUNDATION SYSTEM DAMPPROOFING.

SECTION R407 COLUMNS

REFER TO SECTION 407 FOR FURTHER SPECIFICATIONS, NOTES AND DESIGN CRITERIA FOR COLUMNS INCLUDING THE FOLLOWING AREAS:

- R407.1 WOOD COLUMN PROTECTION.
- R407.2 STEEL COLUMN PROTECTION.
- R407.3 STRUCTURAL REQUIREMENTS.

SECTION R408 UNDER-FLOOR SPACE

REFER TO SECTION 408 FOR FURTHER SPECIFICATIONS, NOTES AND DESIGN CRITERIA FOR UNDER-FLOOR SPACE INCLUDING THE FOLLOWING AREA:

- R408.1 VENTILATION.
- R408.2 OPENINGS FOR UNDER-FLOOR VENTILATION.
- R408.3 UN-VENTED CRAWL SPACE.
- R408.4 REMOVAL OF DEBRIS.
- R408.5 FINISHED GRADE.
- R408.7 FLOOD RESISTANCE.

CHAPTER 5 :: FLOORS

SECTION R501 GENERAL.

R501.1 APPLICATION.
THE PROVISIONS OF THIS CHAPTER SHALL CONTROL THE DESIGN AND CONSTRUCTION OF THE FLOORS FOR BUILDINGS, INCLUDING THE FLOORS OF ATTIC SPACES USED TO HOUSE MECHANICAL OR PLUMBING FIXTURES AND EQUIPMENT.

R501.2 REQUIREMENTS.
FLOOR CONSTRUCTION SHALL BE CAPABLE OF ACCOMMODATING ALL LOADS IN ACCORDANCE WITH SECTION R301 AND OF TRANSMITTING THE RESULTING LOADS TO THE SUPPORTING STRUCTURAL ELEMENTS.

SECTION R502 WOOD FLOOR FRAMING

R502.1 GENERAL.
WOOD AND WOOD-BASED PRODUCTS USED FOR LOAD-SUPPORTING PURPOSES SHALL CONFORM TO THE APPLICABLE PROVISIONS OF THIS SECTION. SEE SECTIONS R502.1.1 THROUGH R502.1.7 FOR FURTHER SPECIFICATIONS.

R502.2 DESIGN AND CONSTRUCTION.
FLOOR SHALL BE DESIGNED AND CONSTRUCTED IN ACCORDANCE WITH THE PROVISIONS OF THIS CHAPTER, FIGURE R502.2 AND SECTIONS R507 AND R518 OR IN ACCORDANCE WITH ANSI AWG NDS. SEE SECTIONS 602.2.1 THROUGH 602.2.2 FOR FURTHER SPECIFICATIONS.

R502.3 ALLOWABLE JOINT SPANS.
SPANS FOR FLOOR JOISTS SHALL BE IN ACCORDANCE WITH TABLES R502.3.1(1) AND R502.3.1(2). FOR OTHER GRADES AND SPECIES AND FOR OTHER LOADING CONDITIONS, REFER TO THE AWG STJR. SEE SECTIONS 602.3.1 THROUGH 602.3.3 FOR FURTHER SPECIFICATIONS.

R502.4 JOISTS UNDER BEARING PARTITIONS.
JOISTS UNDER PARALLEL BEARING PARTITIONS SHALL BE OF ADEQUATE SIZE TO SUPPORT THE LOAD. DOUBLE JOISTS, SIZED TO ADEQUATELY SUPPORT THE LOAD, THAT ARE SEPARATED TO PERMIT THE INSTALLATION OF PIPING OR VENTS SHALL BE FULL DEPTH SOLID BLOCKED WITH LUMBER NOT LESS THAN 2 INCHES (51 MM) NOMINAL THICKNESS SPACED NOT MORE THAN 4 FEET (1219 MM) ON CENTER. BEARING PARTITIONS PERPENDICULAR TO JOISTS SHALL NOT BE OFFSET FROM SUPPORTING GIRDERS. WALLS OR PARTITIONS MORE THAN THE JOIST DEPTH UNLESS SUCH JOISTS ARE OF SUFFICIENT SIZE TO CARRY THE ADDITIONAL LOAD.

SECTION R501 GENERAL.

R501.1 APPLICATION.
THE PROVISIONS OF THIS CHAPTER SHALL CONTROL THE DESIGN AND CONSTRUCTION OF THE FLOORS FOR BUILDINGS, INCLUDING THE FLOORS OF ATTIC SPACES USED TO HOUSE MECHANICAL OR PLUMBING FIXTURES AND EQUIPMENT.

R501.2 REQUIREMENTS.
FLOOR CONSTRUCTION SHALL BE CAPABLE OF ACCOMMODATING ALL LOADS IN ACCORDANCE WITH SECTION R301 AND OF TRANSMITTING THE RESULTING LOADS TO THE SUPPORTING STRUCTURAL ELEMENTS.

SECTION R502 WOOD FLOOR FRAMING

R502.1 GENERAL.
WOOD AND WOOD-BASED PRODUCTS USED FOR LOAD-SUPPORTING PURPOSES SHALL CONFORM TO THE APPLICABLE PROVISIONS OF THIS SECTION. SEE SECTIONS R502.1.1 THROUGH R502.1.7 FOR FURTHER SPECIFICATIONS.

R502.2 DESIGN AND CONSTRUCTION.
FLOOR SHALL BE DESIGNED AND CONSTRUCTED IN ACCORDANCE WITH THE PROVISIONS OF THIS CHAPTER, FIGURE R502.2 AND SECTIONS R507 AND R518 OR IN ACCORDANCE WITH ANSI AWG NDS. SEE SECTIONS 602.2.1 THROUGH 602.2.2 FOR FURTHER SPECIFICATIONS.

R502.3 ALLOWABLE JOINT SPANS.
SPANS FOR FLOOR JOISTS SHALL BE IN ACCORDANCE WITH TABLES R502.3.1(1) AND R502.3.1(2). FOR OTHER GRADES AND SPECIES AND FOR OTHER LOADING CONDITIONS, REFER TO THE AWG STJR. SEE SECTIONS 602.3.1 THROUGH 602.3.3 FOR FURTHER SPECIFICATIONS.

R502.4 JOISTS UNDER BEARING PARTITIONS.
JOISTS UNDER PARALLEL BEARING PARTITIONS SHALL BE OF ADEQUATE SIZE TO SUPPORT THE LOAD. DOUBLE JOISTS, SIZED TO ADEQUATELY SUPPORT THE LOAD, THAT ARE SEPARATED TO PERMIT THE INSTALLATION OF PIPING OR VENTS SHALL BE FULL DEPTH SOLID BLOCKED WITH LUMBER NOT LESS THAN 2 INCHES (51 MM) NOMINAL THICKNESS SPACED NOT MORE THAN 4 FEET (1219 MM) ON CENTER. BEARING PARTITIONS PERPENDICULAR TO JOISTS SHALL NOT BE OFFSET FROM SUPPORTING GIRDERS. WALLS OR PARTITIONS MORE THAN THE JOIST DEPTH UNLESS SUCH JOISTS ARE OF SUFFICIENT SIZE TO CARRY THE ADDITIONAL LOAD.

SECTION R503 CONCRETE FOUNDATION AND RETAINING WALLS

R503.1 CONCRETE AND MASONRY FOUNDATION WALLS.
REFER TO SECTION 404.1 FOR FURTHER SPECIFICATIONS, NOTES AND DESIGN CRITERIA FOR CONCRETE AND MASONRY FOUNDATION WALLS.

R503.2 WOOD FOUNDATION WALLS.
REFER TO SECTION 404.2 FOR FURTHER SPECIFICATIONS, NOTES AND DESIGN CRITERIA FOR WOOD FOUNDATION WALLS.

R503.3 WOOD SILL PLATES.
WOOD SILL PLATES SHALL BE NOT LESS THAN 2-INCH BY 4-INCH (51 MM BY 102 MM) NOMINAL LUMBER. SILL PLATE ANCHORAGE SHALL BE IN ACCORDANCE WITH SECTIONS R403.1.4 AND R403.1.2.

SECTION R504 DAMPPROOFING

R504.1 CONCRETE AND MASONRY FOUNDATION DAMPPROOFING.
-R504.1.1 CONCRETE AND MASONRY FOUNDATION DAMPPROOFING WATERPROOFING.
-R504.1.2 CONCRETE AND MASONRY FOUNDATION DAMPPROOFING FOR WOOD FOUNDATIONS.
-R504.1.3 PRECAST CONCRETE FOUNDATION SYSTEM DAMPPROOFING.

SECTION R507 COLUMNS

REFER TO SECTION 407 FOR FURTHER SPECIFICATIONS, NOTES AND DESIGN CRITERIA FOR COLUMNS INCLUDING THE FOLLOWING AREAS:

- R507.1 WOOD COLUMN PROTECTION.
- R507.2 STEEL COLUMN PROTECTION.
- R507.3 STRUCTURAL REQUIREMENTS.

SECTION R508 UNDER-FLOOR SPACE

REFER TO SECTION 408 FOR FURTHER SPECIFICATIONS, NOTES AND DESIGN CRITERIA FOR UNDER-FLOOR SPACE INCLUDING THE FOLLOWING AREA:

- R508.1 VENTILATION.
- R508.2 OPENINGS FOR UNDER-FLOOR VENTILATION.
- R508.3 UN-VENTED CRAWL SPACE.
- R508.4 REMOVAL OF DEBRIS.
- R508.5 FINISHED GRADE.
- R508.7 FLOOD RESISTANCE.

SECTION R509 AUTOMATIC FIRE SPRINKLER SYSTEMS

R509.1 TOWNHOUSES AUTOMATIC FIRE SPRINKLER SYSTEMS.
AN AUTOMATIC RESIDENTIAL FIRE SPRINKLER SYSTEM SHALL BE INSTALLED IN TOWNHOUSES.

NOTE: SEE SECTION R509.1 FOR EXCEPTION

R509.1.1 DESIGN AND INSTALLATION.
AUTOMATIC RESIDENTIAL FIRE SPRINKLER SYSTEMS FOR TOWNHOUSES SHALL BE DESIGNED AND INSTALLED IN ACCORDANCE WITH SECTION P2004 OR NFPA 13D.

R509.1.2 ONE- AND TWO-FAMILY DWELLINGS AUTOMATIC FIRE SPRINKLER SYSTEMS.
AUTOMATIC RESIDENTIAL FIRE SPRINKLER SYSTEM SHALL BE INSTALLED IN ONE- AND TWO-FAMILY DWELLINGS.

NOTE: SEE SECTION R509.2 FOR EXCEPTION

R509.2.1 DESIGN AND INSTALLATION.
AUTOMATIC RESIDENTIAL FIRE SPRINKLER SYSTEMS SHALL BE DESIGNED AND INSTALLED IN ACCORDANCE WITH SECTION P2004 OR NFPA 13D.

R404.4 RETAINING WALLS.
RETAINING WALLS THAT ARE NOT LATERALLY SUPPORTED AT THE TOP AND THAT RETAIN IN EXCESS OF 48 INCHES (1219 MM) OF UNBALANCED FILL, OR RETAINING WALLS EXCEEDING 24 INCHES (610 MM) IN HEIGHT THAT RESIST LATERAL LOADS IN ADDITION TO SOIL, SHALL BE DESIGNED IN ACCORDANCE WITH ACCEPTED ENGINEERING PRACTICE TO ENSURE STABILITY AGAINST OVERTURNING, SLIDING, EXCESSIVE FOUNDATION PRESSURE AND WATER UPLIFT. RETAINING WALLS SHALL BE DESIGNED FOR A SAFETY FACTOR OF 1.5 AGAINST LATERAL SLIDING AND OVERTURNING. THIS SECTION SHALL NOT APPLY TO FOUNDATION WALLS SUPPORTING BUILDINGS.

R404.5 PRECAST CONCRETE FOUNDATION WALLS.
REFER TO SECTION 404.5 FOR FURTHER SPECIFICATIONS, NOTES AND DESIGN CRITERIA FOR PRECAST CONCRETE FOUNDATION WALLS.

SECTION R405 FOUNDATION DRAINAGE

R405.1 CONCRETE OR MASONRY FOUNDATIONS.
DRAINS SHALL BE PROVIDED AROUND CONCRETE OR MASONRY FOUNDATIONS THAT RETAIN EARTH AND ENCLOSE HABITABLE OR USABLE SPACES LOCATED BELOW GRADE. DRAINAGE TILES, GRAVEL OR CRUSHED STONE DRAINS, PERFORATED PIPE OR OTHER APPROVED SYSTEMS OR MATERIALS SHALL BE INSTALLED AT OR BELOW THE TOP OF THE FOOTING OR BELOW THE BOTTOM OF THE SLAB AND SHALL DISCHARGE BY GRAVITY OR MECHANICAL MEANS INTO AN APPROVED DRAINAGE SYSTEM. GRAVEL OR CRUSHED STONE DRAINS SHALL EXTEND NOT LESS THAN 1 FOOT (305 MM) BEYOND THE OUTSIDE EDGE OF THE FOOTING AND 8 INCHES (192 MM) ABOVE THE TOP OF THE FOOTING AND BE COVERED WITH AN APPROVED FILTER MEMBRANE LATERAL. THE TOP OF OPEN JOINTS OF DRAIN TILES SHALL BE PROTECTED WITH STRIPS OF BUILDING PAPER, EXCEPT WHERE OTHERWISE RECOMMENDED BY THE DRAIN MANUFACTURER, PERFORATED DRAINS SHALL BE SURROUNDED WITH AN APPROVED FILTER MEMBRANE OR THE FILTER MEMBRANE SHALL COVER THE WASHED GRAVEL OR CRUSHED ROCK COVERING THE DRAIN. DRAINAGE TILE OR PERFORATED PIPE SHALL BE PLACED ON NOT LESS THAN 2 INCHES (51 MM) OF WASHED GRAVEL OR CRUSHED ROCK NOT LESS THAN ONE SIEVE SIZE LARGER THAN THE TILE JOINT OPENING OR PERFORATION AND COVERED WITH NOT LESS THAN 8 INCHES (192 MM) OF THE SAME MATERIAL.

REFER TO SECTION 404.5 FOR FURTHER SPECIFICATIONS, NOTES AND DESIGN CRITERIA FOR PRECAST CONCRETE FOUNDATION WALLS.

SECTION R406 FOUNDATION WATER-PROOFING AND DAMPPROOFING

REFER TO SECTION 406 FOR FURTHER SPECIFICATIONS, NOTES AND DESIGN CRITERIA FOR WATER-PROOFING AND DAMPPROOFING FOUNDATIONS INCLUDING THE FOLLOWING AREAS:

- R406.1 CONCRETE AND MASONRY FOUNDATION DAMPPROOFING WATERPROOFING.
- R406.2 CONCRETE AND MASONRY FOUNDATION DAMPPROOFING FOR WOOD FOUNDATIONS.
- R406.3 PRECAST CONCRETE FOUNDATION SYSTEM DAMPPROOFING.

SECTION R407 COLUMNS

REFER TO SECTION 407 FOR FURTHER SPECIFICATIONS, NOTES AND DESIGN CRITERIA FOR COLUMNS INCLUDING THE FOLLOWING AREAS:

- R407.1 WOOD COLUMN PROTECTION.
- R407

R002.2 ALLOWABLE GIRDER AND HEADER SPANS.
THE ALLOWABLE SPANS OF GIRDERS AND HEADERS FABRICATED OF DIMENSION LUMBER SHALL NOT EXCEED THE VALUES SET FORTH IN TABLES R002.2(1), R002.2(2) AND R002.2(3).

R002.3 BEARING.
THE ENDS OF EACH JOIST, BEAM OR GIRDER SHALL HAVE NOT LESS THAN 1 1/2 INCHES (38 MM) OF BEARING ON WOOD OR METAL, NOT LESS THAN 3 INCHES (76 MM) OF BEARING ON MASONRY OR CONCRETE OR BE SUPPORTED BY APPROVED JOIST HANGERS. ALTERNATIVELY, THE ENDS OF JOISTS SHALL BE SUPPORTED ON A 1-INCH BY 4-INCH (25 MM BY 102 MM) RIBBON STRIP AND SHALL BE NAILLED TO THE ADJACENT STUD. THE BEARING ON MASONRY OR CONCRETE SHALL BE DIRECT, OR A SILL PLATE OF 2-INCH-NOMINAL (51 MM) NOMINAL THICKNESS SHALL BE PROVIDED UNDER THE JOIST. BEAM OR GIRDER, THE SILL PLATE SHALL PROVIDE A MINIMUM NOMINAL BEARING AREA OF 48 SQUARE INCHES (30 696 MM²). SEE SECTIONS R002.3.1 THROUGH R002.3.2 FOR FURTHER SPECIFICATIONS.

REFER TO THE IRC FOR FURTHER INFORMATION ON THE FOLLOWING AREAS:

- R002.7 LATERAL RESTRAINT AT SUPPORTS.
- R002.8 CUTTING, DRILLING AND NOTCHING.
- R002.9 FASTENING.
- R002.10 PROHIBITION OF OPENINGS.
- R002.11 WOOD TRUSSES.
- R002.12 DRAFTSTOPPING REQUIRED.
- R002.15 PRELIMINARY REQUIRED.

REFER TO THE IRC FOR THE FOLLOWING SECTIONS:

SECTION R03 FLOOR SHEATHING
SECTION R04 PRESERVE PRESERVATIVE TREATED WOOD FLOORS
SECTION R06 COLD-FORMED STEEL FLOOR FRAMING

SECTION R506 CONCRETE FLOORS (ON GROUND)

R006.1 GENERAL.
CONCRETE SLAB-ON-GROUND FLOORS SHALL BE DESIGNED AND CONSTRUCTED IN ACCORDANCE WITH THE PROVISIONS OF THIS SECTION OR AC 302. FLOORS SHALL BE A MINIMUM 4 1/2 INCHES (89 MM) THICK FOR EXPANSIVE SOILS, SEE SECTION R043.1.8, THE SPECIFIED COMPRESSIVE STRENGTH OF CONCRETE SHALL BE AS SET FORTH IN SECTION R042.2.

R006.2 SITE PREPARATION.
THE AREA WITHIN THE FOUNDATION WALLS SHALL HAVE ALL VEGETATION, TOP SOIL AND FOREIGN MATERIAL REMOVED.

R006.2.1 FILL.
FILL MATERIAL SHALL BE FREE OF VEGETATION AND FOREIGN MATERIAL. THE FILL SHALL BE COMPACTED TO ENSURE UNIFORM SUPPORT OF THE SLAB, AND EXCEPT WHERE APPROVED, THE FILL DEPTHS SHALL NOT EXCEED 24 INCHES (610 MM) FOR CLEAN SAND OR GRAVEL, AND 8 INCHES (203 MM) FOR EARTH.

R006.2.2 BARE.
A 4-INCH-THICK (102 MM) BASE COURSE CONSISTING OF CLEAN GRADED SAND, GRAVEL, CRUSHED STONE, CRUSHED CONCRETE OR CRUSHED BLAST-FURNACE SLAG PASSING A 3/4-INCH (21 MM) SIEVE SHALL BE PLACED ON THE PREPARED SUBGRADE WHERE THE SLAB IS BELOW GRADE.

NOTE: SEE SECTION R006.2.2 FOR EXCEPTION

R006.2.3 VAPOR RETARDER.
A 6-MIL (0.008 INCH) (152 MM) POLYETHYLENE OR APPROVED VAPOR RETARDER WITH JOINTS LAPPED NOT LESS THAN 6 INCHES (152 MM) SHALL BE PLACED BETWEEN THE CONCRETE FLOOR SLAB AND THE BASE COURSE OR THE PREPARED SUBGRADE WHERE A BASE COURSE DOES NOT EXIST.

NOTE: SEE SECTION R006.2.3 FOR EXCEPTIONS

R006.2.4 REINFORCEMENT SUPPORT.
WHERE PROVIDED IN SLAB-ON-GROUND, REINFORCEMENT SHALL BE SUPPORTED TO REMAIN IN PLACE FROM THE CENTER TO UPPER ONE-THIRD OF THE SLAB FOR THE DURATION OF THE CONCRETE PLACEMENT.

SECTION R307 DECKS

R307.1 DECKS.
WOOD-FRAMED DECKS SHALL BE IN ACCORDANCE WITH THIS SECTION. FOR DECKS USING MATERIALS AND CONDITIONS NOT PRESCRIBED IN THIS SECTION, REFER TO SECTION R301.

R307.2 MATERIALS.
MATERIALS USED FOR THE CONSTRUCTION OF DECKS SHALL COMPLY WITH THIS SECTION.

R307.2.1 WOOD MATERIALS.
WOOD MATERIALS SHALL BE NO. 2 GRADE OR BETTER LUMBER, PRESERVATIVE-TREATED IN ACCORDANCE WITH SECTION R317, OR APPROVED, NATURALLY DURABLE LUMBER, AND TERTIARY PROTECTED WHERE REQUIRED IN ACCORDANCE WITH SECTION R318. WHERE DESIGN IN ACCORDANCE WITH SECTION R301 IS PROVIDED, WOOD STRUCTURAL MEMBERS SHALL BE DESIGNED USING THE WET SERVICE FACTOR DEFINED IN AWC NDS, CUTS, NOTCHES, AND DRILLED HOLES OF PRESERVATIVE TREATED WOOD MEMBERS SHALL BE TREATED IN ACCORDANCE WITH SECTION R317.1.1. ALL PRESERVATIVE-TREATED WOOD PRODUCTS IN CONTACT WITH THE GROUND SHALL BE LABELED FOR SUCH USAGE.

R307.2.1.1 ENGINEERED WOOD PRODUCTS.
ENGINEERED WOOD PRODUCTS SHALL BE IN ACCORDANCE WITH SECTION R302.

R307.2.2 PLASTIC COMPOSITE DECK BOARDS, STAIR TREADS, GUARDS OR HANDRAILS.
PLASTIC COMPOSITE EXTERIOR DECK BOARDS, STAIR TREADS, GUARDS AND HANDRAILS SHALL COMPLY WITH THE REQUIREMENTS OF ASTM D7692 AND SECTION R607.5. SEE SECTIONS R307.2.2.1 THROUGH R307.2.2.5 AND SECTIONS R307.2.3 THROUGHT R307.2.8 FOR FURTHER SPECIFICATIONS.

R307.2.3 FASTENERS AND CONNECTORS.
METAL FASTENERS AND CONNECTORS USED FOR ALL DECKS SHALL BE IN ACCORDANCE WITH SECTION R317.3 AND TABLE R307.2.3.

R307.3 FOOTINGS.
REFER TO THE IRC FOR INFORMATION REGARDING FOOTINGS.

R307.4 DECK POSTS.
FOR SINGLE-LEVEL WOOD-FRAMED DECKS WITH BEAMS SIZED IN ACCORDANCE WITH TABLE R307.5, DECK POST SIZE SHALL BE IN ACCORDANCE WITH TABLE R307.4.

R307.4.1 DECK POST TO FOOTING CONNECTION.
WHERE POSTS BEAR ON CONCRETE FOOTINGS IN ACCORDANCE WITH SECTION R403 AND FIGURE R307.4.1, LATERAL RESTRAINT SHALL BE PROVIDED BY MANUFACTURED CONNECTORS OR A MINIMUM POST EMBEDMENT OF 12 INCHES (305 MM) IN SURROUNDING SOILS OR CONCRETE. OTHER FOOTING SYSTEMS SHALL BE PERMITTED.

NOTE: SEE SECTION R307.4.1 FOR EXCEPTIONS

R307.5 DECK BEAMS.
MAXIMUM ALLOWABLE SPANS FOR WOOD DECK BEAMS, AS SHOWN IN FIGURE R307.5, SHALL BE IN ACCORDANCE WITH TABLE R307.5. BEAM PILES SHALL BE FASTENED WITH TWO ROWS OF 100 (3-INCH X 1.28-INCH) NAILS MINIMUM AT 16 INCHES (405 MM) ON CENTER ALONG EACH EDGE. BEAMS SHALL BE PERMITTED TO CANTILEVER AT EACH END UP TO ONE-FOURTH OF THE ALLOWABLE BEAM SPAN. DECK BEAMS OF OTHER MATERIALS SHALL BE PERMITTED WHERE DESIGNED IN ACCORDANCE WITH ACCEPTED ENGINEERING PRACTICES.

R307.7 DECKING.
MAXIMUM ALLOWABLE SPACING FOR JOISTS SUPPORTING DECKING SHALL BE IN ACCORDANCE WITH TABLE R307.7. WOOD DECKING SHALL BE ATTACHED TO EACH SUPPORTING MEMBER WITH NOT LESS THAN TWO NO. 10 (1.31 INCH) NAILS OR TWO NO. 8 WOOD SCREWS. OTHER APPROVED DECKING OR FASTENER SYSTEMS SHALL BE INSTALLED IN ACCORDANCE WITH THE MANUFACTURER'S INSTALLATION REQUIREMENTS.

R307.8 VERTICAL AND LATERAL SUPPORTS.
WHERE ATTACHMENT TO AN EXTERIOR WALL, DECK SHALL BE POSITIVELY ANCHORED TO THE PRIMARY STRUCTURE AND DESIGNED FOR BOTH VERTICAL AND LATERAL LOADS. SUCH ATTACHMENT SHALL NOT BE ACCOMPLISHED BY THE USE OF TOENAILS OR NAILS SUBJECT TO WITHDRAWAL. FOR DECKS WITH CANTILEVERED FRAMING MEMBERS, CONNECTION TO EXTERIOR WALLS OR OTHER FRAMING MEMBERS SHALL BE DESIGNED AND CONSTRUCTED TO RESIST UPLIFT RESULTING FROM THE FULL LIVE LOAD SPECIFIED IN TABLE R301.5 ACTING ON THE CANTILEVERED PORTION OF THE DECK, WHERE POSITIVE CONNECTION TO THE PRIMARY BUILDING STRUCTURE CANNOT BE VERIFIED DURING INSPECTION, DECKS SHALL BE SELF-SUPPORTING.

R307.8.1 DECK POST TO DECK FOOTING.
POSTS SHALL BEAR ON FOOTINGS IN ACCORDANCE WITH SECTION R403 AND FIGURE R307.8.1. POSTS SHALL BE RESTRAINED TO PREVENT LATERAL DISPLACEMENT AT THE BOTTOM SUPPORT. SUCH LATERAL RESTRAINT SHALL BE PROVIDED BY MANUFACTURED CONNECTORS OR FASTENERS IN ACCORDANCE WITH SECTION R307 AND THE MANUFACTURER'S INSTRUCTIONS OR A MINIMUM POST EMBEDMENT OF 12 INCHES (305 MM) IN SURROUNDING SOILS OR CONCRETE. PILES.

CHAPTER 6 :: WALL CONSTRUCTION

SECTION R601 GENERAL

R601.1 APPLICATION.
THE PROVISIONS OF THIS CHAPTER SHALL CONTROL THE DESIGN AND CONSTRUCTION OF WALLS AND PARTITIONS FOR BUILDINGS.

R601.2 REQUIREMENTS.
WALL CONSTRUCTION SHALL BE CAPABLE OF ACCOMMODATING ALL LOADS IMPOSED IN ACCORDANCE WITH SECTION R701 AND TRANSMITTING THE RESULTING LOADS TO THE SUPPORTING STRUCTURAL ELEMENTS.

SECTION R602 WOOD WALL FRAMING

R602.1 GENERAL.
WOOD AND WOOD-BASED PRODUCTS USED FOR LOAD SUPPORTING PURPOSES SHALL COMPLY WITH THE APPLICABLE PROVISIONS OF THIS SECTION. SEE SECTIONS R002.9.1 THROUGH R002.9.10 FOR FURTHER SPECIFICATIONS.

R602.2 GRADE STUDS SHALL BE A MINIMUM NO. 3, STANDARD OR STUD GRADE LUMBER.

NOTE: SEE SECTION R002.2.2 FOR EXCEPTION

R602.3 DESIGN AND CONSTRUCTION.
EXTERIOR WALLS OF WOODFRAME CONSTRUCTION SHALL BE DESIGNED AND CONSTRUCTED IN ACCORDANCE WITH THE PROVISIONS OF THIS CHAPTER AND FIGURES R602.3(1) AND R602.3(2), OR IN ACCORDANCE WITH AWC NDS, COMPONENTS OF EXTERIOR WALLS SHALL BE FASTENED IN ACCORDANCE WITH TABLE R602.3(1) THROUGH R602.3(4). WALL SHEATHING SHALL BE FASTENED DIRECTLY TO FRAMING MEMBERS AND WHERE PLACED ON THE EXTERIOR SIDE OF AN EXTERIOR WALL, SHALL BE CAPABLE OF RESISTING THE WIND PRESSURES LISTED IN TABLE R301.2(2) AND SHALL CONFORM TO THE REQUIREMENTS OF TABLE R602.3(3). WALL SHEATHING USED ONLY FOR EXTERIOR WALL COVERING PURPOSES SHALL COMPLY WITH SECTION R703. STUDS SHALL BE CONTINUOUS FROM SUPPORT AT THE SOLE PLATE TO A SUPPORT AT THE TOP PLATE TO RESIST LOADS PERPENDICULAR TO THE WALL. THE SUPPORT SHALL BE FOUNDATION OR FLOOR, CEILING OR ROOF DIAPHRAGM OR SHALL BE DESIGNED IN ACCORDANCE WITH ACCEPTED ENGINEERING PRACTICE.

NOTE: SEE SECTION R002.2.3 FOR EXCEPTION

SEE SECTIONS R002.3.1 THROUGH R002.3.6 FOR FURTHER SPECIFICATIONS.

REFER TO THE IRC FOR FURTHER INFORMATION ON THE FOLLOWING AREAS:

- R602.4 INTERIOR LOAD-BEARING WALLS.
- R602.5 INTERIOR NON-BEARING WALLS.
- R602.6 DRILLING AND NOTCHING OF STUDS.
- R602.7 HEADERS.
- R602.8 FRETWORKING REQUIRED.
- R602.9 CRIPPLE WALLS.

R602.10 WALL BRACING.
BUILDINGS SHALL BE BRACED IN ACCORDANCE WITH THIS SECTION OR, WHEN APPLICABLE, SECTION R802.12. WHERE A BUILDING, OR PORTION THEREOF, DOES NOT COMPLY WITH ONE OR MORE OF THE BRACING REQUIREMENTS IN THIS SECTION, THOSE PORTIONS SHALL BE DESIGNED AND CONSTRUCTED IN ACCORDANCE WITH SECTION R301.1.

REFER TO SECTIONS R02.16.1 THROUGH R02.16.12 FOR BRACED WALL PANELS, DESIGN AND CRITERIA.

REFER TO THE IRC FOR THE FOLLOWING SECTIONS:

SECTION R03 COLD-FORMED STEEL WALL FRAMING
SECTION R04 WOOD STRUCTURAL PANELS
SECTION R06 PARTICLEBOARD
SECTION R08 GENERAL MASONRY CONSTRUCTION
SECTION R07 GLASS UNIT MASONRY
SECTION R09 EXTERIOR CONC. WALL CONSTRUCTION
SECTION R10 (SEE BELOW)
SECTION R19 STRUCTURAL INSULATED PANEL WALL CONSTRUCTION

SECTION R608 EXTERIOR WINDOWS AND DOORS.

R608.1 GENERAL.
THIS SECTION PRESCRIBES PERFORMANCE AND CONSTRUCTION REQUIREMENTS FOR EXTERIOR WINDOWS AND DOORS INSTALLED IN WALLS. WINDOWS AND DOORS SHALL BE INSTALLED AND FLASHED IN ACCORDANCE WITH THE PENETRATION MANUFACTURER'S WRITTEN INSTRUCTIONS. WINDOW AND DOOR OPERINGS SHALL BE FASTENED IN ACCORDANCE WITH SECTION R704. A WRITTEN INSTALLATION INSTRUCTIONS SHALL BE PROVIDED BY THE PENETRATION MANUFACTURER FOR EACH WINDOW OR DOOR.

R608.2 PERFORMANCE. EXTERIOR WINDOWS AND DOORS SHALL BE CAPABLE OF RESISTING THE DESIGN WIND LOADS SPECIFIED IN TABLE R301.2(2) ADJUSTED FOR HEIGHT AND EXPOSURE IN ACCORDANCE WITH TABLE R301.2(3) OR DETERMINED IN ACCORDANCE WITH ASCE 7 USING THE ALLOWABLE STRESS DESIGN LOAD COMBINATIONS OF ASCE 7. FOR EXTERIOR WINDOWS AND DOORS TESTED IN ACCORDANCE WITH SECTIONS R703.3 AND R703.4, REQUIRED DESIGN WIND PRESSURES DETERMINED FROM ASCE 7 USING THE ULTIMATE STRENGTH DESIGN (USD) ARE PERMITTED TO BE MULTIPLIED BY 0.5. DESIGN WIND LOADS FOR EXTERIOR GLAZING NOT PART OF A LABELED ASSEMBLY SHALL BE PERMITTED TO BE DETERMINED IN ACCORDANCE WITH CHAPTER 24 OF THE IRC. DESIGN WIND LOADS FOR EXTERIOR GLAZING NOT PART OF A LABELED ASSEMBLY SHALL BE PERMITTED TO BE DETERMINED IN ACCORDANCE WITH CHAPTER 24 OF THE INTERNATIONAL BUILDING CODE.

R608.3 GARAGE DOORS.
GARAGE DOORS SHALL BE TESTED IN ACCORDANCE WITH EITHER ASTM E586 OR ANSI/ASMA 106, AND SHALL MEET THE ACCEPTANCE CRITERIA OF ANSI/ASMA 106.

CHAPTER 7 :: INTERIOR COVERING

R702.1 GENERAL.
INTERIOR COVERINGS OR WALL FINISHES SHALL BE INSTALLED IN ACCORDANCE WITH THIS CHAPTER AND TABLE R702.1(1), TABLE R702.1(2), TABLE R702.1(3) AND TABLE R702.3.6. INTERIOR MASONRY VENEER SHALL COMPLY WITH THE REQUIREMENTS OF SECTION R703.7.1 FOR SUPPORT AND SECTION R703.7.4 FOR FINISHES AND MATERIALS SHALL COMPLY WITH THE FLAME SPREAD AND SMOKE DEVELOPMENT REQUIREMENTS OF SECTION R702.3. SEE SECTIONS 702.2 THROUGH 702.7 FOR FURTHER SPECIFICATIONS.

SECTION R703 EXTERIOR COVERING

R703.1 GENERAL.
EXTERIOR WALLS SHALL PROVIDE THE BUILDING WITH A WEATHER-RESISTANT EXTERIOR WALL ENVELOPE. THE EXTERIOR WALL ENVELOPE SHALL INCLUDE FLASHING AS DESCRIBED IN SECTION R703.4.

R703.2 WATER-RESISTIVE BARRIER.
ONE LAYER OF NO. 15 ASPHALT FELT, FREE FROM HOLES AND BREAKS, COMPLYING WITH ASTM D225 FOR TYPE 1 FELT OR OTHER APPROVED WATER-RESISTIVE BARRIER SHALL BE APPLIED OVER STUDS OR SHEATHING OF ALL EXTERIOR WALLS. NO. 15 ASPHALT FELT SHALL BE APPLIED HORIZONTALLY WITH THE UPPER LAYER LAPPED OVER THE LOWER LAYER NOT LESS THAN 2 INCHES (51 MM), WHERE JOINTS OCCUR, FELT SHALL BE LAPPED NOT LESS THAN 6 INCHES (152 MM). OTHER APPROVED MATERIALS SHALL BE INSTALLED IN ACCORDANCE WITH THE WATER-RESISTIVE BARRIER MANUFACTURER'S INSTALLATION INSTRUCTIONS. NO. 15 ASPHALT FELT OR OTHER APPROVED WATER-RESISTIVE BARRIER MATERIAL SHALL BE CONTINUOUS TO THE TOP OF WALLS AND TERMINATED AT PENETRATIONS AND BUILDING APPENDAGES IN A MANNER TO MEET THE REQUIREMENTS OF THE EXTERIOR WALL ENVELOPE AS DESCRIBED IN SECTION R703.1.

R703.3 FASTENERS.
EXTERIOR WALL COVERINGS AND ROOF OVERHANG SOFFITS SHALL BE SECURELY FASTENED WITH ALUMINUM, GALVANIZED, STAINLESS STEEL OR RUST-PREVENTATIVE COATED NAILS OR STAPLES IN ACCORDANCE WITH TABLE R703.3(1) OR WITH OTHER APPROVED CORROSION-RESISTANT FASTENERS IN ACCORDANCE WITH THE WALL COVERING MANUFACTURER'S INSTALLATION INSTRUCTIONS. NAILS AND STAPLES SHALL COMPLY WITH ASTM F1667. NAILS SHALL BE T-HEAD, MODIFIED ROUND HEAD, OR ROUND HEAD WITH SMOOTH OR DEFORMED SHANKS. STAPLES SHALL HAVE A MINIMUM CROWN WIDTH OF 7/8 INCH (11.1 MM) OUTSIDE DIAMETER AND BE MANUFACTURED OF MINIMUM 18-GAUGE WIRE. WIRE REINFORCED, SYNTHETIC OR FOAM PLASTIC SHEATHING BRACING IS USED, WALLS OR STAPLES SHALL BE DRIVEN INTO THE STUDS. WHERE WOOD OR WOOD STRUCTURAL PANEL SHEATHING IS USED, FASTENERS SHALL BE DRIVEN INTO STUDS UNLESS OTHERWISE PERMITTED TO BE DRIVEN INTO SHEATHING IN ACCORDANCE WITH EITHER THE SIDING MANUFACTURER'S INSTALLATION INSTRUCTIONS OR TABLE R703.3.2.

R703.4 FLASHING.
APPROVED CORROSION-RESISTANT FLASHING SHALL BE APPLIED SHINGLE-FASHION IN A MANNER TO PREVENT ENTRY OF WATER INTO THE WALL CAVITY OR PENETRATION OF WATER TO THE BUILDING. FLASHING SHALL BE APPLIED HORIZONTALLY WITH SELF-ADHERED MEMBRANES USED AS FLASHING SHALL COMPLY WITH AAMA 711. FLUID-APPLIED MEMBRANES USED AS FLASHING IN EXTERIOR WALLS SHALL COMPLY WITH AAMA 714. THE FLASHING SHALL EXTEND TO THE SURFACE OF THE EXTERIOR WALL FINISH. APPROVED CORROSION-RESISTANT FLASHINGS SHALL BE INSTALLED AT THE FOLLOWING LOCATIONS:

- EXTERIOR WINDOW AND DOOR OPENINGS. FLASHING AT EXTERIOR WINDOW AND DOOR OPENINGS SHALL EXTEND TO THE SURFACE OF THE EXTERIOR WALL FINISH OR TO THE WATER-RESISTIVE BARRIER COMPLYING WITH SECTION 703.2 FOR SUBSEQUENT DRAINAGE. MECHANICALLY ATTACHED FLEXIBLE FLASHINGS SHALL COMPLY WITH AAMA 712. FLASHING AT EXTERIOR WINDOW AND DOOR OPENINGS SHALL BE INSTALLED IN ACCORDANCE WITH ONE OR MORE OF THE FOLLOWING:

REFER TO SECTION 1.1 THROUGH 1.3 FOR FURTHER SPECIFICATIONS.

REFER TO THE IRC FOR FURTHER INFORMATION ON THE FOLLOWING AREAS:

- R703.5 WOOD, HARDBOARD AND WOOD STRUCTURAL PANEL SIDING.
- R703.6 WOOD SHAKES AND SHINGLES.
- R703.7 EXTERIOR PLASTER.
- R703.8 ANCHORED STONE AND MASONRY VENEER, GENERAL.
- R703.9 EXTERIOR INSULATION AND FINISH SYSTEM (EIFS) WITH DRAINAGE.
- R703.10 FIBER CEMENT SIDING.
- R703.11 VINYL SIDING.
- R703.12 ADHERED MASONRY VENEER INSTALLATION.
- R703.13 INSULATED VINYL SIDING.
- R703.14 POLYPROPYLENE SIDING.
- R703.15 CLADDING ATTACHMENT OVER FOAM SHEATHING TO WOOD FRAMING.
- R703.16 CLADDING ATTACHMENT OVER FOAM SHEATHING TO COLD-FORMED STEEL FRAMING.
- R703.17 CLADDING ATTACHMENT OVER FOAM SHEATHING TO MASONRY OR CONCRETE WALL CONSTRUCTION.

CHAPTER 8 :: WOOD ROOF FRAMING

R802.1 GENERAL.
WOOD AND WOOD-BASED PRODUCTS USED FOR LOAD SUPPORTING PURPOSES SHALL CONFORM TO THE APPLICABLE PROVISIONS OF THIS SECTION.

SEE SECTIONS R02.1.1 THROUGH R02.1.7 FOR FURTHER SPECIFICATIONS.

R802.2 DESIGN AND CONSTRUCTION.
THE FRAMING DETAILS REQUIRED IN SECTION R802 APPLY TO ROOFS HAVING A MINIMUM SLOPE OF THREE UNITS VERTICAL IN 12 UNITS HORIZONTAL (25-PERCENT SLOPE) OR GREATER. ROOF-CEILING SHALL BE DESIGNED AND CONSTRUCTED IN ACCORDANCE WITH THE PROVISIONS OF THIS CHAPTER AND FIGURES R802.1(1), R802.1(2) AND R802.1(3) OR IN ACCORDANCE WITH AWC NDS. COMPONENTS OF ROOF-CEILING SHALL BE FASTENED IN ACCORDANCE WITH TABLE R802.3(1).

R802.3 FRAMING DETAILS.
RAFTERS SHALL BE FRAMED NOT MORE THAN 1 1/2-INCHES (38 MM) OFFSET FROM EACH OTHER TO RIDGE BOARD OR DIRECTLY OPPOSITE FROM EACH OTHER WITH A GUSSET PLATE AS A TIE. RIDGE BOARD SHALL BE NOT LESS THAN 1-INCH (25 MM) NOMINAL THICKNESS AND NOT LESS IN DEPTH THAN THE CUT END OF THE RAFTER. AT VALLEYS AND HIPS THERE SHALL BE A VALLEY OR HIP RAFTER NOT LESS THAN 2-INCH (51 MM) NOMINAL THICKNESS AND NOT LESS IN DEPTH THAN THE CUT END OF THE RAFTER. HIP AND VALLEY RAFTERS SHALL BE SUPPORTED AT THE RIDGE BY A BRACE TO A BEARING PARTITION OR BE DESIGNED TO CARRY AND DISTRIBUTE THE SPECIFIC LOAD AT THAT POINT, WHERE THE ROOF PITCH IS LESS THAN THREE UNITS VERTICAL IN 12 UNITS HORIZONTAL (25-PERCENT SLOPE), STRUCTURAL MEMBERS THAT SUPPORT RAFTERS AND CEILING JOISTS, SUCH AS RIDGE BEAMS, HIPS AND VALLEYS, SHALL BE DESIGNED AS BEAMS.

REFER TO THE IRC FOR FURTHER INFORMATION ON THE FOLLOWING AREAS:

- R802.4 ALLOWABLE CEILING JOIST SPANS.
- R802.5 ALLOWABLE RAFTER SPANS.
- R802.6 BEARING.
- R802.7 CUTTING, DRILLING AND NOTCHING.
- R802.8 LATERAL SUPPORT.
- R802.9 FRAMING OF OPENINGS.

R802.10 WOOD TRUSSES.

R802.10.1 TRUSS DESIGN DRAWINGS. TRUSS DESIGN DRAWINGS, PREPARED IN CONFORMANCE TO SECTION R02.10.1, SHALL BE PROVIDED TO THE BUILDING OFFICIAL AND APPROVED PRIOR TO INSTALLATION. TRUSS DESIGN DRAWINGS SHALL BE PROVIDED WITH THE SHIPMENT OF TRUSSES DELIVERED TO THE JOB SITE. TRUSS DESIGN DRAWINGS SHALL INCLUDE, AT A MINIMUM, THE FOLLOWING INFORMATION:

REFER TO SECTION R02.10.1 (1)-(12 FOR MINIMUM INFORMATION)

R802.10.2 DESIGN.
WOOD TRUSSES SHALL BE DESIGNED IN ACCORDANCE WITH ACCEPTED ENGINEERING PRACTICE. TRUSS DESIGN DRAWINGS SHALL COMPLY WITH ANSWI 11. THE TRUSS DESIGN DRAWINGS SHALL BE PREPARED BY A REGISTERED PROFESSIONAL ENGINEER WHERE REQUIRED BY THE STATUTES OF THE JURISDICTION IN WHICH THE PROJECT IS TO BE CONSTRUCTED IN ACCORDANCE WITH SECTION R108.1.

R802.10.3 BRACING.
TRUSSES SHALL BE BRACED TO PREVENT ROTATION AND PROVIDE LATERAL STABILITY IN ACCORDANCE WITH THE REQUIREMENTS SPECIFIED IN THE CONSTRUCTION DOCUMENTS FOR THE BUILDING AND ON THE INDIVIDUAL TRUSS DESIGN DRAWINGS. IN THE ABSENCE OF SPECIFIC BRACING REQUIREMENTS, TRUSSES SHALL BE BRACED IN ACCORDANCE WITH ACCEPTED INDUSTRY PRACTICE SUCH AS THE SBCA BUILDING COMPONENT SAFETY INFORMATION (BCSI) GUIDE TO GOOD PRACTICE FOR HANDLING, INSTALLING & BRACING OF METAL PLATE CONNECTED WOOD TRUSSES.

R802.10.4 ALTERATIONS TO TRUSSES.
TRUSS MEMBERS SHALL NOT BE CUT, NOTCHED, DRILLED, SPLICED OR OTHERWISE ALTERED IN ANY WAY WITHOUT THE APPROVAL OF A REGISTERED DESIGN PROFESSIONAL. ALTERATIONS RESULTING IN THE ADDITION OF LOAD SUCH AS HVAC EQUIPMENT WATER HEATER THAT EXCEEDS THE DESIGN LOAD FOR THE TRUSS SHALL NOT BE PERMITTED WITHOUT VERIFICATION THAT THE TRUSS IS CAPABLE OF SUPPORTING SUCH ADDITIONAL LOADING.

R802.11 ROOF TIE-DOWN.

R802.11.1 UPLIFT RESISTANCE. ROOF ASSEMBLIES SHALL HAVE UPLIFT RESISTANCE IN ACCORDANCE WITH SECTIONS R802.11.1.1 AND R802.11.1.2. WHERE THE UPLIFT FORCE DOES NOT EXCEED 200 POUNDS (90.8 KG), RAFTERS AND TRUSSES SPACED NOT MORE THAN 24 INCHES (610 MM) ON CENTER SHALL BE PERMITTED TO BE ATTACHED TO THEIR SUPPORTING WALL ASSEMBLIES IN ACCORDANCE WITH TABLE R802.3(1). WHERE THE BASIC WIND SPEED DOES NOT EXCEED 115 MPH, THE WIND EXPOSURE CATEGORY IS B, THE ROOF PITCH IS 6:12 (42-PERCENT SLOPE) OR GREATER, AND THE ROOF SPAN IS 32 FEET (9754 MM) OR LESS, RAFTERS AND TRUSSES SPACED NOT MORE THAN 24 INCHES (610 MM) ON CENTER SHALL BE PERMITTED TO BE ATTACHED TO THEIR SUPPORTING WALL ASSEMBLIES IN ACCORDANCE WITH TABLE R802.3(1).

R802.11.1.1 TRUSS UPLIFT RESISTANCE.
TRUSSES SHALL BE ATTACHED TO SUPPORTING WALL ASSEMBLIES BY CONNECTIONS CAPABLE OF RESISTING UPLIFT FORCES AS SPECIFIED ON THE TRUSS DESIGN DRAWINGS FOR THE ULTIMATE DESIGN WIND SPEED AS DETERMINED BY TABLE R301.2(3) AND LISTED IN TABLE R301.2(1) OR AS SHOWN ON THE CONSTRUCTION DOCUMENTS. UPLIFT FORCES SHALL BE PERMITTED TO BE DETERMINED AS SPECIFIED BY TABLE R802.11, IF APPLICABLE, OR AS DETERMINED BY ACCEPTED ENGINEERING PRACTICE.

R802.11.1.2 RAFTER UPLIFT RESISTANCE.
INDIVIDUAL RAFTERS SHALL BE ATTACHED TO SUPPORTING WALL ASSEMBLIES BY CONNECTIONS CAPABLE OF RESISTING UPLIFT FORCES AS DETERMINED BY TABLE R802.11 OR AS DETERMINED BY ACCEPTED ENGINEERING PRACTICE. CONNECTIONS FOR BEAMS USED IN A ROOF SYSTEM SHALL BE DESIGNED IN ACCORDANCE WITH ACCEPTED ENGINEERING PRACTICE.

REFER TO THE IRC FOR THE FOLLOWING SECTIONS:

SECTION R03 ROOF SHEATHING
SECTION R04 COLD-FORMED STEEL ROOF FRAMING

SECTION R05 CEILING FINISHES

R05.1 CEILING INSTALLATION.
CEILING SHALL BE INSTALLED IN ACCORDANCE WITH THE REQUIREMENTS FOR INTERIOR WALL FINISHES AS PROVIDED IN SECTION R702.

SECTION R808

ROOF VENTILATION REQUIRED. ENCLOSED ATTICS AND ENCLOSED RAFTER SPACES FORMED WHERE CEILING ARE APPLIED DIRECTLY TO THE UNDERSIDE OF ROOF RAFTERS SHALL HAVE CROSS VENTILATION FOR EACH SEPARATE SPACE BY VENTILATING OPENINGS PROTECTED AGAINST THE ENTRANCE OF RAIN OR SNOW. VENTILATING OPENINGS SHALL HAVE A LEAST DIMENSION OF 1/8 INCH (3.18 MM) MINIMUM AND 1/4 INCH (6.35 MM) MAXIMUM. VENTILATING OPENINGS HAVING A LEAST DIMENSION LARGER THAN 1/4 INCH (6.35 MM) SHALL BE PROVIDED WITH CORROSION-RESISTANT WIRE CLOTH SCREENING, HARDWARE CLOTH PERFORATED VINYL OR SIMILAR MATERIAL WITH OPENINGS HAVING A LEAST DIMENSION OF 1/8 INCH (3.18 MM) MINIMUM AND 1/4 INCH (6.35 MM) MAXIMUM. OPENINGS IN ROOF FRAMING MEMBERS SHALL CONFORM TO THE REQUIREMENTS OF SECTION R802.7. REQUIRED VENTILATION OPENINGS SHALL OPEN DIRECTLY TO THE OUTSIDE AIR AND SHALL BE PROTECTED TO PREVENT THE ENTRY OF BIRDS, RODENTS, SNAKES, AND OTHER SIMILAR CREATURES.

R808.2 MINIMUM VENT AREA.
THE MINIMUM NET FREE VENTILATING AREA SHALL BE 1/80 OF THE AREA OF THE VENTED SPACE.

NOTE: SEE SECTION R002.2 FOR EXCEPTION

R808.3 VENT AND INSULATION CLEARANCE.
WHERE EAVE OR CORNICE VENTS ARE INSTALLED, BLOCKING, BRIDGING, AND INSULATION SHALL NOT BLOCK THE FREE FLOW OF AIR. NOT LESS THAN A 1-INCH (25 MM) SPACE SHALL BE PROVIDED BETWEEN THE INSULATION AND THE ROOF SHEATHING AND AT THE LOCATION OF THE VENT.

R808.4 INSTALLATION AND WEATHER PROTECTION.
VENTILATORS SHALL BE INSTALLED IN ACCORDANCE WITH MANUFACTURER'S INSTRUCTIONS. INSTALLATION OF VENTILATORS IN ROOF SYSTEMS SHALL BE IN ACCORDANCE WITH THE REQUIREMENTS OF SECTION R803. INSTALLATION OF VENTILATORS IN WALL SYSTEMS SHALL BE IN ACCORDANCE WITH THE REQUIREMENTS OF SECTION R075.1.

R808.5 UNVENTED ATTIC AND UNVENTED ENCLOSED RAFTER ASSEMBLIES. UNVENTED ATTICS AND UNVENTED ENCLOSED ROOF FRAMING ASSEMBLIES CREATED BY CEILING THAT ARE APPLIED DIRECTLY TO THE UNDERSIDE OF THE ROOF FRAMING MEMBERS AND STRUCTURAL ROOF SHEATHING APPLIED DIRECTLY TO THE TOP OF THE ROOF FRAMING MEMBERS/RAFTERS, SHALL BE PERMITTED WHERE ALL THE FOLLOWING CONDITIONS ARE MET:

SEE CONDITIONS R006.1 (1 THROUGH 6)

SECTION R807 ATTIC ACCESS

R807.1 ATTIC ACCESS.
BUILDINGS WITH COMBUSTIBLE CEILING OR ROOF CONSTRUCTION SHALL HAVE AN ATTIC ACCESS OPENING TO ATTIC AREAS THAT HAVE A VERTICAL HEIGHT OF 30 INCHES (762 MM) OR GREATER OVER AN AREA OF NOT LESS THAN 30 SQUARE FEET (2.8 M²). THE VERTICAL HEIGHT SHALL BE MEASURED FROM THE TOP OF THE CEILING FRAMING MEMBERS TO THE UNDERSIDE OF THE ROOF FRAMING MEMBERS.

THE ROUGH-FRAMED OPENING SHALL BE NOT LESS THAN 22 INCHES BY 30 INCHES (568 MM BY 762 MM) AND SHALL BE LOCATED IN A HALLWAY OR OTHER LOCATION WITH READY ACCESS, WHERE LOCATED IN A WALL, THE OPENING SHALL BE NOT LESS THAN 22 INCHES WIDE BY 30 INCHES HIGH (568 MM WIDE BY 762 MM HIGH), WHERE THE ACCESS IS LOCATED IN A CEILING, MINIMUM UNOBSTRUCTED HEADROOM IN THE ATTIC SPACE SHALL BE 80 INCHES (2032 MM) AT SOME POINT ABOVE THE ACCESS MEASURED VERTICALLY FROM THE BOTTOM OF CEILING FRAMING MEMBERS. SEE SECTION M306.1.3 FOR ACCESS REQUIREMENTS WHERE MECHANICAL EQUIPMENT IS LOCATED IN ATTICS.

CHAPTER 9 :: ROOF ASSEMBLIES

SECTION R901 GENERAL

R901.1 SCOPE. THE PROVISIONS OF THIS CHAPTER SHALL GOVERN THE DESIGN, MATERIALS, CONSTRUCTION AND QUALITY OF ROOF ASSEMBLIES.

CHAPTER 10 :: CHIMNEYS & FIREPLACES

R1001.1 GENERAL.
MASONRY FIREPLACES SHALL BE CONSTRUCTED IN ACCORDANCE WITH THIS SECTION AND THE APPLICABLE PROVISIONS OF CHAPTERS 3 AND 4.

FLOOR JOIST SPANS

FLOOR JOIST SPANS FOR SOUTHERN PINE SPECIES
(RESIDENTIAL LIVING AREA, LIVE LOAD = 40psf, L₀=260')
DEAD LOAD = 20psf


SIZE	SPACING (INCHES)	VISUALLY GRADED #2 SOUTHERN PINE (MAXIMUM CEILING JOIST SPANS) (FT. - IN.)
2x4	12.0	4-10
	16.0	6-6
	19.2	7-4
2x6	24.0	7-0
	12.0	12-6
	16.0	16-10
2x8	14.2	4-10
	24.0	8-10
	12.0	14-4
2x10	16.0	12-10
	19.2	11-8
	24.0	10-8
2x12	12.0	17-8
	16.0	18-1
	19.2	18-4
	24.0	12-4

NOTES:
The above tables are based on the IRC 2018 TABLE R302.3.1(2)

RAFTER SPANS

RAFTER SPANS FOR SOUTHERN PINE SPECIES
LIVE LOAD=50psf, L₀=180' DEAD LOAD = 10psf

SIZE	SPACING (INCHES)	SPANS (MAXIMUM RAFTER SPANS BETWEEN BRACINGS) (FT. - IN.)
2x6	12.0	12

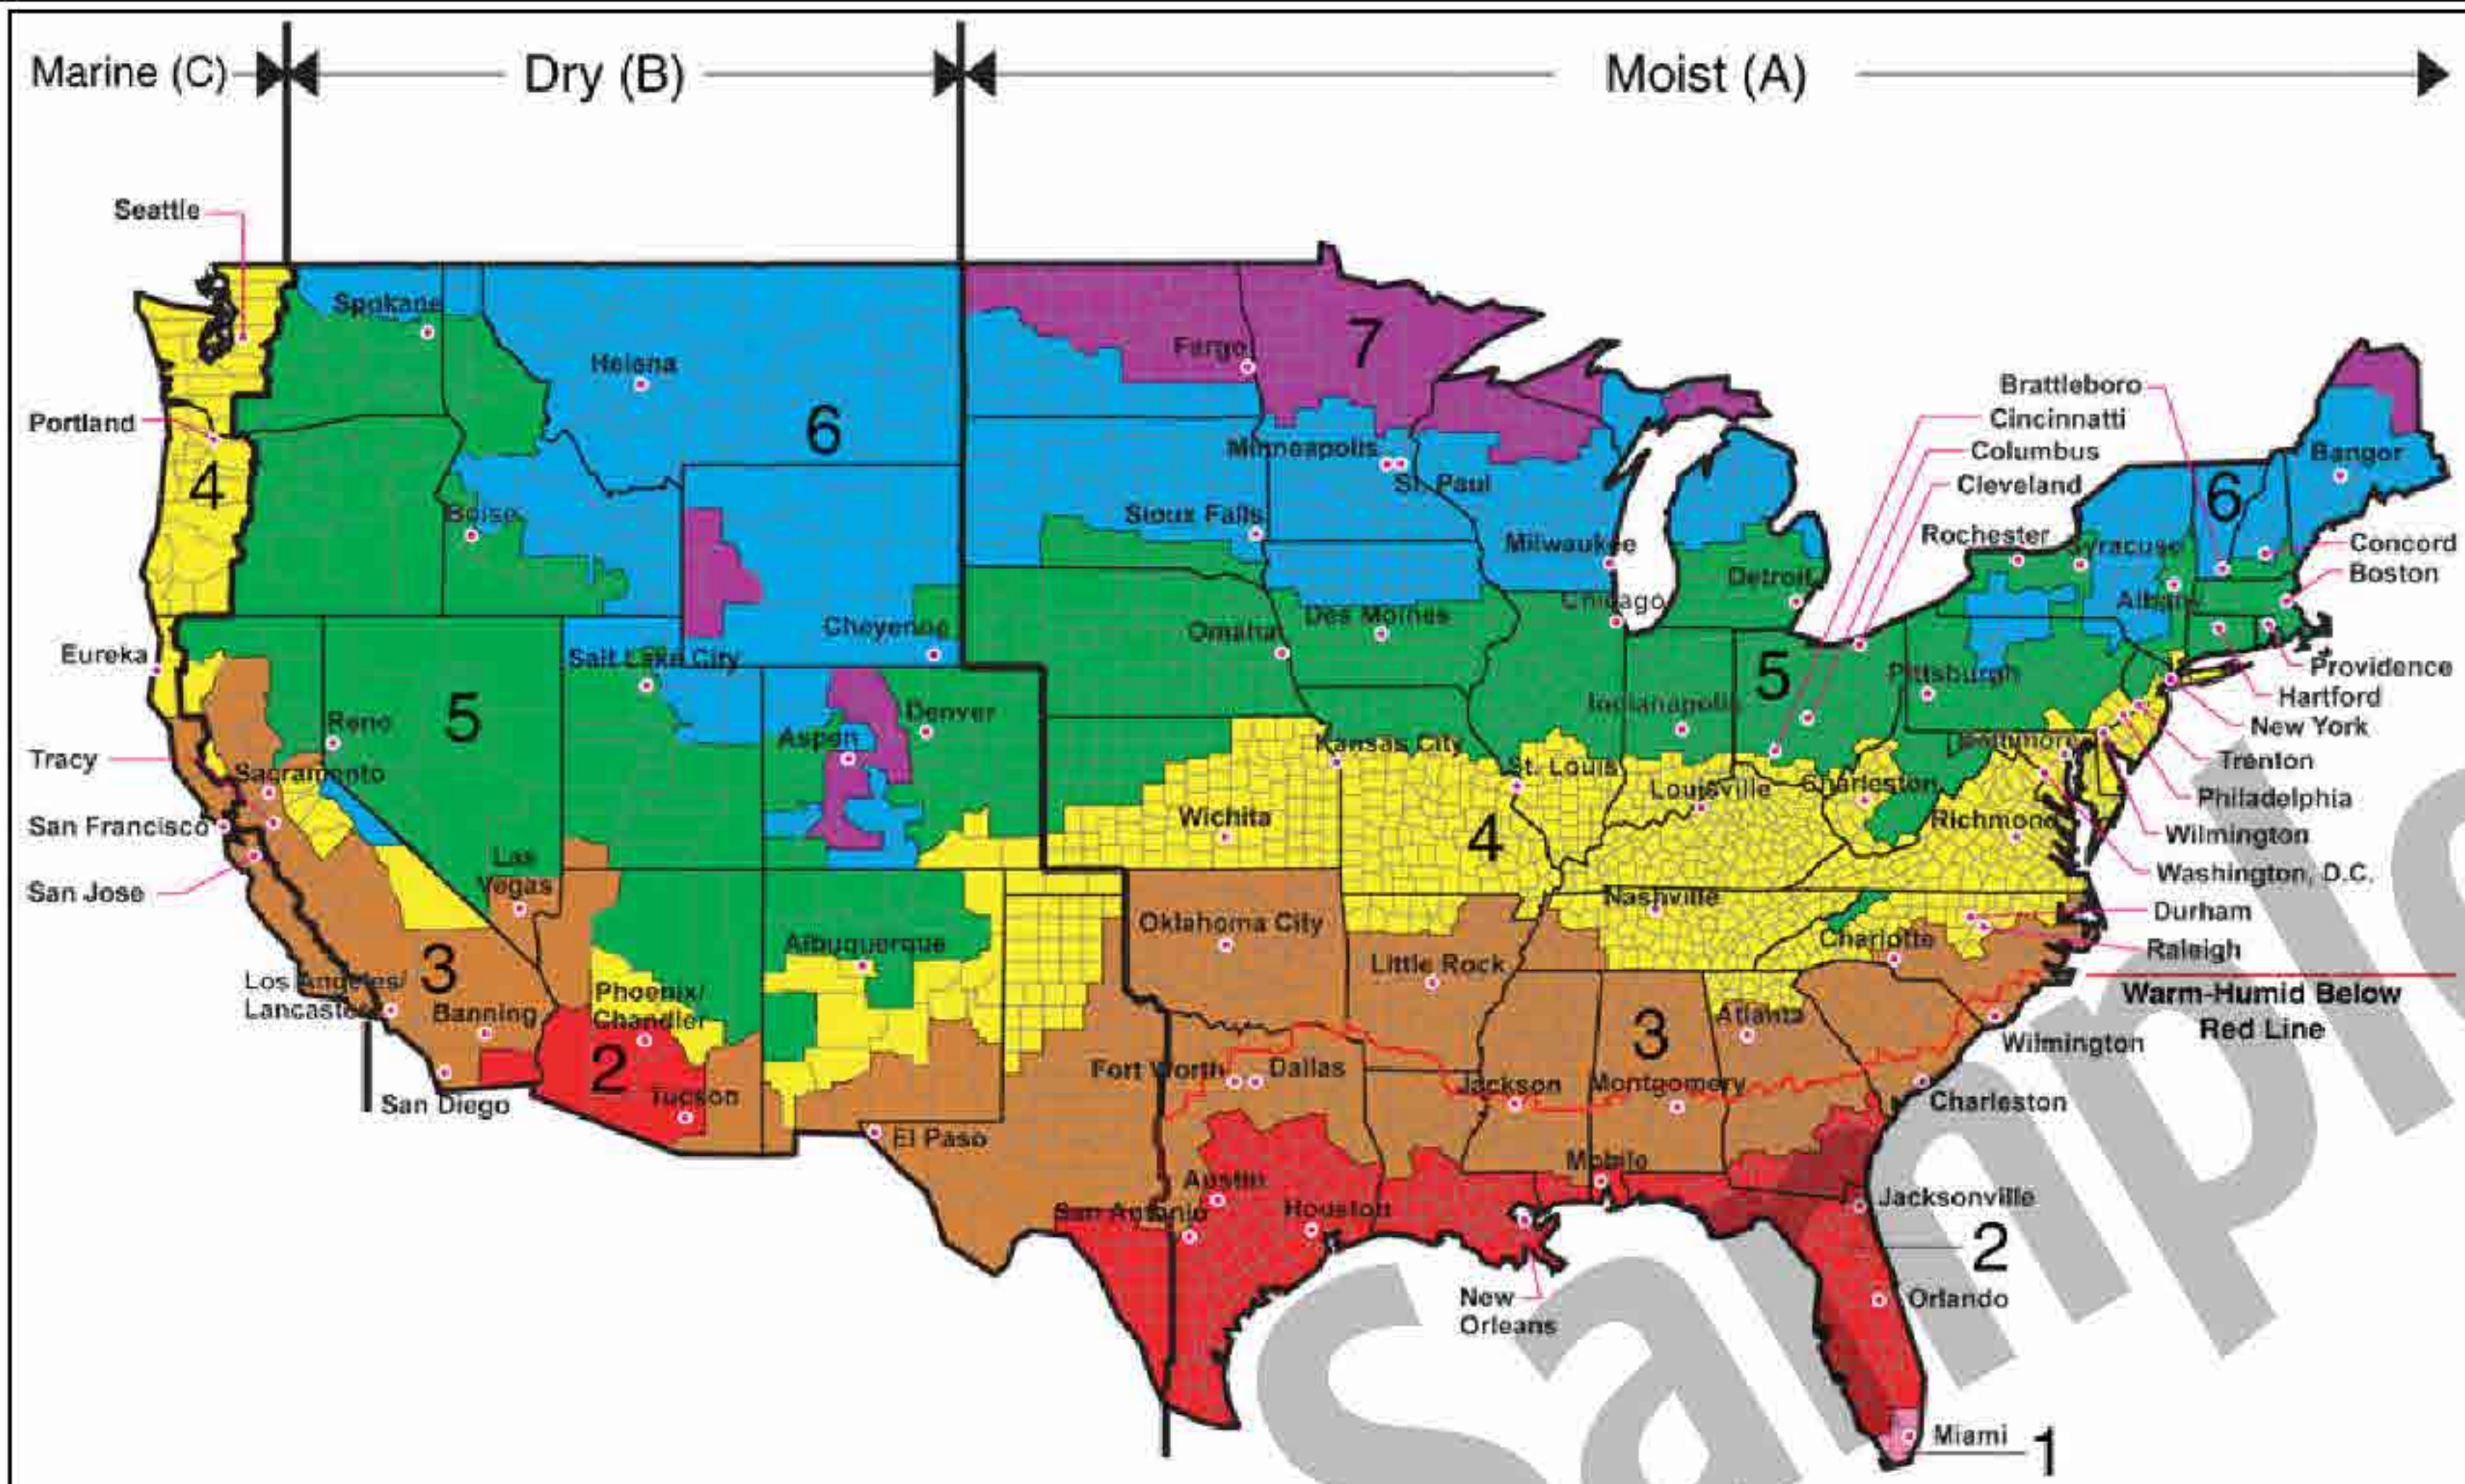

All of Alaska in Zone 7 except for the following Boroughs in Zone 8: Bethel, Dellingham, Fairbanks, N. Star, Nome North Slope, Northwest Arctic, Southeast Fairbanks, Wade Hampton, and Yukon-Koyukuk

Zone 1 includes: Hawaii, Guam, Puerto Rico, and the Virgin Islands

TABLE N1102.4.1.1 (R402.4.1.1)
AIR BARRIER AND INSULATION INSTALLATION (a)

COMPONENT	AIR BARRIER CRITERIA	INSULATION INSTALLATION CRITERIA
General requirements	A continuous air barrier shall be installed in the building envelope. The exterior thermal envelope contains a continuous air barrier. Breaks or joints in the air barrier shall be sealed.	Air-permeable insulation shall not be used as a sealing material.
Ceiling/attic	The air barrier in any dropped ceiling or soffit shall be aligned with the insulation and any gaps in the air barrier sealed. Access openings, drop down stairs or knee wall doors to unconditioned attic spaces shall be sealed.	The insulation in any dropped ceiling/soffit shall be aligned with the air barrier.
Walls	The junction of the foundation and sill plate shall be sealed. The junction of the top plate and the top of exterior walls shall be sealed. Knee walls shall be sealed.	Cavities within corners and headers of frame walls shall be insulated by completely filling the cavity with a material having a thermal resistance of not less than R-3 per inch. Exterior thermal envelope insulation for framed walls shall be installed in substantial contact and in continuous alignment with the air barrier.
Windows, skylights and doors	The space between framing and skylights, and framing the jamb of windows and doors, shall be sealed.	
Rim joists	Rim joists shall include the air barrier.	Rim joists shall be insulated.
Floors (including above garage and cantilevered floors) and floors above garages.	The air barrier shall be installed at any exposed edge of insulation.	Floor framing cavity insulation shall be installed to maintain permanent contact with the underside of subfloor decking. Alternatively floor framing cavity insulation shall be in contact with the top side of sheathing, or continuous insulation installed on the underside of floor framing; and extending from the bottom to the top of all perimeter floor framing members.
Crawl space walls	Exposed earth in unvented crawl spaces shall be covered with a Class I vapor retarder with overlapping joints taped.	Crawl space insulation, where provided instead of floor insulation, shall be permanently attached to the walls.
Shafts, penetrations	Duct shafts, utility penetrations, and flue shafts opening to exterior or unconditioned space shall be sealed.	
Narrow cavities		Batts to be installed in narrow cavities shall be cut to fit, or narrow cavities shall be filled with insulation that on installation readily conforms to the available cavity space.
Garage separation	Air sealing shall be provided between the garage and conditioned spaces.	
Recessed lighting	Recessed light fixtures installed in the building thermal envelope shall be sealed to the finished surface.	Recessed light fixtures installed in the building thermal envelope shall be air tight and IC rated.
Plumbing and wiring		In exterior walls, batt insulation shall be cut neatly to fit around wiring and plumbing or insulation that on installation, readily conforms to available space, shall extend behind piping and wiring.
Shower/tub on exterior wall	The air barrier installed at exterior walls adjacent to showers and tubs shall separate the wall from the shower or tub.	Exterior walls adjacent to showers and tubs shall be insulated.
Electrical/phone box on exterior walls	The air barrier shall be installed behind electrical and communication boxes. Alternatively, air-sealed boxes shall be installed.	
HVAC register boots	HVAC register boots that penetrate building thermal envelope shall be sealed to the subfloor or drywall.	
Concealed sprinklers	Where required to be sealed, concealed fire sprinklers shall only be sealed in a manner that is recommended by the manufacturer. Caulking or other adhesive sealants shall not be used to fill voids between fire sprinkler cover plates and walls or ceilings.	

(a) Inspection of log walls shall be in accordance with the provisions of ICC 400.
2018 INTERNATIONAL RESIDENTIAL CODE ©

TABLE N1102.1.2 (R402.1.2)
INSULATION AND PENETRATION REQUIREMENTS BY COMPONENT^a

CLIMATE ZONE	FENESTRATION U-FACTOR ^b	SKYLIGHT U-FACTOR ^b	GLAZED FENESTRATION SHGC ^c	CEILING R-VALUE	WOOD FRAME WALL R-VALUE	MASS WALL R-VALUE	FLOOR R-VALUE	BASEMENT WALL R-VALUE	SLAB R-VALUE & DEPTH	CRAWL SPACE WALL R-VALUE
1	NR	0.75	0.25	30	13	3/4	13	0	0	0
2	0.40	0.65	0.25	38	13	4/6	13	0	0	0
3	0.32	0.55	0.25	38	20 or 13 + 5h	8/13	19	5/13f	0	5/13
4 except Marine	0.32	0.55	0.40	49	20 or 13 + 5h	8/13	19	10/13	10, 2 ft	10/13
5 and Marine 4	0.30	0.55	NR	49	20 or 13 + 5h	13/17	30g	15/19	10, 2 ft	15/19
6	0.30	0.55	NR	49	20 + 5 or 13 + 10h	15/20	30g	15/19	10, 4 ft	15/19
7 and 8	0.30	0.55	NR	49	20 + 5 or 13 + 10h	19/21	38g	15/19	10, 4 ft	15/19

For SI: 1 foot = 304.8 mm.

a. R-values are minimums. U-factors and SEIGC are maximums. When insulation is installed in a cavity which is less than the label or design thickness of the insulation, the installed R-value of the insulation shall not be less than the R-value specified in the table.

b. The fenestration U-factor column excludes skylights. The SHGC column applies to all glazed fenestration. Exception: Skylights may be excluded from glazed fenestration SHGC requirements in Climate Zones 1 through 3 where the SHGC for such skylights does not exceed 0.30.

c. "15/19" means R-15 continuous insulation on the interior or exterior of the home or R-19 cavity insulation at the interior of the basement wall. "15/19" shall be permitted to be met with R-13 cavity insulation on the interior of the basement wall plus R-5 continuous insulation on the interior or exterior of the home. "10/13" means R-10 continuous insulation on the interior or exterior of the home or R-13 cavity insulation at the interior of the basement wall.

d. R-5 shall be added to the required slab edge R-values for heated slabs. Insulation depth shall be the depth of the footing or 2 feet, whichever is less in Zones 1 through 3 for heated slabs.

e. There are no SEIGC requirements in the Marine Zone.

f. Basement wall insulation is not required in warm-humid locations as defined by Figure N1101.10 and Table N1101.10.

g. Or insulation sufficient to fill the framing cavity, R-19 minimum.

h. The first value is cavity insulation, the second value is continuous insulation, so "13+5" means R-13 cavity insulation plus R-5 continuous insulation.

i. The second R-value applies when more than half the insulation is on the interior of the mass wall.

TABLE N1102.1.4 (R402.1.4)
EQUIVALENT U-FACTORS^a

CLIMATE ZONE	FENESTRATION U-FACTOR	SKYLIGHT U-FACTOR	CEILING U-FACTOR	FRAME WALL U-FACTOR	MASS WALL U-FACTOR ^b	FLOOR U-FACTOR	BASEMENT WALL U-FACTOR	CRAWL SPACE WALL U-FACTOR
1	0.50	0.75	0.035	0.084	0.197	0.064	0.360	0.477
2	0.40	0.65	0.030	0.084	0.165	0.064	0.360	0.477
3	0.35	0.55	0.030	0.060	0.098	0.047	0.091c	0.136
4 except Marine	0.35	0.55	0.026	0.060	0.098	0.047	0.059	0.065
5 and Marine 4	0.32	0.55	0.026	0.060	0.082	0.033	0.050	0.055
6	0.32	0.55	0.026	0.045	0.060	0.033	0.050	0.055
7 and 8	0.32	0.55	0.026	0.045	0.057	0.028	0.050	0.055

a. Nonfenestration U-factors shall be obtained from measurement, calculation or an approved source.

b. When more than half the insulation is on the interior, the mass wall U-factors shall be a maximum of 0.17 in Zone 1, 0.14 in Zone 2, 0.12 in Zone 3, 0.087 in Zone 4 except Marine, 0.065 in Zone 5 and Marine 4, and 0.057 in Zones 6 through 8.

c. Basement wall U-factor of 0.360 in warm-humid locations as defined by Figure N1101.10 (R301.1) and Table N1101.10 (R301.1).



Code Year: 2018
International Residential Code
Energy Efficiency and Conservation

Date: 02.10.20

SHEET NUMBER
N4